




SEAL 07/09/2019

**TRINITY
ENGINEERING
GROUP INC.**

1081 THOMPSON BRIDGE RD
GAINESVILLE, GA 30501
TEL: (770) 535-1044
FAX: (770) 535-0037

CONSULTANT

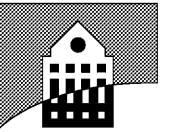

HLH

**H. LLOYD HILL
ARCHITECTS
& ASSOCIATES, INC.**

736 GREEN STREET
GAINESVILLE, GA 30501
(770) 534-8404

ARCHITECT

OWNERSHIP OF DOCUMENTS:
DRAWINGS AND SPECIFICATIONS AS
INSTRUMENTS OF SERVICE ARE
EXCLUSIVE PROPERTY OF TRINITY
ENGINEERING GROUP INC.
WHETHER THE PROJECT FOR
WHICH THEY WERE PREPARED IS
EXECUTED & CONSTRUCTED OR
NOT, THESE DOCUMENTS ARE NOT
TO BE REPRODUCED IN ANY FORM
AND ARE NOT TO BE USED BY THE
PROJECT OWNER NOR ANY OTHER
ENTITY ON OTHER PROJECTS OR
FOR ANY EXTENSIONS OR
ADDITIONS OR ALTERATIONS TO
THE ORIGINAL PROJECT EXCEPT BY
WRITTEN AUTHORIZATION &
PERMISSION FROM AND
AGREEMENT WITH TRINITY
ENGINEERING GROUP INC.

POWER PLAN - LOWER FLOOR

NEST FEATHERS
3621 MUNDY MILL ROAD
OAKWOOD, GEORGIA

REVISION / ISSUE

JOB NUMBER

2018-103

DRAWN


--

DATE

07/09/2019

SHEET

E-1.2

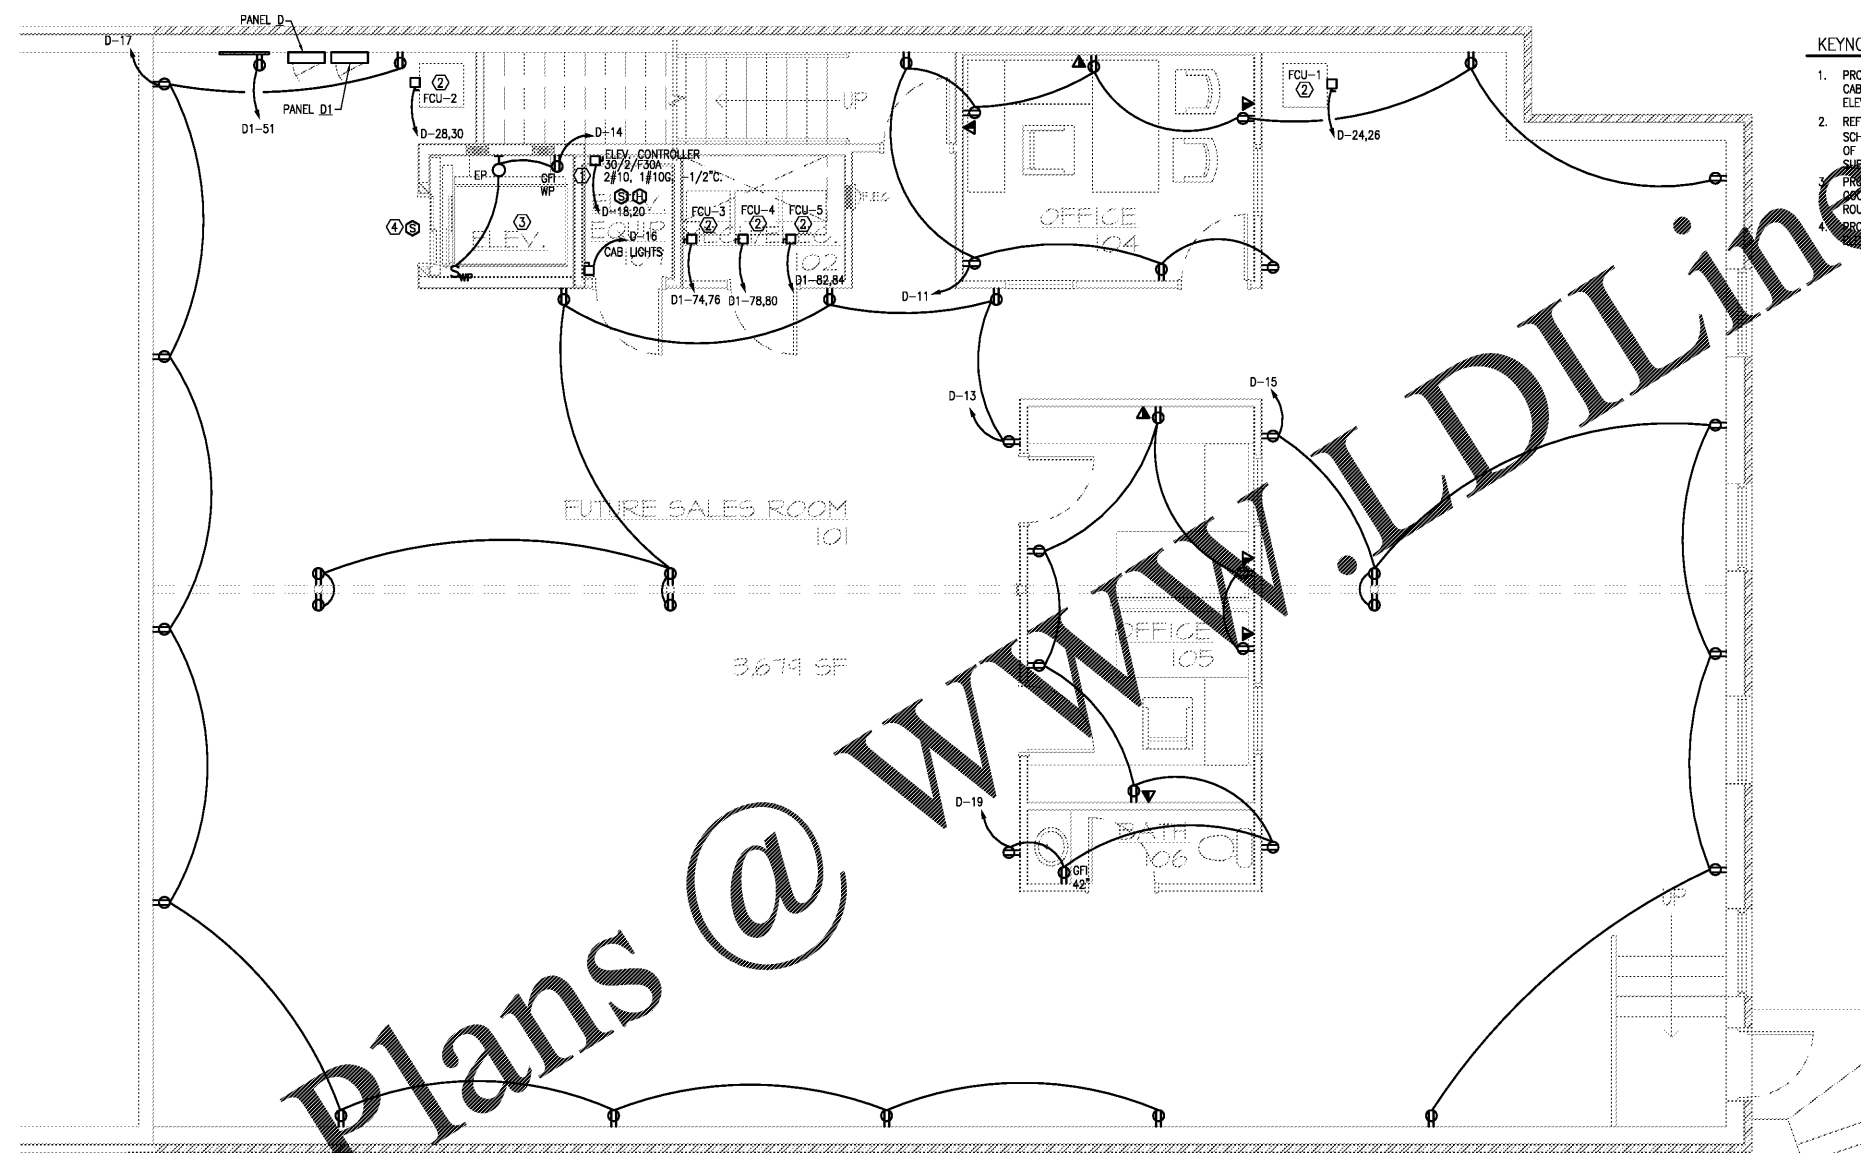

KEYNOTES: ⓧ

1. PROVIDE ELECTRICAL CONNECTION TO ELEVATOR OPERATOR AND ELEVATOR CAB LIGHTING CIRCUIT. COORDINATE EXACT REQUIREMENTS WITH THE ELEVATOR VENDOR PRIOR TO ROUGH-IN.
2. REFER TO THE MECHANICAL-ELECTRICAL EQUIPMENT CONNECTION SCHEDULE FOR ELECTRICAL CIRCUITING AND OVER-CURRENT PROTECTION OF THE UNIT. COORDINATE EXACT REQUIREMENTS WITH THE SUB-CONTRACTOR PRIOR TO ROUGH-IN.
3. PROVIDE A ELEVATOR UP LIGHT, SWITCH AND CONVENIENCE RECEPTACLE. COORDINATE EXACT PLACEMENT WITH ELEVATOR SUPPLIER PRIOR TO ROUGH-IN.
4. PROVIDE SMOKE DETECTOR FOR ELEVATOR RECALL. COORDINATE WITH ELEVATOR MANUFACTURER.

1 ELECTRICAL POWER PLAN- LOWER FLOOR
SCALE: 1/4" = 1'-0"

Order Plans @