


FILE NAME: E2.2.dwg

DIRECTORY: F:\2018-103 Nest Feathers\ELEC

PLOT DATE: Jul 09, 2019

Order Plans @

WWW.LDILine.com

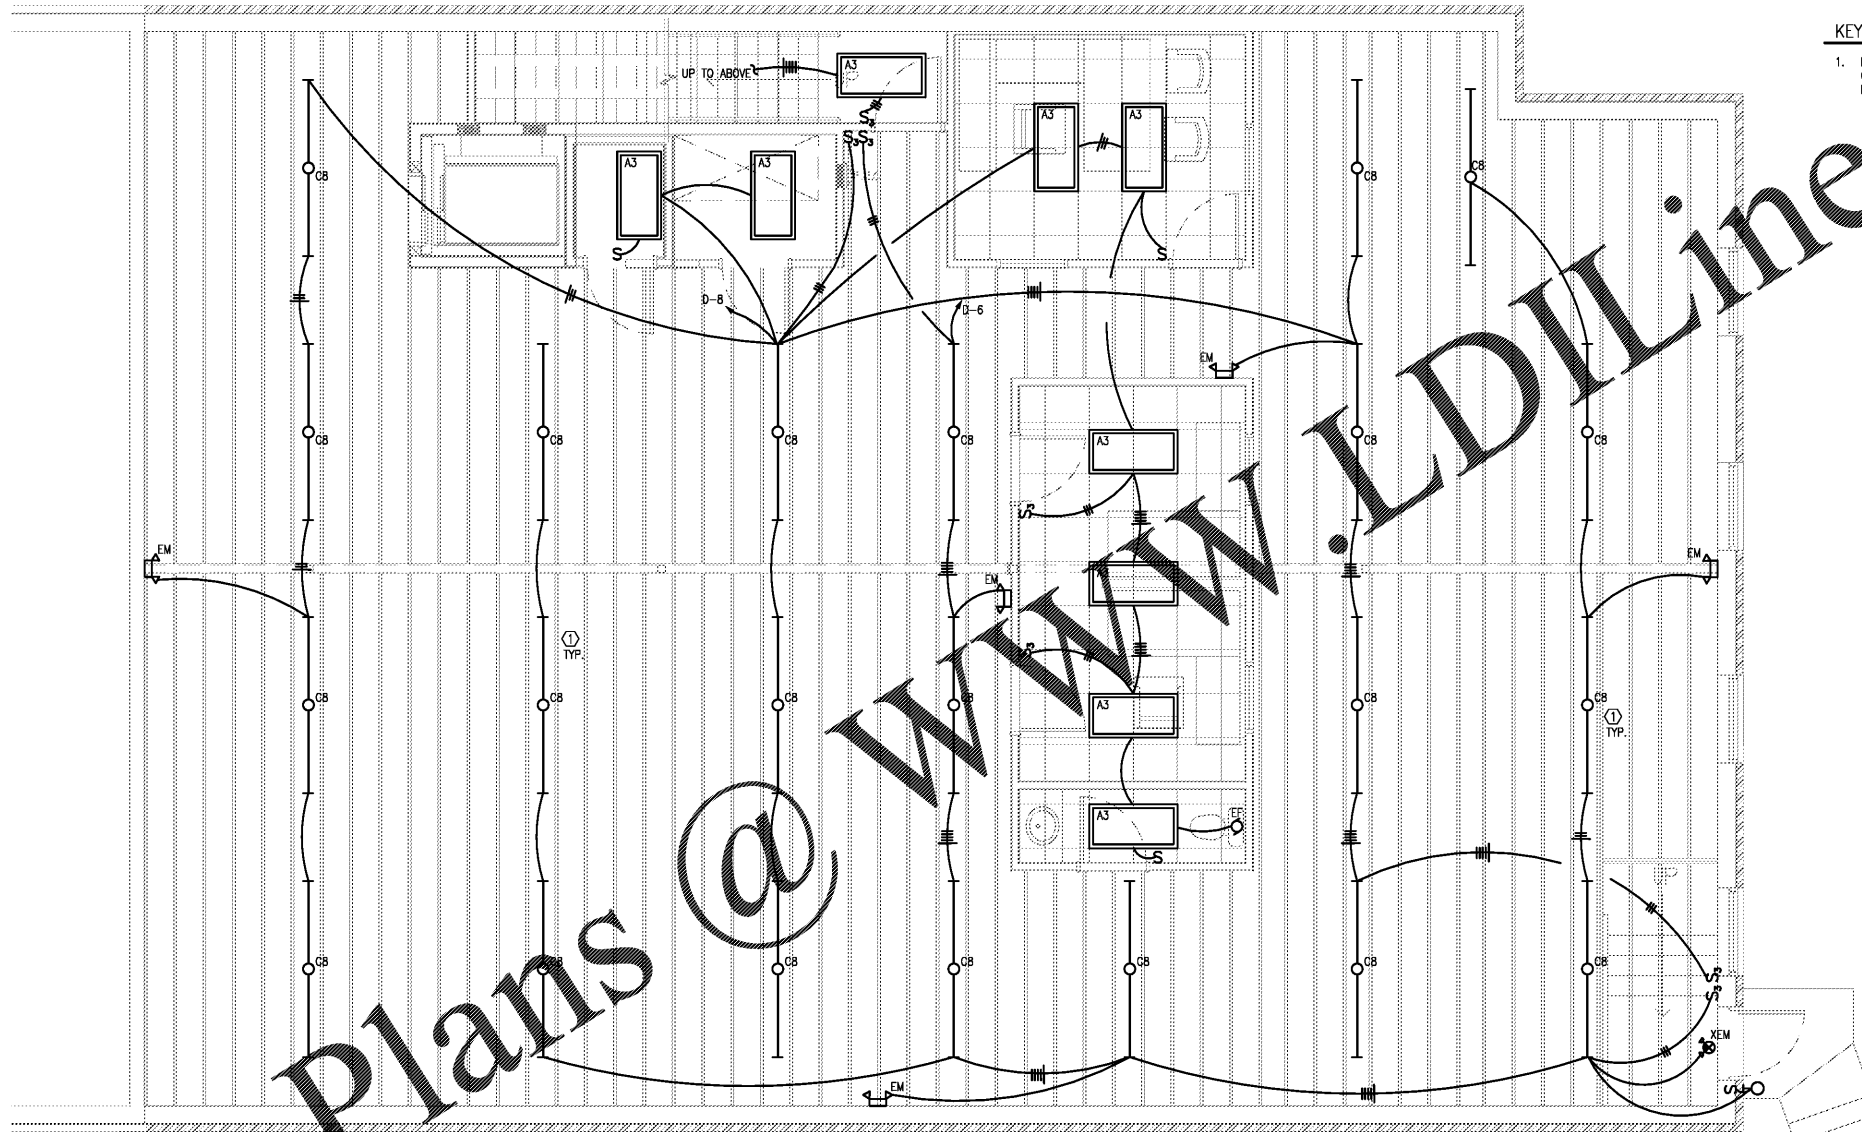

KEYNOTES: (X)

1. FIXTURES SHALL BE MOUNTED FLUSH WITH THE BOTTOM CHORD OF THE TRUSS ABOVE. COORDINATE FINAL PLACEMENT TO AVOID CONFLICT WITH ADJACENT PLUMBING, MECHANICAL, STRUCTURAL AND ARCHITECTURAL BUILDING COMPONENTS.

1 ELECTRICAL LIGHTING PLAN- LOWER FLOOR
 SCALE: 1/4" = 1'-0"



SEAL 07/09/2019

**TRINITY
 ENGINEERING
 GROUP INC.**

1081 THOMPSON BRIDGE RD
 GAINESVILLE, GA 30501
 TEL: (770) 535-1044
 FAX: (770) 535-0037

CONSULTANT



HLH
 H. LLOYD HILL
 ARCHITECTS
 & ASSOCIATES, INC.

736 GREEN STREET
 GAINESVILLE, GA 30501
 (770) 534-8404

ARCHITECT

OWNERSHIP OF DOCUMENTS:
 DRAWINGS AND SPECIFICATIONS AS
 INSTRUMENTS OF SERVICE ARE
 EXCLUSIVE PROPERTY OF TRINITY
 ENGINEERING GROUP INC.
 WHETHER THE PROJECT FOR
 WHICH THEY WERE PREPARED IS
 EXECUTED & CONSTRUCTED OR
 NOT, THESE DOCUMENTS ARE NOT
 TO BE REPRODUCED IN ANY FORM
 AND ARE NOT TO BE USED BY THE
 PROJECT OWNER NOR ANY OTHER
 ENTITY ON OTHER PROJECTS OR
 FOR ANY EXTENSIONS OR
 ADDITIONS OR ALTERATIONS TO
 THE ORIGINAL PROJECT EXCEPT BY
 WRITTEN AUTHORIZATION &
 PERMISSION FROM AND
 AGREEMENT WITH TRINITY
 ENGINEERING GROUP INC.

NEST FEATHERS
 3621 MUNDY MILL ROAD
 OAKWOOD, GEORGIA

LIGHTING PLAN - LOWER FLOOR

REVISION / ISSUE

JOB NUMBER

2018-103

DRAWN

--

DATE

07/09/2019

SHEET

E-2.2