



HLH
 H. LLOYD HILL
 ARCHITECTS
 & ASSOCIATES, INC.
 736 GREEN STREET
 GAINESVILLE, GA 30501
 (770) 534-8404




New Cornelia Branch
 Southern Bank & Trust
 Cornelia, Georgia
 COPYRIGHT © 2018 - H. LLOYD HILL ARCHITECTS AND ASSOCIATES, INC.

DATE	DESCRIPTION
04-09-2019	SCHEMATIC DESIGN DRAWINGS
04-30-2019	DESIGN DEVELOPMENT DRAWINGS
07-23-2019	CONSTRUCTION / BID DRAWINGS

PROJ. NO: G1902
 FILE NAME: .DWG
 DRAWN BY: --

SHEET TITLE:
**REFLECTED
 CEILING
 PLAN**

SHEET NUMBER:
A4.0

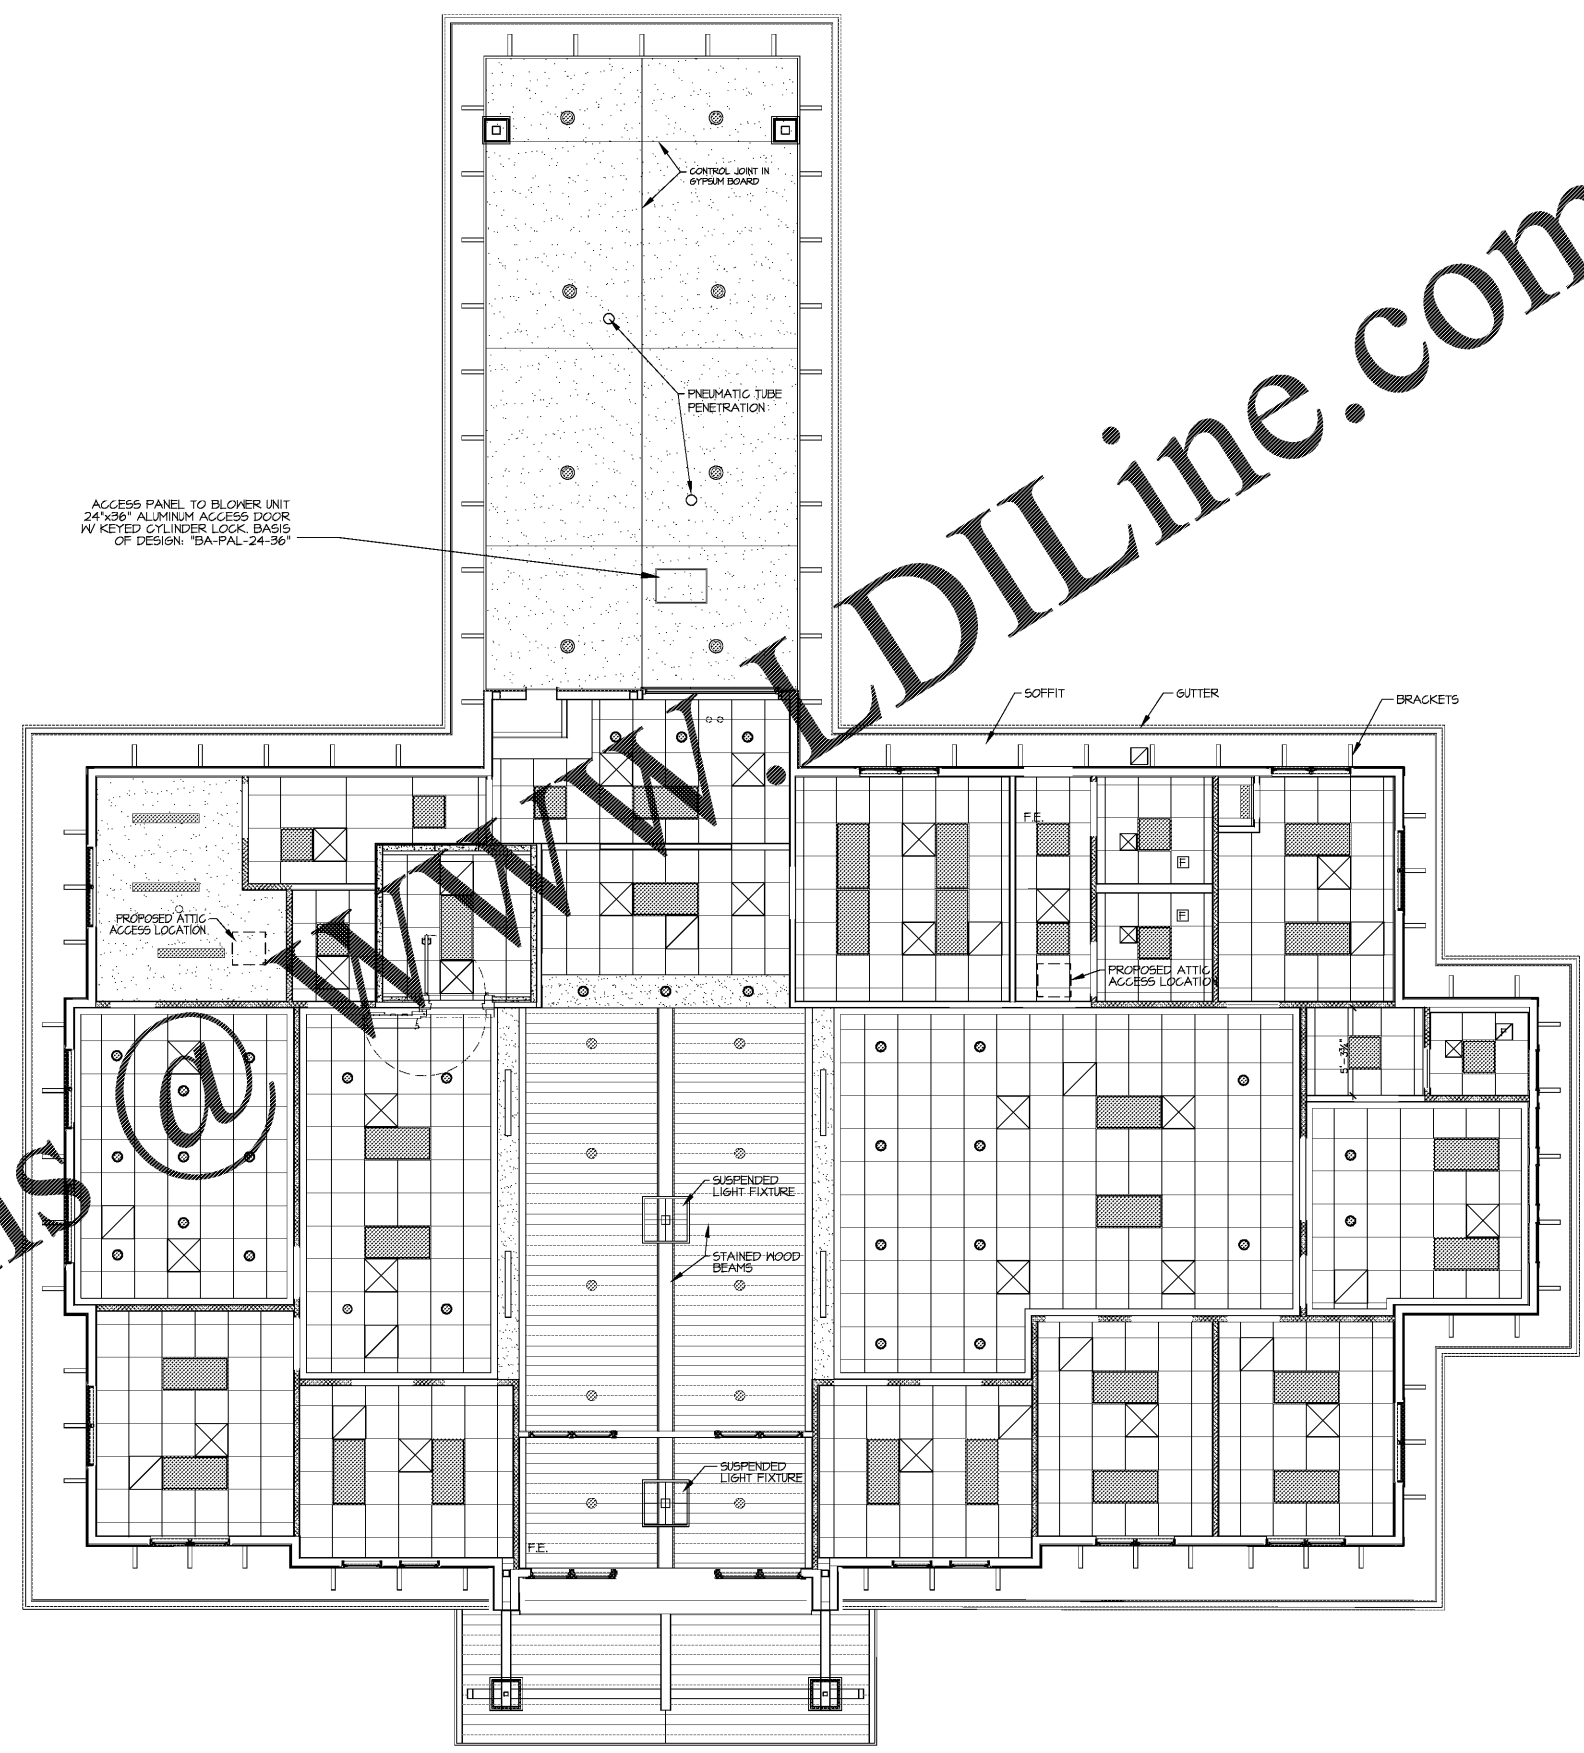

1 REFLECTED CEILING PLAN
 SCALE: 3/16" = 1'-0"

LEGEND:

	2'x2' LAY-IN ACOUSTIC TILE CEILING		LIGHT FIXTURE SURFACE MOUNT
	2'x4' LED LIGHT FIXTURE		GYPSUM BOARD (DRYWALL) CEILING
	2'x2' LED LIGHT FIXTURE		RECESSED DOWNLIGHT
	LANE OPEN/CLOSED LIGHT FIXTURE		EXHAUST FAN
	STAINED SHIPLAP CEILING BOARD		

WWW.HLHARCHITECTS.COM

Order Plans @