


LIGHTING FIXTURE SCHEDULE *

REFER TO ELECTRICAL SPECIFICATIONS FOR ADDITIONAL REQUIREMENTS WHICH MAY NOT NECESSARILY BE REFLECTED IN CATALOG NUMBER AND/OR DESCRIPTION IN THIS SCHEDULE. MATCH VOLTAGE OF FIXTURES TO CIRCUIT SERVING SAME.

MARK	DESCRIPTION	MOUNTING	VOLTS	LAMPS	REMARKS
A	COLUMBIA #1.CAT-24-35-VL-G-ED-U	RECESSED	120	FURNISHED WITH FIXTURE	--
B	COLUMBIA #1.CAT-24-35-HL-G-ED-U	RECESSED	120	FURNISHED WITH FIXTURE	--
BE	COLUMBIA #1.CAT-24-35-HL-G-ED-U-ELL14	RECESSED	120	FURNISHED WITH FIXTURE	1400 LUMEN BATTERY PACK
D	COLUMBIA #1.CAT-24-35-ML-G-ED-U	RECESSED	120	FURNISHED WITH FIXTURE	--
DE	COLUMBIA #1.CAT-24-35-ML-G-ED-U-ELL14	RECESSED	120	FURNISHED WITH FIXTURE	1400 LUMEN BATTERY PACK
F	COLUMBIA #1.CAT-22-35-HL-G-ED-U	RECESSED	120	FURNISHED WITH FIXTURE	--
FE	COLUMBIA #1.CAT-22-35-HL-G-ED-U-ELL14	RECESSED	120	FURNISHED WITH FIXTURE	1400 LUMEN BATTERY PACK
G	PRESCOLITE #LF68L-6LF8L-15L-35K	RECESSED	120	FURNISHED WITH FIXTURE	--
GE	PRESCOLITE #LF68L-6LF8L-15L-35K-EM	RECESSED	120	FURNISHED WITH FIXTURE	INTEGRAL TEST SWITCH
H	PRESCOLITE #LF68L-6LF8L-20L-35K	RECESSED	120	FURNISHED WITH FIXTURE	--
J	COLUMBIA #1.CL-4-35-ML-ED-U	SURFACE	120	FURNISHED WITH FIXTURE	--
K	LITHONIA #ELM2	WALL	120	FURNISHED WITH FIXTURE	--
L	LITHONIA #ARN-W	WALL	120	FURNISHED WITH FIXTURE	--
M	BEACON #VRY-D-36NB-80-4K-13-DBT-FEC-BFC	WALL	120	FURNISHED WITH FIXTURE	PHOTOCELL BUTTON, BATTERY PACK
N	LITHONIA #ARN-DB-EXT	WALL	120	FURNISHED WITH FIXTURE	--
P	SIGNAL TECH #TCL718GR-120	TOP	120	FURNISHED WITH FIXTURE	OPEN SIGN
Q	LITHONIA #LE-9-1-R-ELN	CEILING/WALL	120	FURNISHED WITH FIXTURE	--
R	ELITE #H16ADJ-LED-1502L-D1M10-120-UD-35K-80-H16ADJ-6555-SH2UH	RECESSED	120	FURNISHED WITH FIXTURE	ADJUST AIMING OF FIXTURE WITH OWNER/ARCHITECT
RE	ELITE #H16ADJ-LED-1502L-D1M10-120-UD-35K-EMG-LED-120-80-H16ADJ-6555-SH2UH	RECESSED	120	FURNISHED WITH FIXTURE	ADJUST AIMING OF FIXTURE WITH OWNER/ARCHITECT
T	LUMENPULSE LUMENCOVE NANO LQD-RO-UL-120-(LENGTH AS SHOWN)-35K-FR-UH	COVE	120	FURNISHED WITH FIXTURE	COORDINATE INSTALLATION WITH ARCHITECTURAL DETAILS. CONTRACTOR IS RESPONSIBLE FOR ALL ACCESSORIES FOR A COMPLETE INSTALLATION. REFER TO ARCHITECTURAL ELEVATIONS FOR EXACT LOCATION. PHOTO CELL BUTTON, INTEGRAL BATTERY PACK.
U	JUPITER #U-XL1-15/20-4K-120-BZ-BB-8206-EL-OU-OU	WALL	120	FURNISHED WITH FIXTURE	--
V	LUMENWERK #FOR9PO-33-HLO-80-400-35-120-01-1-5" SQUARE-DARK BRONZE FINISH-T-2" AIRCRAFT CABLES	PENDANT	120	FURNISHED WITH FIXTURE	--
W	COLUMBIA #CUC4-ED120-HARD WIRED WITH ROCKER SWITCH	UNDER COUNTER	120	FURNISHED WITH FIXTURE	REFER TO ARCHITECTURAL MILLWORK DRAWINGS FOR INSTALLATION.
X	SIGNAL TECH #TCL718A-125	TOP	120	FURNISHED WITH FIXTURE	ATM SIGN
OA	BEACON #VPL-36L-280-4K1-TC-200-A-DB 25'-0" DB 885 POLE	25'-0" DB 885 POLE	208	FURNISHED WITH FIXTURE	REFER TO 2/E-1
OB	BEACON #VPL-36L-280-4K1-4U-200-A-DB 25'-0" DB 885 POLE	25'-0" DB 885 POLE	208	FURNISHED WITH FIXTURE	REFER TO 2/E-1
OC	BEACON #VPL-36L-280-4K1-5QM-200-A-DB 25'-0" DB 885 POLE	25'-0" DB 885 POLE	208	FURNISHED WITH FIXTURE	REFER TO 2/E-1
OD	BEACON #AL-U-24L-55-4K1-6X6-120-SF3-DB	GROUND	120	FURNISHED WITH FIXTURE	CONCRETE BASE FLUSH WITH GROUND. INSTALL MATCHING SECTION.
OE	KIM #LTV8FT-8P-36L-4K-UV-5R	GROUND	120	FURNISHED WITH FIXTURE	--

* EQUALS BY LITHONIA, LIGHTOLIER, DAY-BRITE, WILLIAMS, METALUX, COLUMBIA, DUAL-LITE, AND EMERGI-LITE WILL BE ACCEPTABLE.

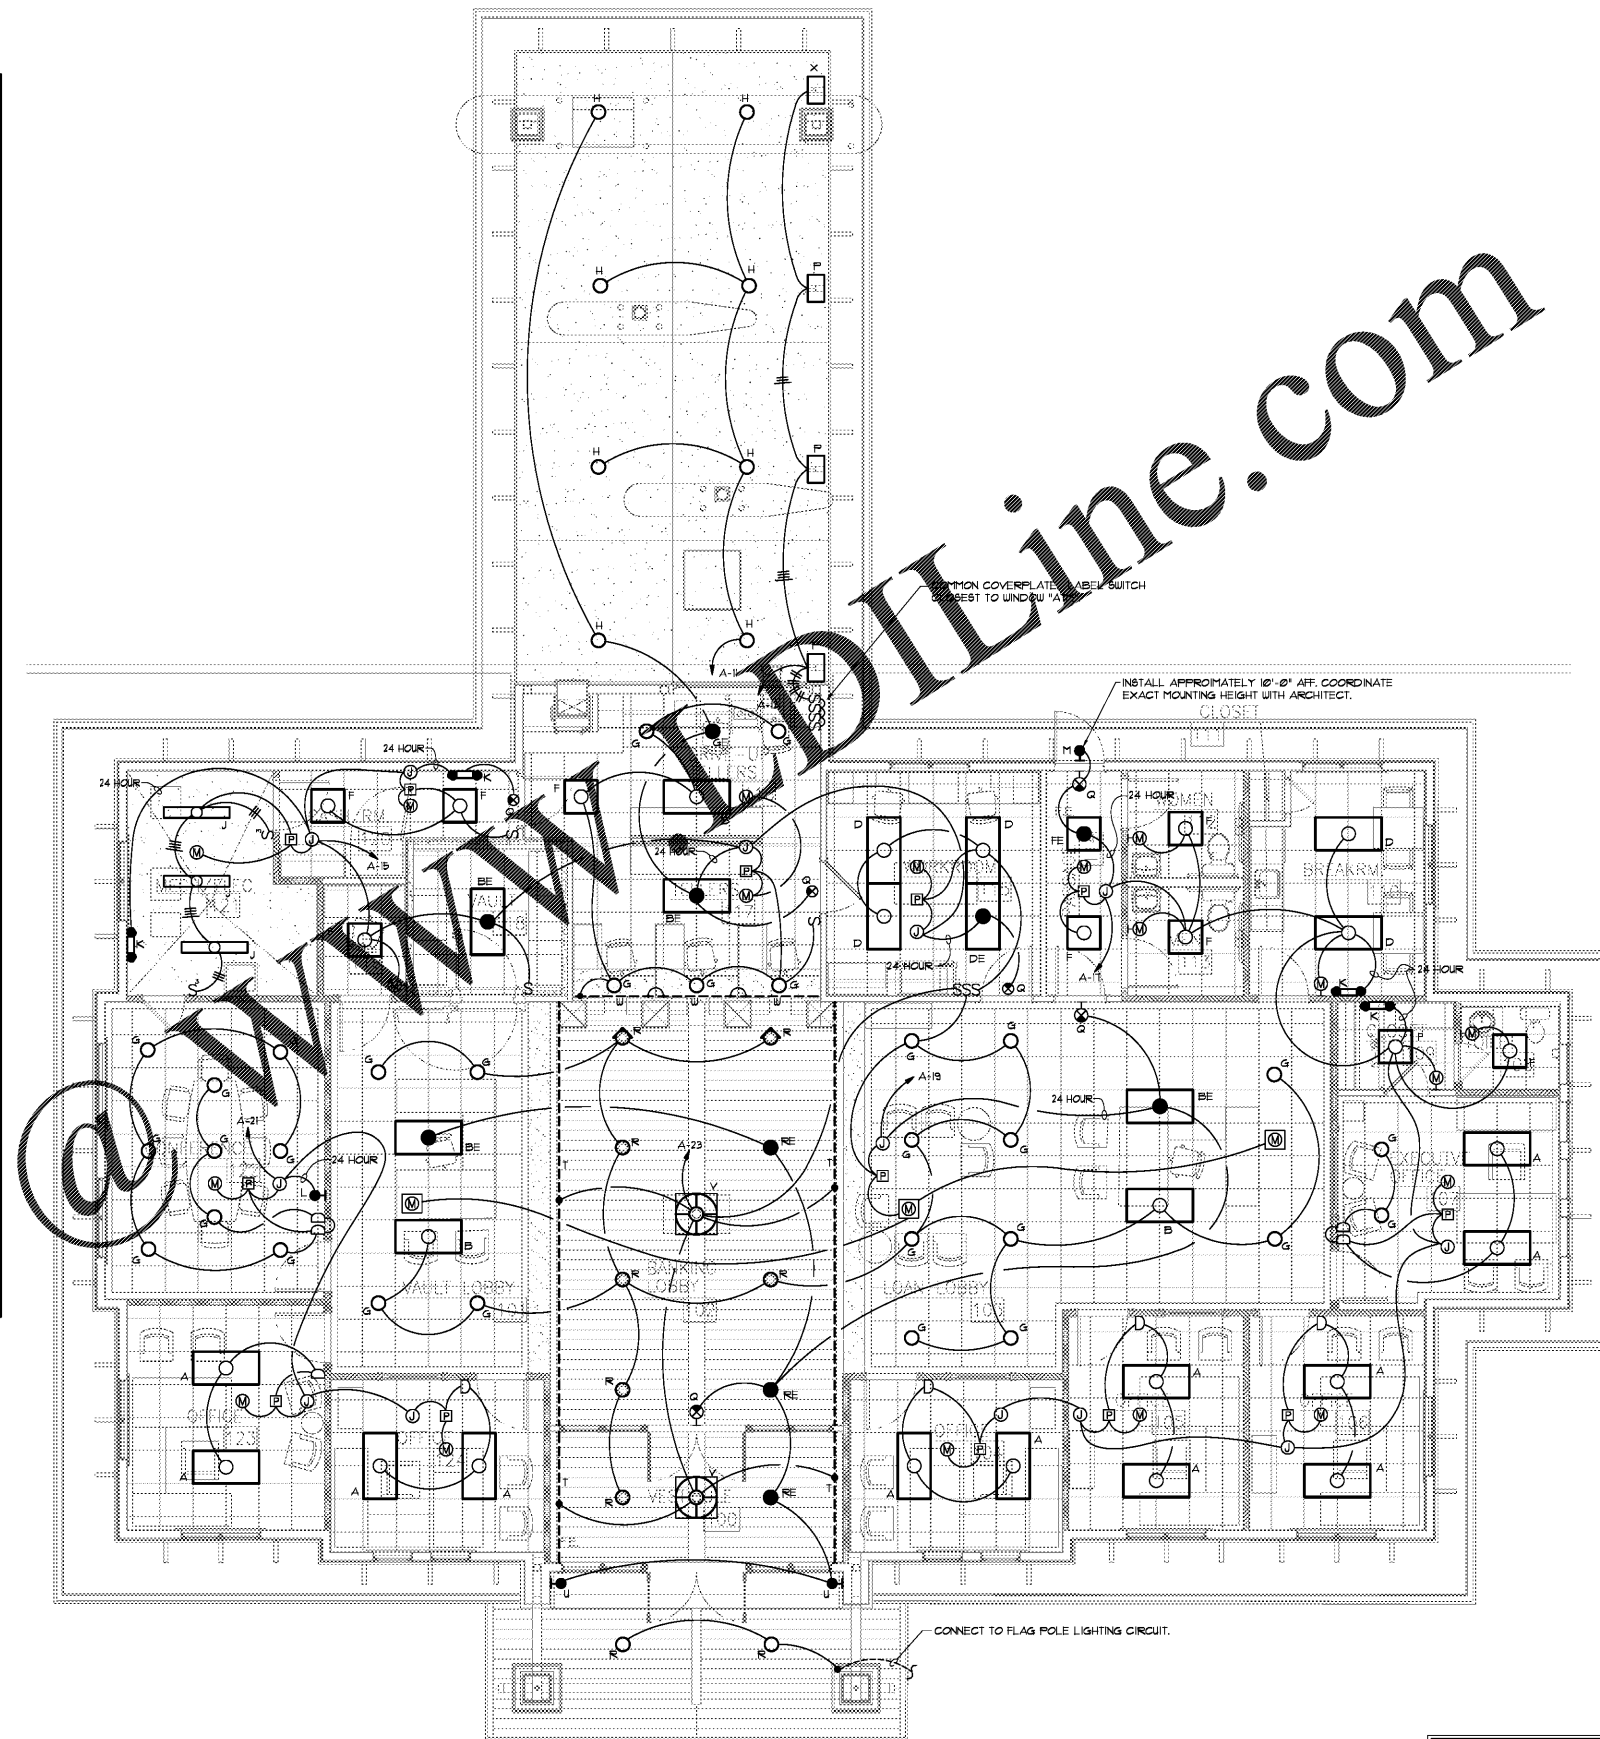

Order Plans

1 FLOOR PLAN - LIGHTING
E-3 SCALE: 3/16" = 1'-0"

MATHIS & ROBERDS
CONSULTING ENGINEERS
24 ODELL ROAD SUITE 6
GRIFFIN, GEORGIA 30224
TELEPHONE 770-228-8160

HLH
H. LLOYD HILL ARCHITECTS & ASSOCIATES, INC.
736 GREEN STREET
GAINESVILLE, GA 30501
(770) 534-8404

A.I.A.
No. PE029810
PROFESSIONAL ENGINEER
L. KEITH MATHIS
08-06-2015

New Cornelia Branch
Southern Bank & Trust
Cornelia, Georgia
COPYRIGHT (C) 2019 - H. LLOYD HILL ARCHITECTS AND ASSOCIATES, INC.

DATE	DESCRIPTION
04-09-2019	SCHEMATIC DESIGN DRAWINGS
04-30-2019	DESIGN DEVELOPMENT DRAWINGS
07-23-2019	CONSTRUCTION / BID DRAWINGS

PROJ. NO: G1902
FILE NAME:
DRAWN BY: CNH / JKM
SHEET TITLE:
FLOOR PLAN - LIGHTING
SHEET NUMBER:
E-3