



Order Plans @ WWW.LDILine.com

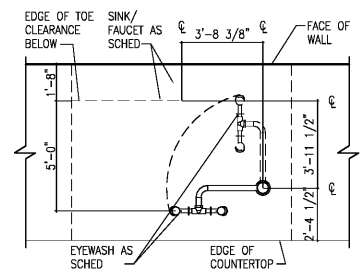


NOTE: PROVIDE EYEWASH ONLY WHEN REQUIRED BY CODE. COORDINATE WITH ARCHITECTURE DRAWINGS FOR WHICH SINKS SHALL RECEIVE EMERGENCY EYEWASH


1 EYEWASH MOUNTING DETAIL
P5 SCALE: 1" = 1'-0"

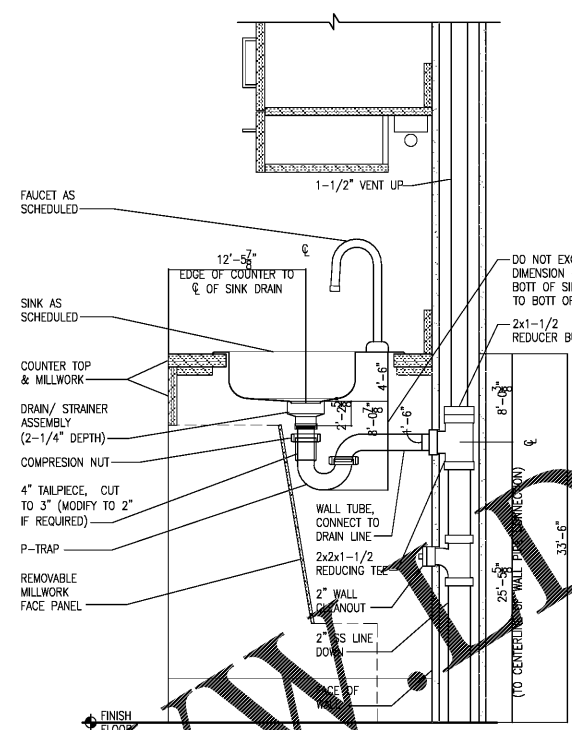


2 SINK PLUMBING SECTION
P5 SCALE: 1 1/2" = 1'-0"

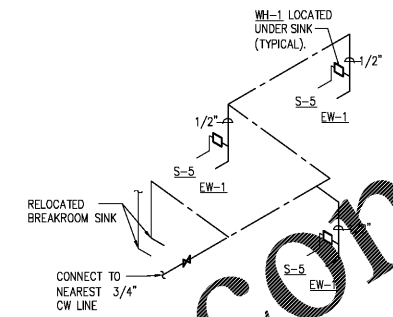

3 WATER RISER DIAGRAM
P5 SCALE: NTS

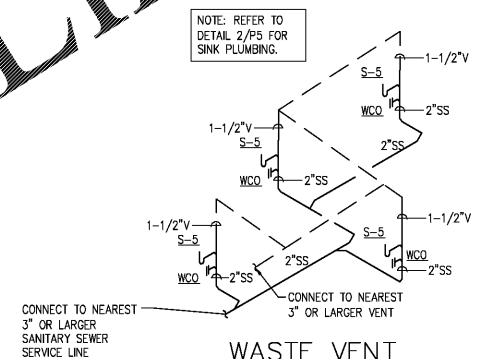

4 WASTE VENT RISER DIAGRAM
P5 SCALE: NTS

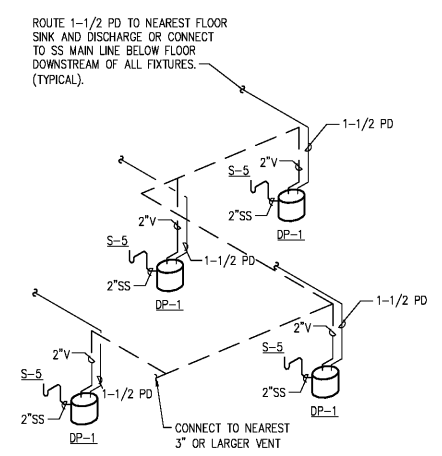

5 PUMP WASTE RISER DIAGRAM
P5 SCALE: NTS



STORE NUMBER: 4522
800 EAST WEST CONNECTOR
AUSTELL, GA
PROJECT TYPE: Health Hub and Reset
DEAL TYPE:
CS PROJECT NUMBER: 134320

ARCHITECT OF RECORD



11 South College St., Suite 400, Durham, NC 27601
P: 704.228.4242 F: 704.841.1700
www.littleonline.com

This drawing and the design shown are the property of Little Designful Architectural Consulting. The reproduction, copying or other use of this drawing without their written consent is prohibited and any infringement will be subject to legal action.
© Little 2019

CONSULTANT:



GEORGE W AUSTIN JR, PE
217 N. McDowell St. Suite 304
Charlotte, NC 28204
(P) 704.334.7363 (F) 704.347.0093
www.chelleng.com
SIG: 19-097

DEVELOPER:



SEAL:



REVISIONS:

CVS PROJECT MANAGER: SB

DRAWING BY: ZTM

DATE: 07-22-2019

JOB NUMBER: 121-12600-08

TITLE:

PLUMBING DETAILS AND RISER DIAGRAMS
SHEET NUMBER:

P5

COMMENTS: