



**STORE NUMBER:** 4522  
 800 EAST WEST CONNECTOR  
 AUSTELL, GA  
**PROJECT TYPE:** Health Hub and Reset  
**DEAL TYPE:**  
**CS PROJECT NUMBER:** 134320

ARCHITECT OF RECORD



22 South College St., Suite 500, Durham, NC 27601  
 T: 774.428.8700 F: 774.484.8700

www.littleonline.com

*This drawing and the design ideas are the property of Little Designline Architectural Consulting. The reproduction, copying or other use of this drawing without their written consent is prohibited and any infringement will be subject to legal action.*

CONSULTANT:



**Timothy A. Payne, PE**

222 N. WOODBRIDGE, SUITE 204  
 CHARLOTTE, NC 28206  
 (774) 428-8700 / (774) 484-8700  
 tpayne@tdcgroup.com | 916-139-1058

DEVELOPER:



SEAL:



REVISIONS:

CVS PROJECT MANAGER: SB

DRAWING BY: WRC

DATE: 07-22-2019

JOB NUMBER: 121-12600-08

TITLE:

OVERALL ELECTRICAL PLAN  
 - DEMO - LIGHTING


SHEET NUMBER:

E2

COMMENTS:

KEYNOTES

- 1 ALL LIGHT FIXTURES IN THIS AREA ARE EXISTING TO REMAIN, UNLESS NOTED OTHERWISE.
- 2 RELOCATE EXISTING LIGHT FIXTURE TO ACCOMMODATE NEW CONSTRUCTION/SIGNAGE. EXTEND EXISTING LIGHTING CIRCUIT TO NEW LOCATION, OR RE-WORK LIGHTING CIRCUIT(S), AND WIRE COMPLETELY.
- 3 EXISTING LIGHT FIXTURE SHALL BE DISCONNECTED, REMOVED AND TURNED OVER TO OWNER OR DISPOSED OF PROPERLY, AS DIRECTED. EXISTING LIGHTING CIRCUIT SHALL BE EXTENDED TO MAINTAIN ALL EXISTING LIGHT FIXTURES (TO REMAIN) IN OPERATION.
- 4 EXISTING CLINICS TO BE REPURPOSED. ALL EXISTING ELECTRICAL GEAR, FIXTURES, DEVICES, ETC. SHALL BE DEMOLISHED.
- 5 EXISTING FIRE ALARM DEVICE TO BE RELOCATED. DISCONNECT CABLING AT CURRENT LOCATION AND EXTEND TO NEW LOCATION.
- 6 REPLACE EXISTING MANUAL LIGHT SWITCH WITH NEW WALL-MOUNTED OCCUPANCY SENSOR LIGHT SWITCH, IF REQUIRED, RELOCATE SWITCH TO NEW WALL TO ACCOMMODATE NEW CONSTRUCTION.
- 7 EXISTING FIRE ALARM TO REMAIN.

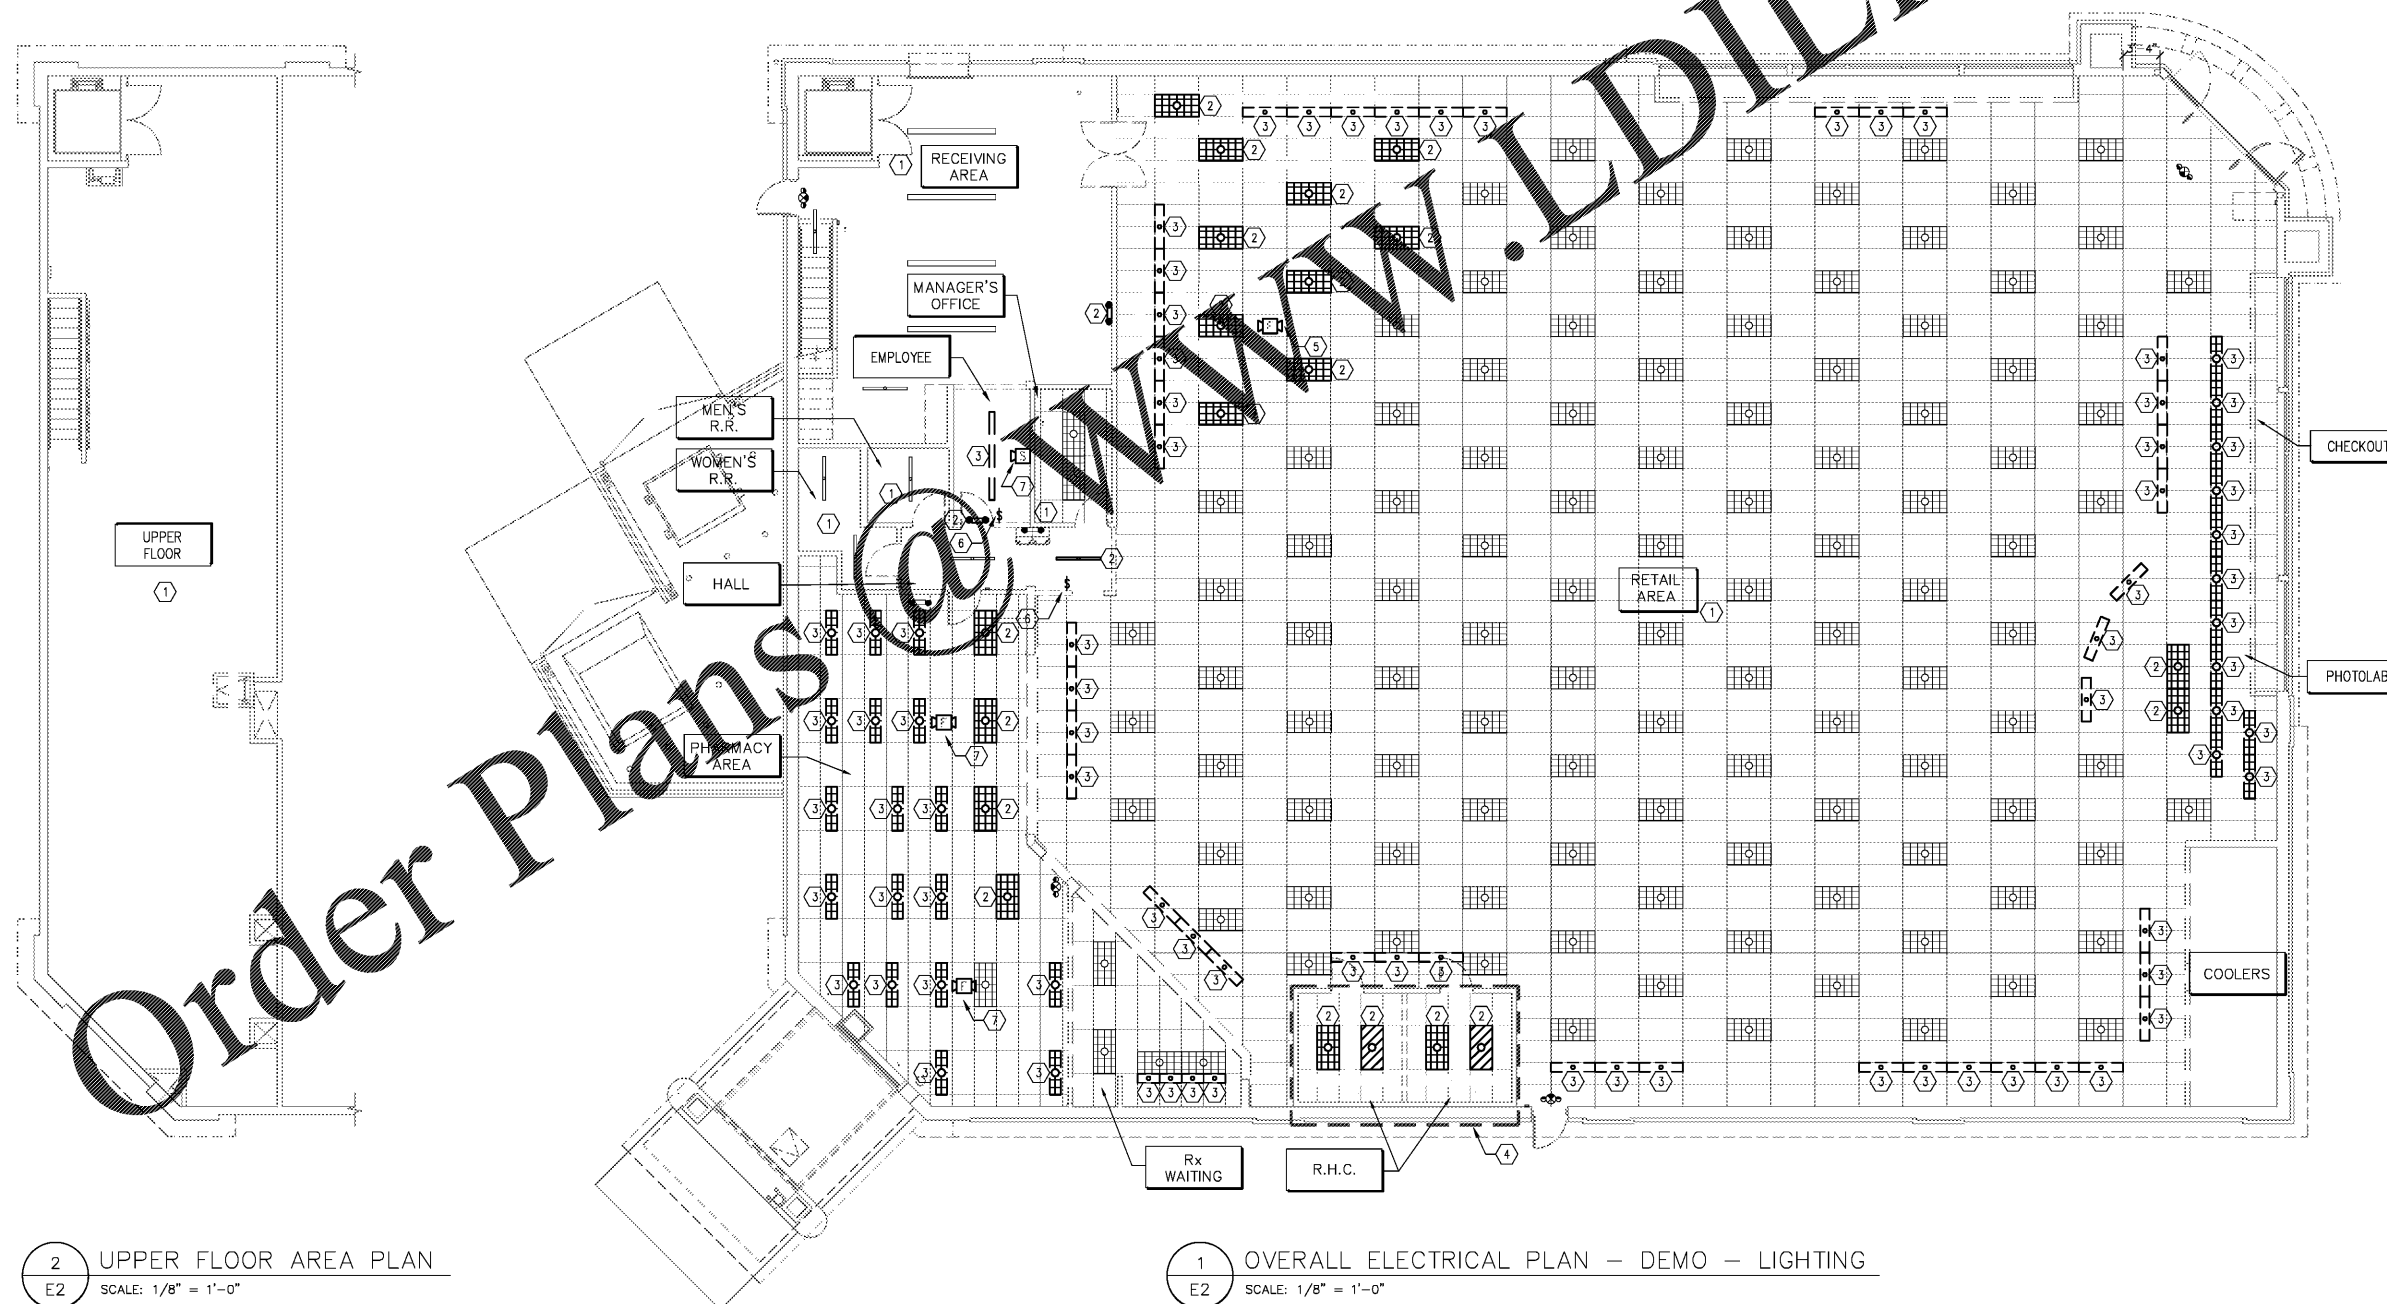

2 UPPER FLOOR AREA PLAN  
 E2 SCALE: 1/8" = 1'-0"

1 OVERALL ELECTRICAL PLAN - DEMO - LIGHTING  
 E2 SCALE: 1/8" = 1'-0"