



STORE NUMBER: 4522
 800 EAST WEST CONNECTOR
 AUSTELL, GA
PROJECT TYPE: Health Hub and Reset
DEAL TYPE:
CS PROJECT NUMBER: 134320

ARCHITECT OF RECORD



225 South College St., Suite 500, Durham, NC 27602
 T: 704.221.8200 F: 704.281.8700

www.littleonline.com

This drawing and the design ideas are the property of Little Diversified Architectural Consulting. The reproduction, copying or other use of this drawing without their written consent is prohibited and any infringement will be subject to legal action.
 © Little 2019

CONSULTANT:



DEVELOPER:



SEAL:



REVISIONS:

CVS PROJECT MANAGER: SB

DRAWING BY: WRC

DATE: 07-22-2019

JOB NUMBER: 121-12600-08

TITLE:

OVERALL ELECTRICAL PLAN
 - NEW - POWER


SHEET NUMBER:

E7

COMMENTS:

KEYNOTES

- 1 POWER AND DATA FOR RELOCATED BLOOD PRESSURE MACHINE. PROVIDE 3/4" CONDUIT WITH PULL STRING FROM DATA BOX TO ABOVE CEILING.
- 2 PROVIDE JUNCTION BOX FOR STOCKROOM ACCESS ALARM AT 48" AFF TO TOP OF BOX, FLUSH IN WALL WITH BLANK COVERPLATE. PROVIDE (1) 3/4"C FROM JUNCTION BOX TO ACCESS ALARM PANEL ABOVE DOOR.
- 3 PROVIDE DUPLEX RECEPTACLE FOR STOCKROOM ACCESS ALARM AT 10'-6" AFF. DUPLEX RECEPTACLE TO BE LOCATED ABOVE DOOR IN RECEIVING ROOM. RE-USE EXISTING CIRCUIT.
- 4 NEW HDMI PORT FROM MONITOR ABOVE.
- 5 PROVIDE AND INSTALL NEW POWER POLE WITH APPROPRIATE TRIMS FROM CEILING DOWN TO STORE FIXTURE. EXTEND NEW POWER CIRCUIT INDICATED FROM PANEL, DOWN TO STORE FIXTURE. PROVIDE ALL NECESSARY PARTS FOR COMPLETE POWER POLE INSTALLATION. FIELD VERIFY ELECTRICAL REQUIREMENTS AND ROUTING WITH OWNER PRIOR TO ORDERING MATERIALS.
- 6 RELOCATED EMPLOYEE LOUNGE. ELECTRICAL GEAR, DEVICES, ETC. LAYOUT OF RELOCATED EMPLOYEE LOUNGE SHALL MATCH EXISTING EMPLOYEE LOUNGE, UNLESS OTHERWISE NOTED. NO NEW POWER LOAD ADDED. PROVIDE NEW WIRING DEVICES TO MATCH EXISTING.
- 7 PROVIDE NEW DEVICES, BEHIND RELOCATED COOLERS AND FREEZERS, MATCHING EXISTING. EXTEND EXISTING CIRCUITS TO NEW LOCATIONS AS NEEDED.
- 8 EXISTING ATM TO BE RELOCATED HERE. PROVIDE ISOLATED GROUND SURGE PROTECTIVE QUAD RECEPTACLE, ORANGE, AS LEGRAND #G420H_SP OR EQUIVALENT, AND JUNCTION BOX WITH 3/4" EMPTY CONDUIT TO 6" ABOVE CEILING FOR ATM. PROVIDE LABEL ABOVE RECEPTACLE AND PANEL DEDICATED CIRCUIT BREAKER TO READ "FOR ATM USE ONLY". DO NOT CONNECT TO EMS.
- 9 PROVIDE DEDICATED: NEMA 5-20R RECEPTACLES FOR BEVERAGE COOLER, 3 WIRE AT 8" AFF. 20 AMP CIRCUIT BREAKER (EXISTING). WIRED DIRECTLY TO DISTRIBUTION PANEL. VERIFY EXACT LOCATION AND TYPE OF COOLER WITH TENANT SHEET F-1 PRIOR TO ROUGH-IN AND INSTALLATION.
- 10 EXISTING PHONE TO BE RELOCATED HERE.
- 11 REPLACED/RELOCATED ELECTRIC WATER COOLER.

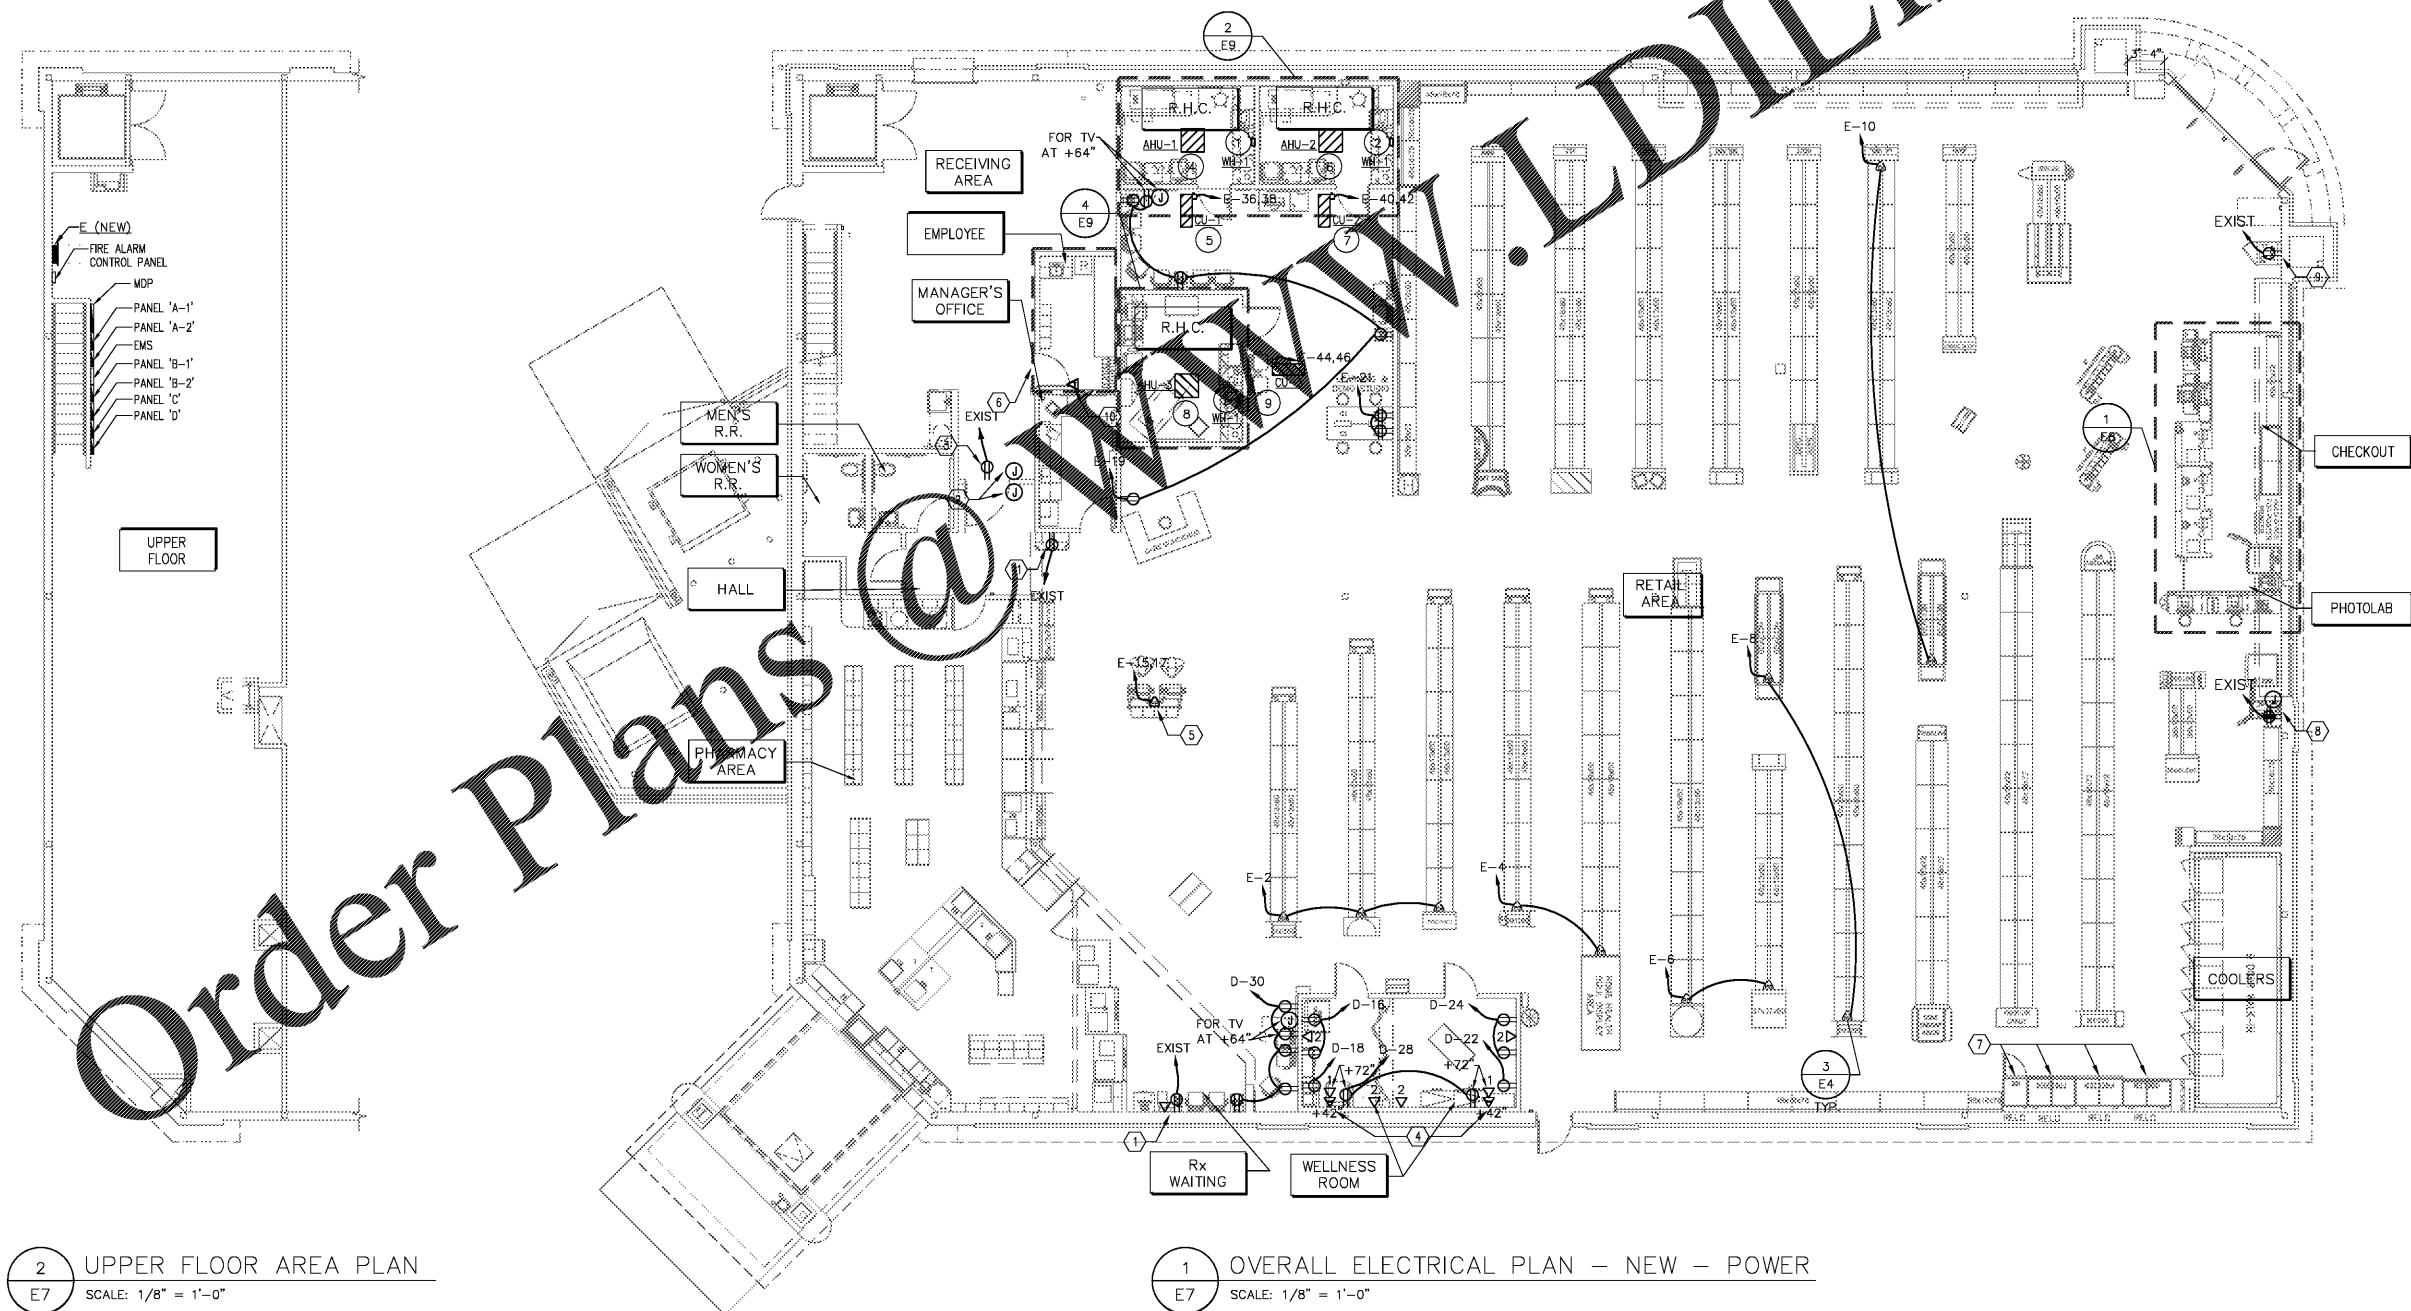

2 UPPER FLOOR AREA PLAN
 E7 SCALE: 1/8" = 1'-0"

1 OVERALL ELECTRICAL PLAN - NEW - POWER
 E7 SCALE: 1/8" = 1'-0"