


LAST SAVE: Apr/2/2019 4:05 PM

FILE Z:\Engineering\11MON01 PERRY COUNTY COMMUNITY SHELTERS\Drawings\PERRY COUNTY COMMUNITY SHELTER - MARION SHEETS\Electrical\E3.1 FIRE ALARM RISER AND DETAILS.dwg PLOTTED BY: JOHN TORBERT

Order Plans @ www.LDOnline.com

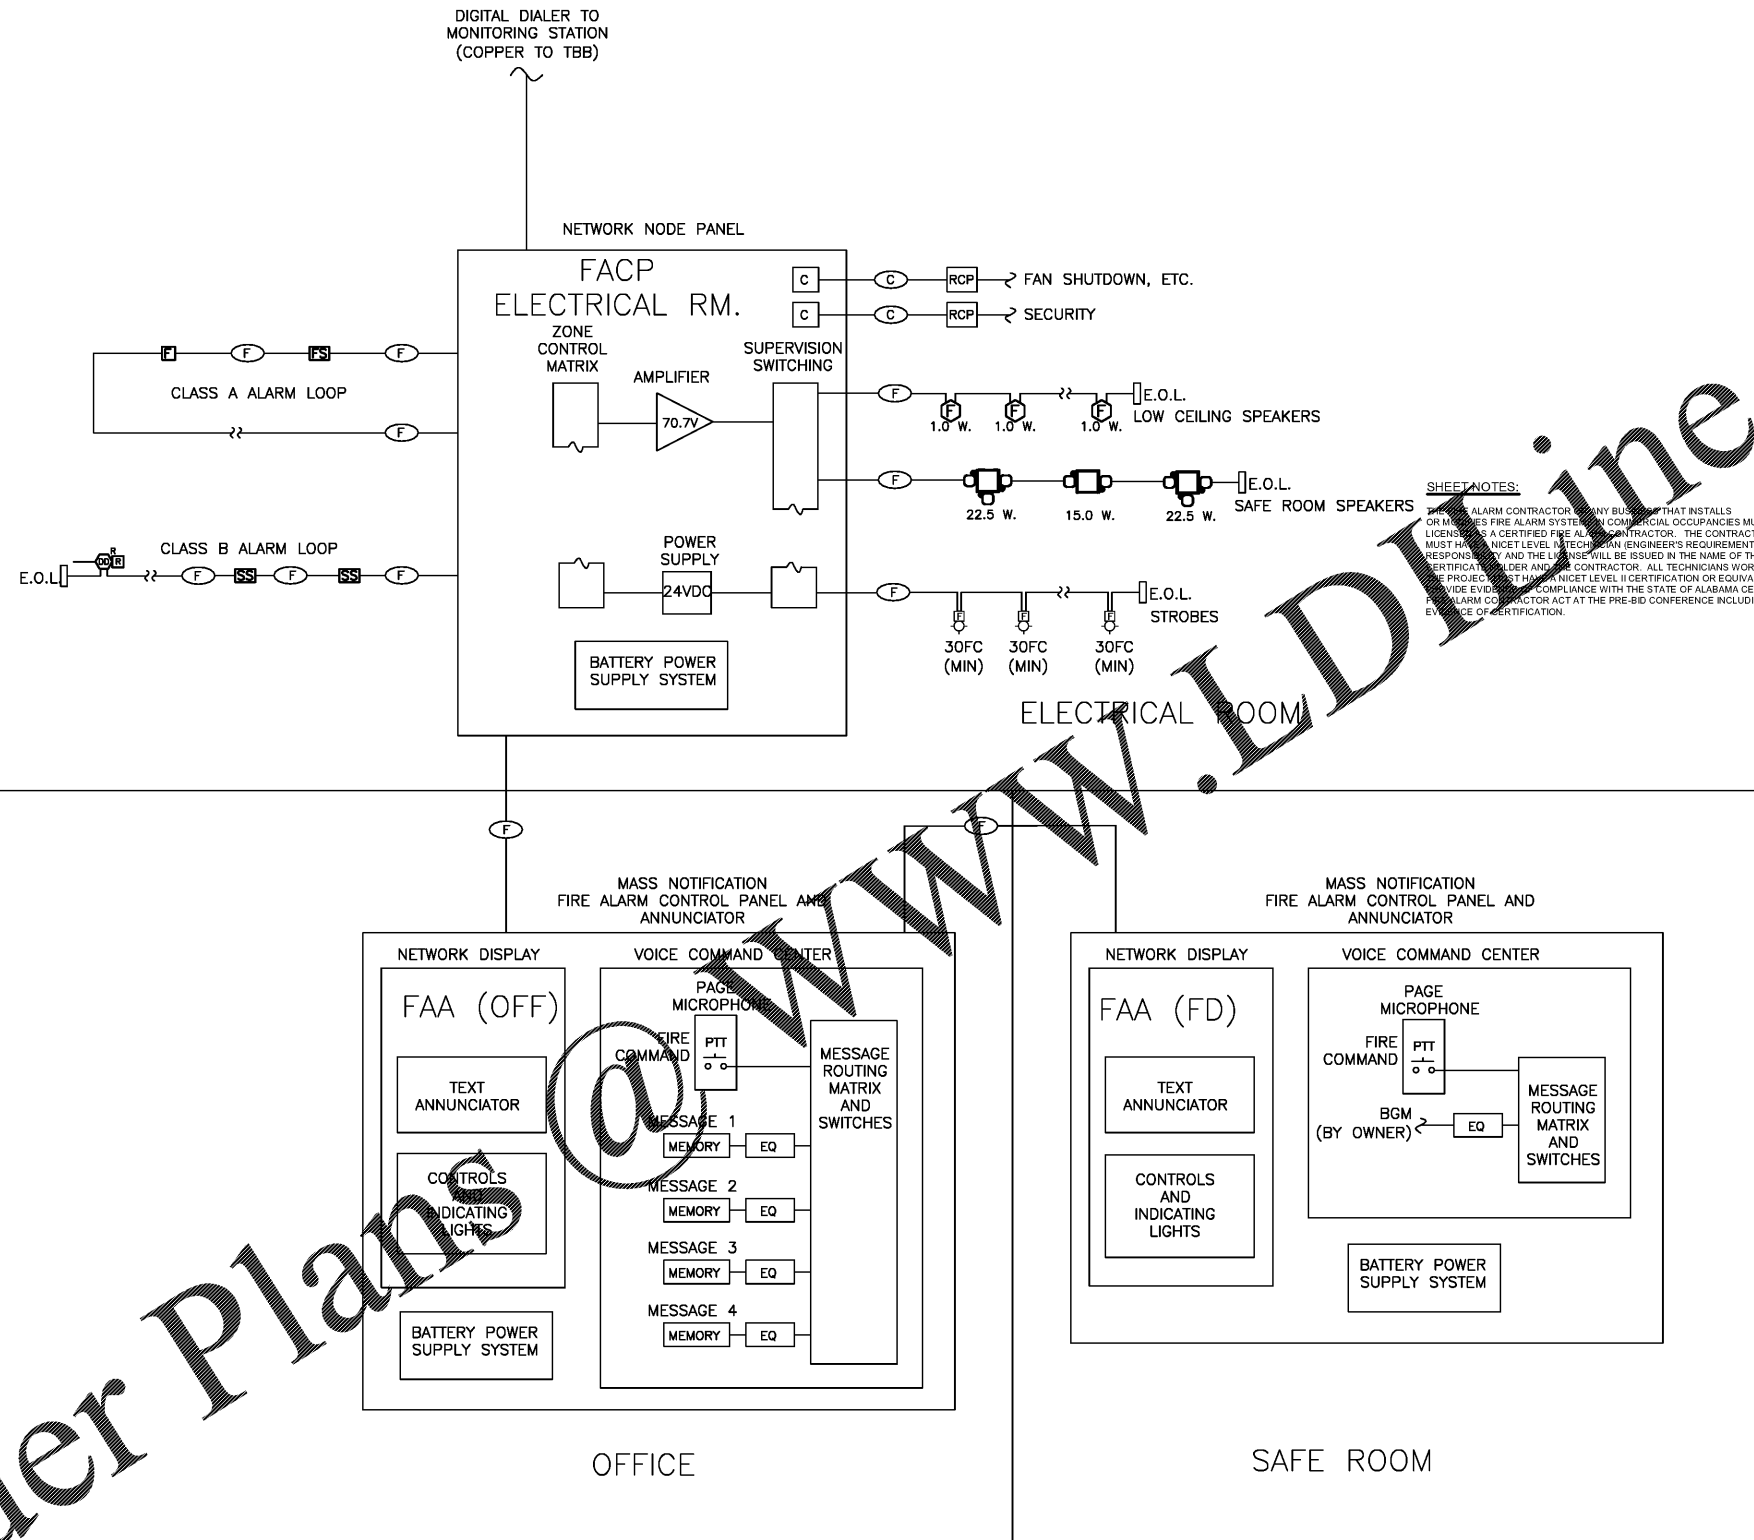


### MASS NOTIFICATION SINGLE LINE DIAGRAM

N.T.S.

THIS SET OF CONSTRUCTION DOCUMENTS ARE IN CONFORMITY WITH THE ICC/NSSA-500 2014 "STANDARD FOR THE DESIGN AND CONSTRUCTION OF STORM SHELTERS" REQUIREMENTS.

STRUCTURAL DRAWINGS ARE BASED ON ICC 500 "ICC/NSSA STANDAND FOR THE DESIGN AND CONSTRUCTION OF STORM SHELTERS." BASED ON THE "DESIGN WIND SPEED MAP FOR STORM SHELTERS," THE STRUCTURAL SYSTEMS FOR THE BUILDING WAS DESIGNED FOR ZONE IV (250 MILES PER HOUR) LOADS.

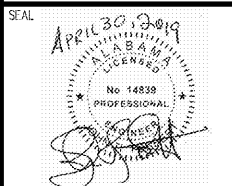

NO.	DATE	REVISION	REVISION
1	04-25-2018	REVISED FINAL	ROSS
2	06-13-2018	ABC'S COMMENTS AND REPLY	ROSS
3	04-08-2019	SECOND REVISION	ROSS

REUSE OF DOCUMENTS  
THIS DOCUMENT WITH THE IDEAS AND DESIGNS INCORPORATED HEREIN ARE AN INSTRUMENT OF SERVICE AND MUST NOT BE USED IN WHOLE OR IN PART FOR ANY OTHER PROJECT WITHOUT THE WRITTEN AUTHORIZATION OF KAFRA

PROJECT: COMMUNITY STORM SHELTER  
B.C. NO. 2014346  
FOR THE PERRY COUNTY COMMISSION  
300 Washington Street, Marietta, Alabama 35756  
Perry County, Alabama 35756

DATE	APRIL 30, 2019
DRWN. BY	JRTT
DSGN. BY	JRTT
CHKD. BY	JRTT
APVD. BY	JRTT
SCALE	NONE

SHEET TITLE: MARION STORM SHELTER FIRE ALARM RISER AND DETAILS

PROJECT No. 11MON01  
DRAWING No. E3.1  
B.C. Project No. 2014346

CONSTRUCTION DOCUMENTS