



Contractor

**EDGAR'S ABOVE BROAD + LANDLORD BUILDOUT**  
 699 BROAD ST.  
 AUGUSTA, GEORGIA 30901

Project Number  
**1817**

Revisions

Number	Date	Description
<DATE OF ISSUE>		RELEASE FOR

Drawing Title  
**THIRD FLOOR REFLECTED CEILING PLAN**

Drawing Status  
**ISSUED FOR CONSTRUCTION**

Drawing Number  
**A2.5**

SYMBOLS LEGEND	
	2x4 FLUORESCENT FIXTURE
	DIAGONAL LINE INDICATES EMERGENCY SHACK UP FIXTURE
	FLUORESCENT FIXTURE
	EXIT LIGHT
	EMERGENCY LIGHT
	EMERGENCY LIGHT
	EMERGENCY LIGHT
	RECESSED DOWNLIGHT
	CEILING MOUNTED
	ADJUSTABLE DOWNLIGHT
	WALL SCONCE
	PENDANT
	JUNCTION BOX
	TABLE LAMP
	TABLE LAMP
	TABLE LAMP
	SURFACE MOUNTED FAN
	TV
	SPACE HEATER
	SIDE AIR DIFFUSER
	AIR DIFFUSER

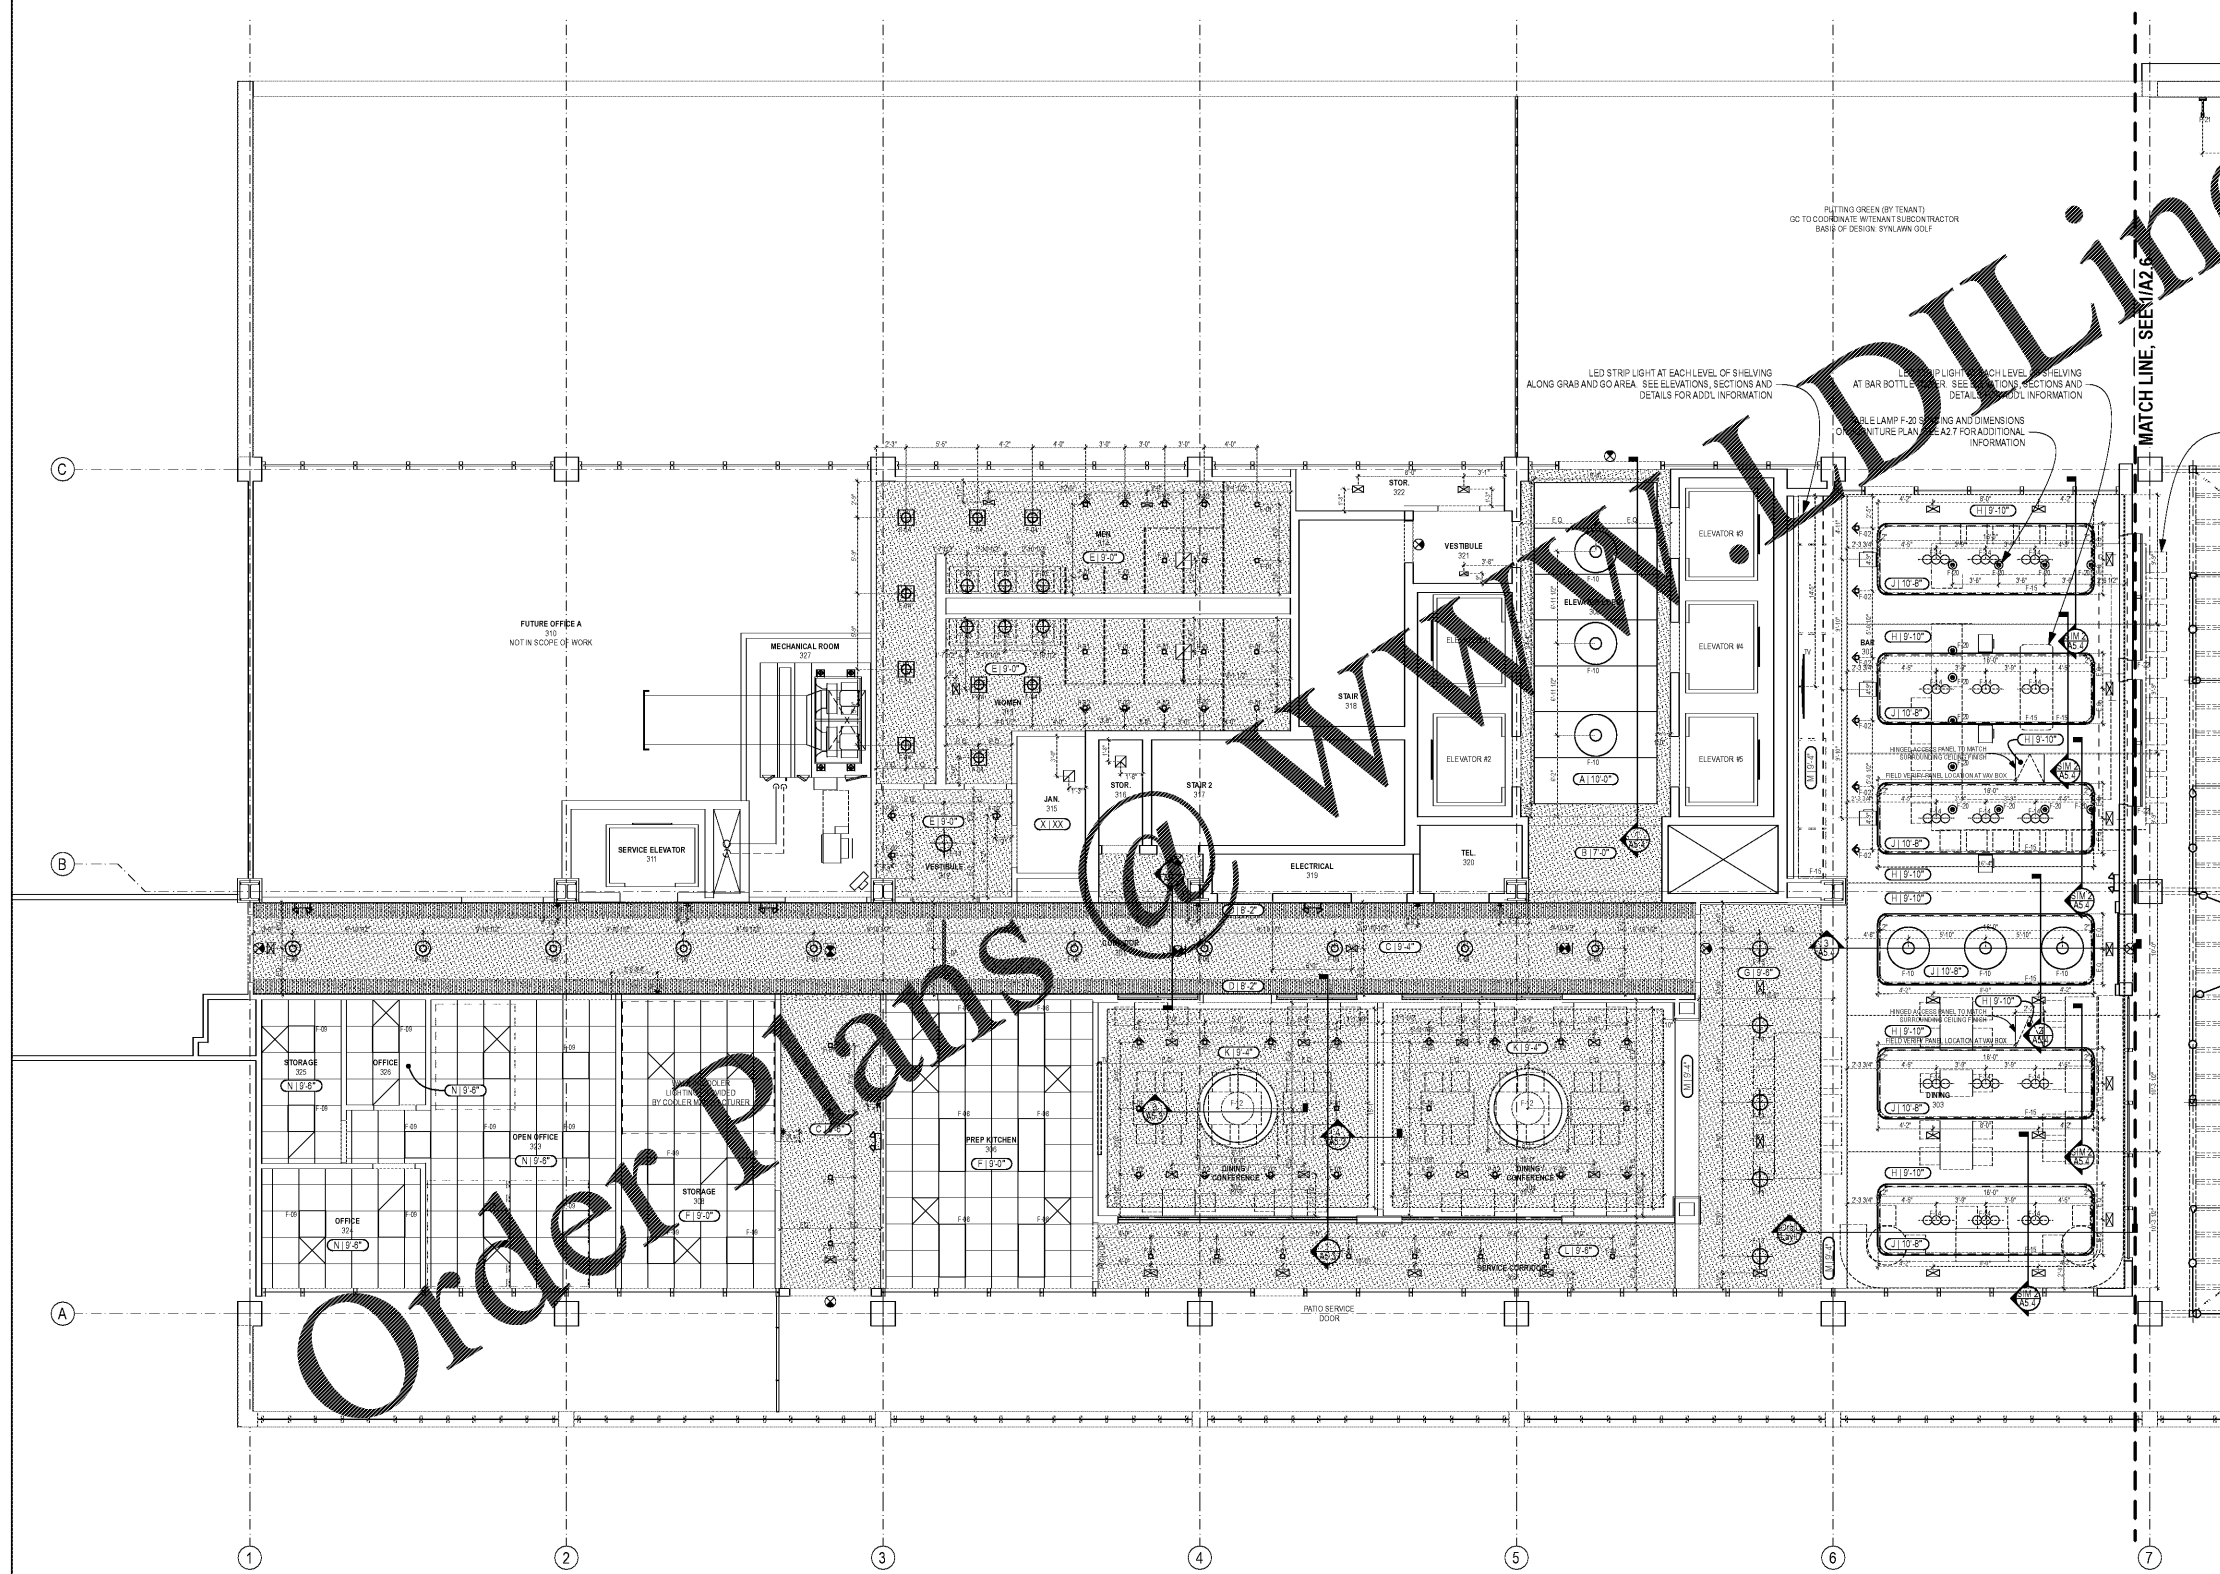
NOTES	
1.	REFER TO FINISH SCHEDULE FOR ADDITIONAL INFORMATION
2.	DIMENSIONS ARE TO CENTERLINE OF LIGHT LUMEN
3.	CONTRACTOR TO PROVIDE ELECTRICAL AND COORDINATE INSTALLATION OF PROMISED LIGHT FIXTURES
4.	ALL FRONT OF HOUSE FIXTURES TO BE DIMMED AS SCHEDULED
5.	CEILING STRUCTURE DECK PAINTED AS SCHEDULED
6.	ALL EXPOSED DUCTWORK TO BE EXPOSED METAL COLOR AND DIFFUSERS TO MATCH
7.	ALL FIXTURES TO HAVE FUNCTIONING LAMPS
8.	REFERENCE 037 FOR LIGHT FIXTURE SCHEDULE

CEILING LEGEND	
NOTE: REFERENCE FINISH SCHEDULE FOR ADDITIONAL INFORMATION SHEET 031 AND CEILING DETAILS	
CEILING TYPE	NOTE: HEIGHTS INDICATED ARE FROM FINISH FLOOR @ ENTRY UNLESS NOTED OTHERWISE. EXISTING CEILING HEIGHTS TO REMAIN THE SAME. CEILING HEIGHT INDICATED FOR REFERENCE ONLY.
HEIGHT	
EXAMPLE: C19'-0"	

A	LOCATION: ELEVATOR LOBBY WOOD SUSPENDED CEILING WD-01
B	LOCATION: ELEVATOR LOBBY GYP. WITH DISTRESSED MIRROR APPLIED SPL-01
C	LOCATION: COMMON CORRIDOR PAINTED GYP. TYPE X GYP BOARD PT-01
D	LOCATION: COMMON CORRIDOR WOOD SOFFIT WD-01
E	LOCATION: RESTROOM VESTIBULE & RESTROOMS PAINTED GYP. TYPE X GYP BOARD IN RESTROOM VESTIBULE, PT-02
F	LOCATION: STORAGE & PREP KITCHEN USG APPROVED LAY IN CEILING TILE ACT-01
G	LOCATION: ENTRY VESTIBULE AT EDGAR'S PAINTED GYP. PT-01
H	LOCATION: BAR & DINING ROOM WOOD SOFFIT WD-01
J	LOCATION: BAR AND DINING ROOM ACCENTRAL PANEL UP-01
K	LOCATION: CONFERENCE ROOMS SUSPENDED GYP. PT-04
L	LOCATION: SERVICE CORRIDOR PAINTED GYP. PT-05
M	LOCATION: DINING ROOM AND BAR WOOD SOFFIT WD-01
N	LOCATION: OFFICES ACCENTRAL CEILING TILE ACT-02



**1 3RD FLOOR REFLECTED CEILING PLAN**  
 SCALE: 3/16" = 1'-0"

Order Plans @