


Order Plans @ www.LDILine.com

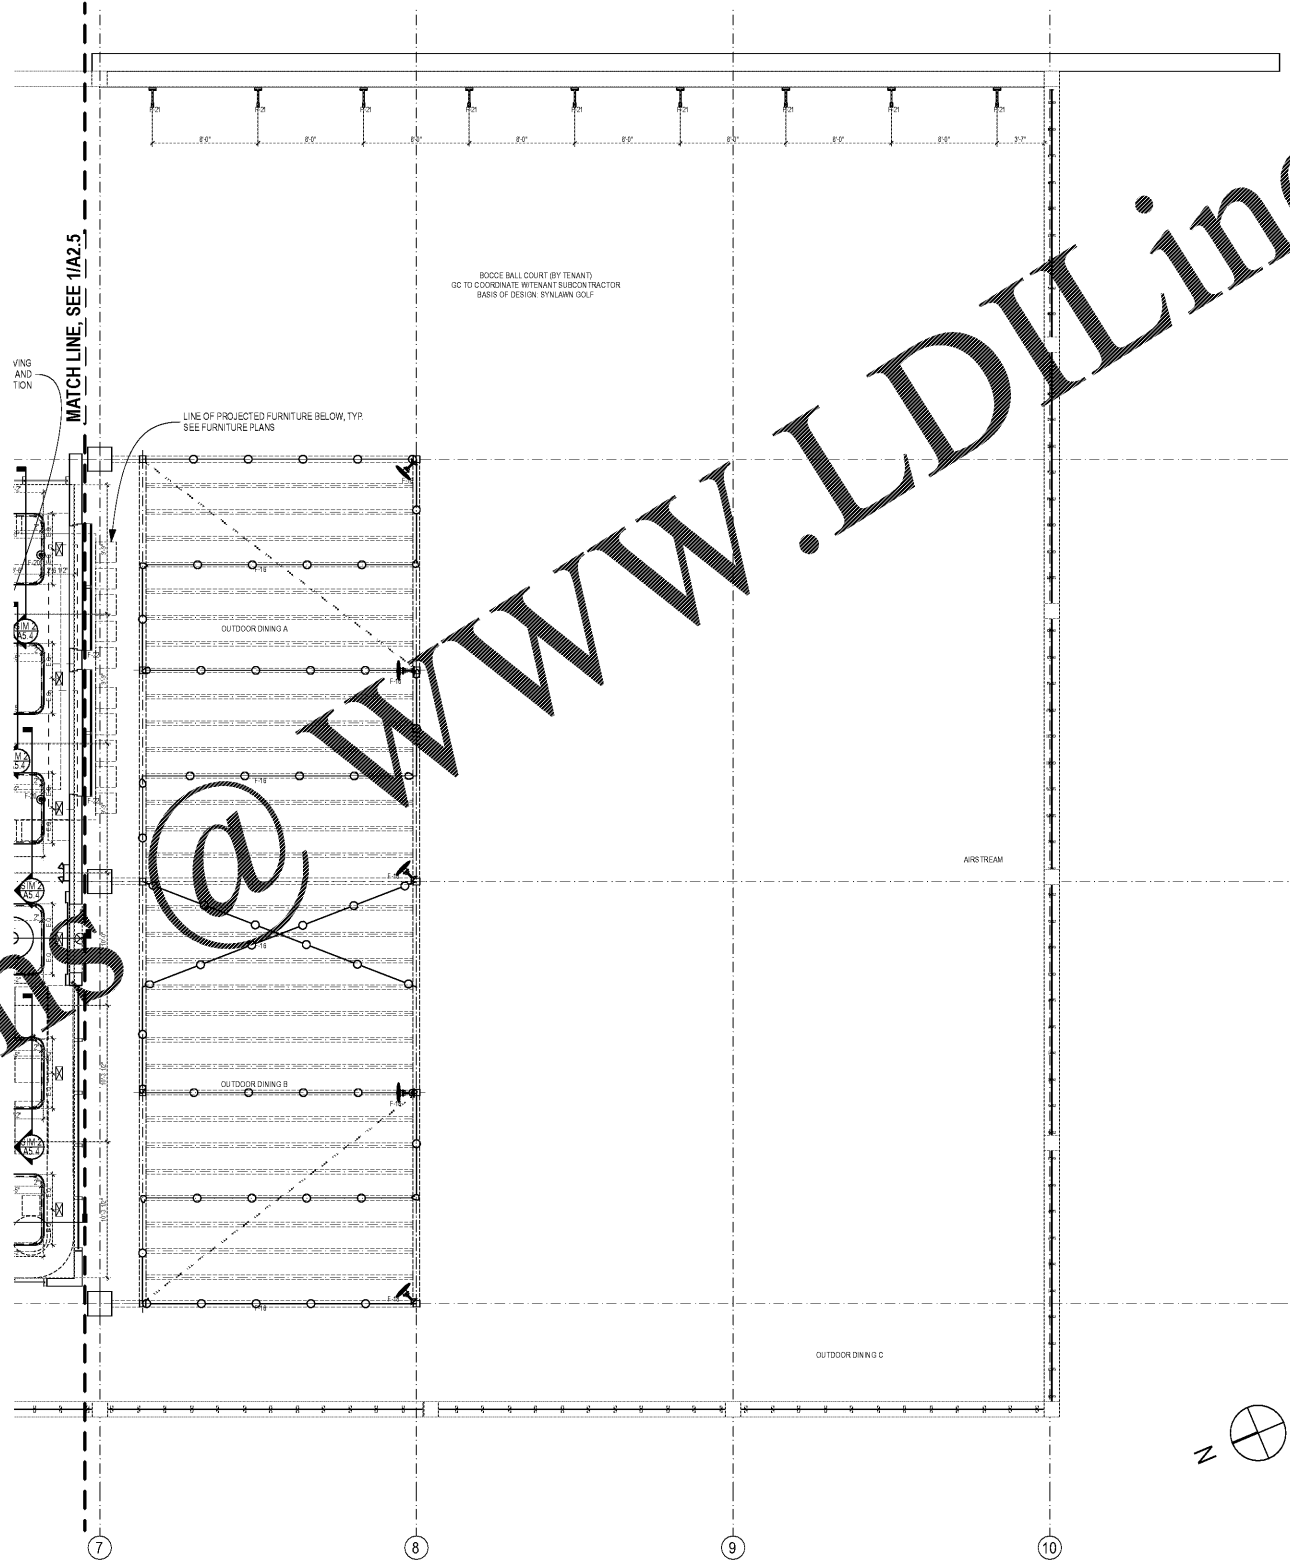

SYMBOLS LEGEND

- 2x4 FLUORESCENT FIXTURE
- DIAGONAL LINE INDICATES EMERGENCY BACK-UP FIXTURE
- FLUORESCENT FIXTURE
- EXIT LIGHT
- EMERGENCY LIGHT
- EXTREMELY LIGHT
- RECESSED DOWNLIGHT
- CEILING MOUNTED
- ADJUSTABLE DOWNLIGHT
- WALL SCENE
- PENDANT
- TABLE LAMP
- TABLE LIGHTING
- SURFACE MOUNTED FAN
- TV
- SPACE HEATER
- SIDE AIR DIFFUSER
- AIR DIFFUSER

NOTES

- REFER TO FINISH SCHEDULE FOR ADDITIONAL INFORMATION
- DIMENSIONS ARE TO CENTERLINE OF LIGHT UNLESS NOTED OTHERWISE
- CONTRACTOR TO PROVIDE ELECTRICAL AND COORDINATE INSTALLATION OF PROMINENT LIGHT FIXTURES
- ALL FRONT OF HOUSE FIXTURES TO BE DIMMED AS SCHEDULED
- CEILING STRUCTURE DECK PAINTED AS SCHEDULED
- ALL EXPOSED DUCTWORK TO BE EXPOSED METAL COLOR AND DIFFUSERS TO MATCH
- ALL FIXTURES TO HAVE FUNCTIONING LAMPS
- REFERENCE 012 FOR LIGHT FIXTURE SCHEDULE

CEILING LEGEND

NOTE: REFERENCE FINISH SCHEDULE FOR ADDITIONAL INFORMATION SHEET 011 AND CEILING DETAILS

CEILING TYPE: HEIGHT

NOTE: HEIGHTS INDICATED ARE FROM FINISH FLOOR @ ENTRY UNLESS NOTED OTHERWISE. EXISTING CEILING HEIGHTS TO REMAIN THE SAME. CEILING HEIGHT INDICATED FOR REFERENCE ONLY.

EXAMPLE: C 19'-0"

A	LOCATION: ELEVATOR LOBBY WOOD SUSPENDED CEILING WD-01
B	LOCATION: ELEVATOR LOBBY GYP. WITH DISTRESSED MIRROR APPLIED SPL-01
C	LOCATION: COMMON CORRIDOR PAINTED GYP. TYPE X GYP BOARD PT-01
D	LOCATION: COMMON CORRIDOR WOOD SOFFIT WD-01
E	LOCATION: RESTROOM VESTIBULE & RESTROOMS PAINTED GYP. TYPE X GYP BOARD IN RESTROOM VESTIBULE, PT-02
F	LOCATION: STORAGE & PREP KITCHEN USG APPROVED LAY IN CEILING TILE ACT-01
G	LOCATION: ENTRY VESTIBULE AT EDWARDS PAINTED GYP. PT-03
H	LOCATION: BAR & DINING ROOM WOOD SOFFIT WD-01
J	LOCATION: BAR AND DINING ROOM ACQUISITION PANEL UP-01
K	LOCATION: CONFERENCE ROOMS SUSPENDED GYP. PT-04
L	LOCATION: SERVICE CORRIDOR PAINTED GYP. PT-05
M	LOCATION: DINING ROOM AND BAR WOOD SOFFIT WD-01
N	LOCATION: OFFICES ACQUISITION CEILING TILE ACT-02

seiberdesign

675 Drewry St. NE
Studio 10
Atlanta GA 30308
404.875.9785
www.seiberdesign.com

8/30/19

EDGAR'S ABOVE BROAD + LANDLORD BUILDOUT
699 BROAD ST.
AUGUSTA, GEORGIA 30901

Project Number
1817

Revision History

Number	Date	Description
<DATE OF ISSUE>		RELEASE FOR

Drawing Title
THIRD FLOOR REFLECTED CEILING PLAN

Drawing Status
ISSUED FOR CONSTRUCTION

Drawing Number
A2.6

1 3RD FLOOR REFLECTED CEILING PLAN
SCALE 3/16" = 1'-0"