




Consultant
WESTSIDE
5525 Interstate North Pkwy
Suite 200
Atlanta, GA 30328
404-965-1287 tel
404-601-9859 fax
westside@westside-engineering.com

**EDGAR'S ABOVE BROAD
699 BROAD ST.
AUGUSTA, GEORGIA 30901**

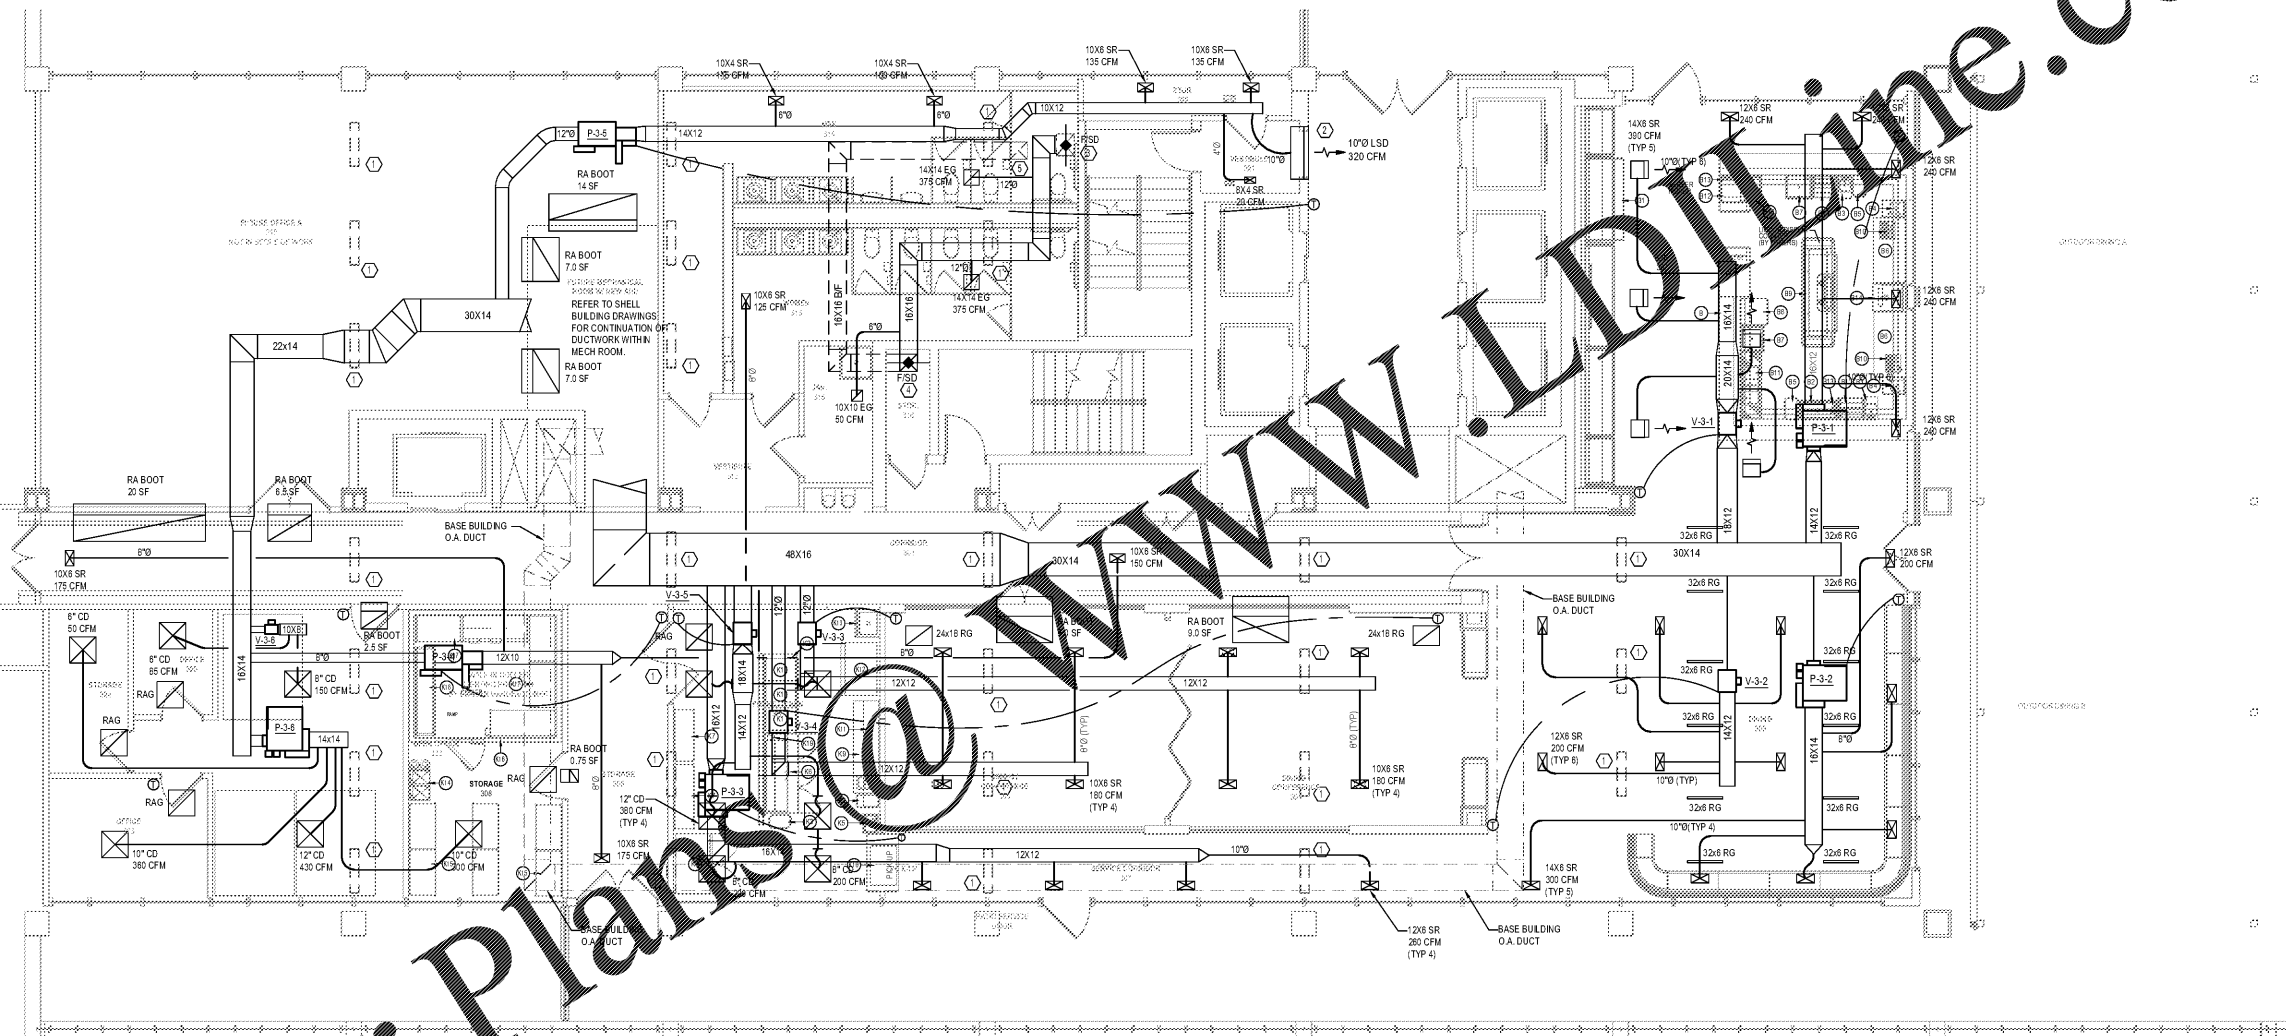

Order Plans @ www.LDOnline.com

1 MECHANICAL PLAN
SCALE: 3/16" = 1'-0"

- KEY NOTES:**
- EXISTING OPENING IN STEEL BEAM TO REMAIN. ROUTE DUCTWORK & CONTROL WIRING THROUGH EXISTING OPENING.
 - 4' LONG, WALL MOUNTED LINEAR SLOT DIFFUSER BELOW ELEVATOR LOBBY CEILING WITH TWO (2) 1" SLOTS.
 - PROVIDE NEW F/SD IN EXISTING EXHAUST DUCT PENETRATION THROUGH FLOOR ABOVE. CONNECT NEW EXHAUST DUCT TO NEW F/SD.
 - ROUTE EXHAUST DOWN THROUGH FLOOR WITH F/SD AT FLOOR PENETRATION.
 - CONNECT NEW EXHAUST DUCT TO EXISTING EXHAUST DUCT BELOW FLOOR.

Project Number
1817

Revisions

Revision History	Number	Date	Description
	08/30/19		ISSUED FOR CONSTRUCTION

Drawing Title
MECHANICAL PLAN

Drawing Status
ISSUED FOR CONSTRUCTION

Drawing Number