


Seal



Consultant

W 5525 Interstate North Pkwy
Suite 200
Atlanta, GA 30328
404-965-1287 tel
404-601-9859 fax
www.westsideengineering.com

**EDGAR'S ABOVE BROAD
699 BROAD ST.
AUGUSTA, GEORGIA 30901**

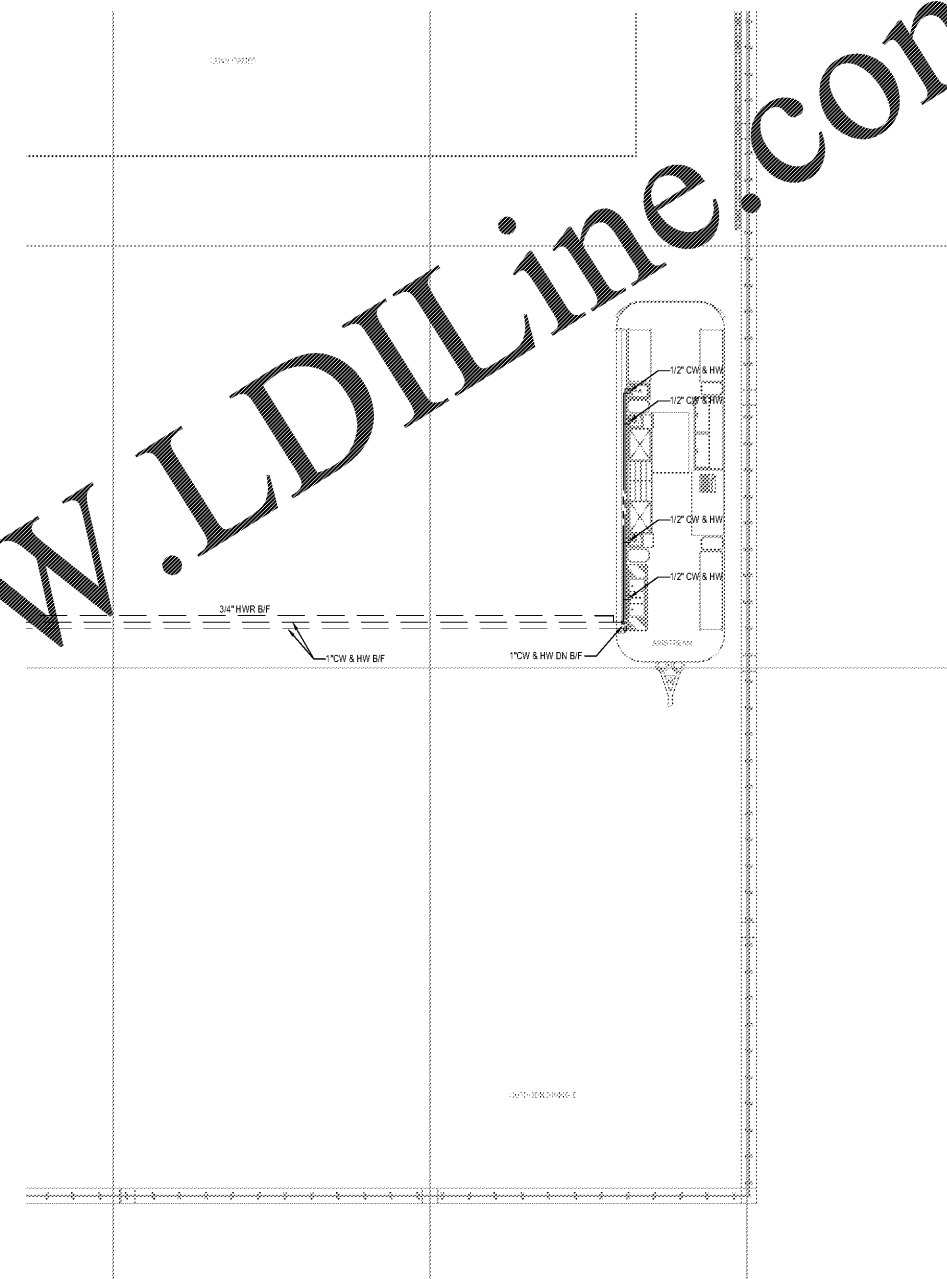

Order Plans @ WWW.LDILine.com

1 PLUMBING PLAN - WATER
P202 SCALE: 3/16" = 1'-0"

Project Number		
1817		
Revisions		
Revision History		
Number	Date	Description
	08/30/19	ISSUED FOR CONSTRUCTION
△		
△		
△		
△		
△		
Drawing Title		
PLUMBING PLAN - SAN & VENT		
Drawing Status		
ISSUED FOR CONSTRUCTION		
Drawing Number		