


Order Plans @

WWW.DILine.com

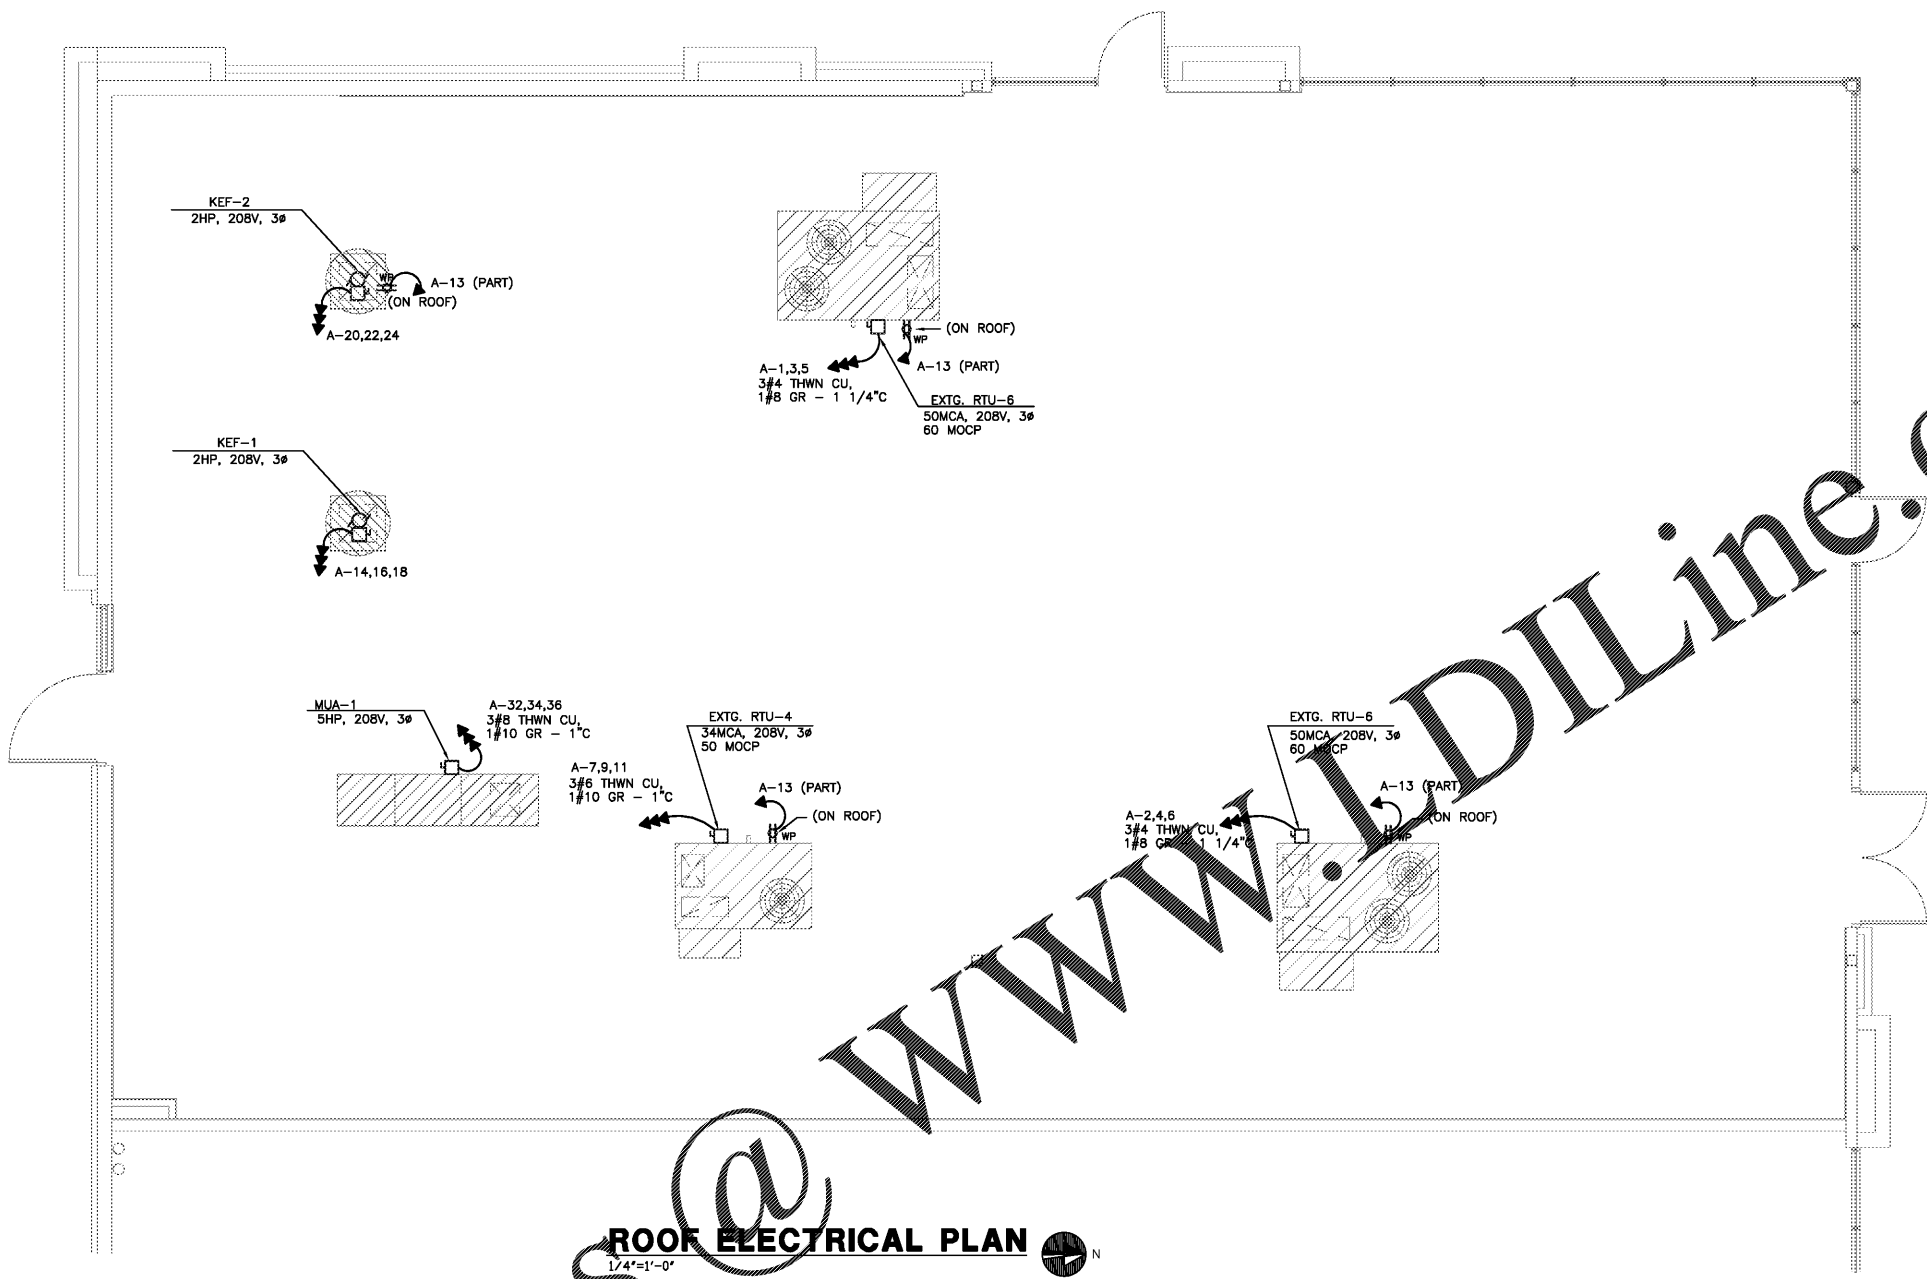


**ROOF ELECTRICAL PLAN**  
1/4"=1'-0" N

CONSULTANT:

**WALTER RABINOVICH, PE**  
ELECTRICAL ENGINEER  
8811 E. HAMPTON AVE., SUITE 200, DENVER, CO 80231  
(303) 355-5534 (cell) wabe@qecinc.com



08.28.2019

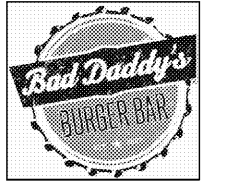

GOOD TIMES RESTAURANTS, INC.  
141 Union Blvd, Suite 400  
Lakewood, CO 80226  
303-384-1430

BAD DADDY'S BURGER BAR  
"SANDY PLAINS"  
3460 SANDY PLAINS RD N.E.  
SUITE 110  
MARIETTA, GA 30062

Issue Record:

6.7.2019	FOR PLAN REVIEW

Revisions:

08.28.2019	QCR

Drawn:  
DRAWN BY: VR

Checked:  
CHECKED BY: WR

Project No.  
PROJECT#: 19-213

Contract:  
ROOF ELECTRICAL PLAN

E3.0

Date of Last Print: 08.28.2019

OF 7