



**1 FLOOR PLAN - POWER**  
E-3 SCALE: 1/4" = 1'-0"

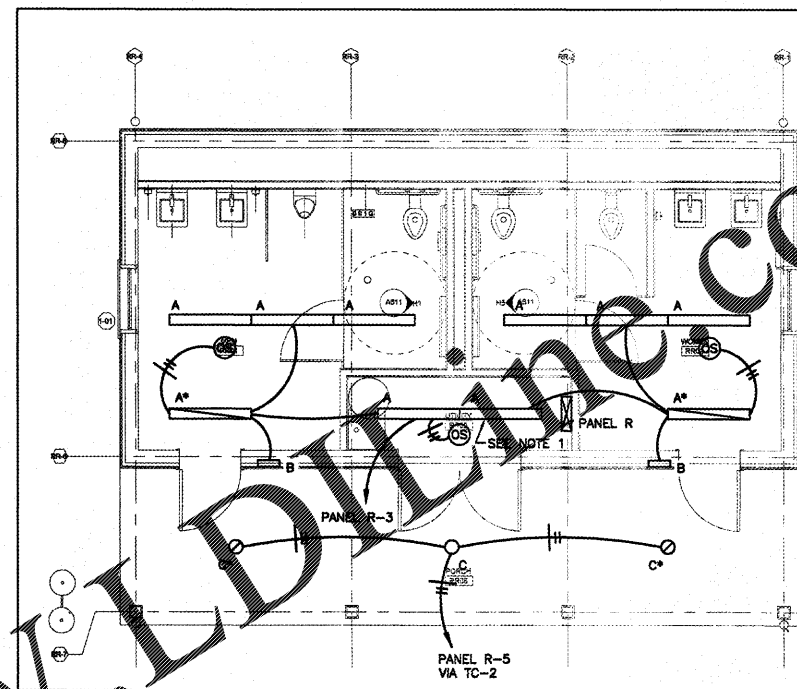

**2 FLOOR PLAN - LIGHTING**  
E-3 SCALE: 1/4" = 1'-0"

**WIRING SCHEDULE**


- ① 2#10 + 1#10G IN 1/2" C
  - ② 2#8 + 1#10G IN 3/4" C
- ALL CONDUCTORS ARE TO BE COPPER

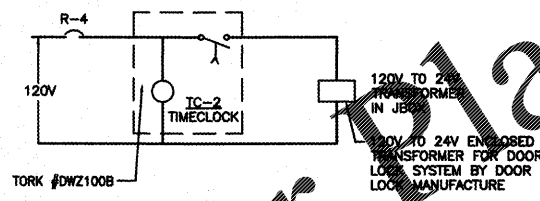

**3 CONTROL SCHEMATIC**  
E-3 SCALE: NTS

**NOTES**

- 1. RUN UNSWITCHED HOT CONDUCTOR THRU FIXTURE TYPE A FOR WOMEN'S RESTROOM LIGHTING.

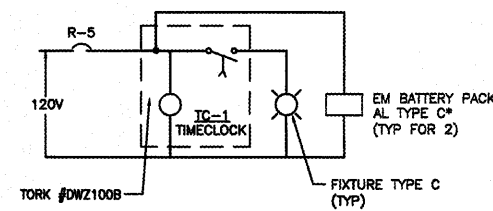

**4 CONTROL SCHEMATIC**  
E-3 SCALE: NTS

ENGINEER:  
**FORESITE group**  
Foresite Group, Inc. | www.fg-inc.net  
3740 Davinci Ct. | 770.368.1399  
Suite 100 | 770.368.1944  
Peachtree Corners, GA 30092

DEVELOPER:  
**GWINNETT COUNTY - GEORGIA**  
ESTABLISHED 1982  
75 LANGLEY DR.  
LAWRENCEVILLE, GEORGIA 30046  
770-822-8884  
CONTACT: MR. REX SCHUDER

PROJECT:  
**ELISHA WINN HOUSE**  
SITE IMPROVEMENTS  
908 DACULA RD  
DACULA GA, 30019  
PARCEL #R2001 158

SEAL:  
**GEORGIA**  
REGISTERED PROFESSIONAL ELECTRICAL ENGINEER  
WOMACK & ASSOCIATES  
WILLIAM B. M. WOMACK  
02.12.2019

REVISIONS	DATE

PROJECT MANAGER: ###  
DRAWING BY: CPP  
JURISDICTION: GWINNETT COUNTY  
DATE: 02/12/2019  
SCALE: AS SHOWN  
TITLE:

FLOOR PLAN - POWER / LIGHTING  
SHEET NUMBER: **E-3**  
COMMENTS: ###  
JOBFILE NUMBER: 223.082

W&A PROJECT NUMBER - 18040  
**WOMACK & ASSOCIATES**  
2300 Lake Park Dr, Suite 250  
Suwanee, Georgia 30080  
Voice: 770-458-3905 Fax: 770-458-8388  
WOMACK & ASSOCIATES  
COA #PEF06530 EXP - 06/30/2020  
PLOT SCALE: 1-1

**GEORGIA 811**  
Utilities Protection Center, Inc.  
Know what's below.  
Call before you dig.