



**1 OVERALL SITE PLAN - POWER**  
E-5 SCALE: 1" = 30'-0"

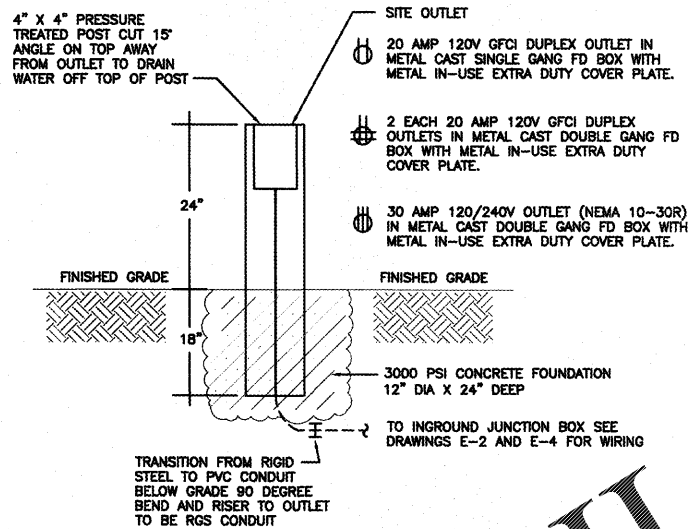

**3 SITE OUTLET MOUNTING DETAIL**  
E-5 SCALE: NTS

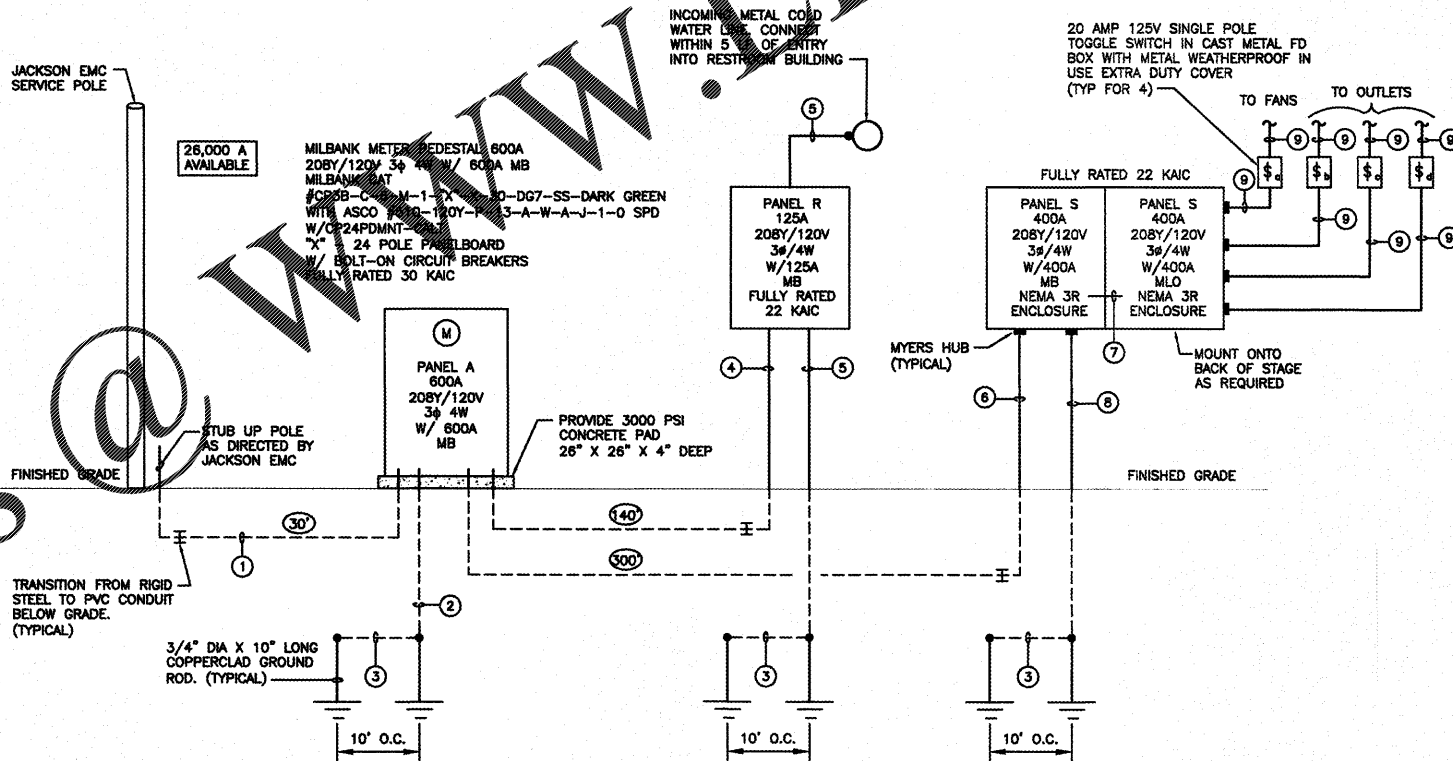

**2 POWER RISER DIAGRAM**  
E-5 SCALE: NTS

**WIRING SCHEDULE**


- ① 2 RUNS - 4 - 350 KCMIL IN 3 1/2" C (EA)
- ② 1#2/0 IN 1" PVC C
- ③ #6
- ④ 4#1/0 + 1#4G IN 2" C
- ⑤ 1#6 IN 3/4" PVC C
- ⑥ 2 RUNS - 4 - 500 KCMIL + 1#1/0G IN 3 1/2" C (EA)
- ⑦ 4 - 800 KCMIL + 1#3/5 IN 4" NEMO
- ⑧ 1#1/0 IN 1" PVC C
- ⑨ 2#12 + 1#1 IN 3/4" RGS C

ALL CONDUCTORS ARE TO BE COPPER


Order Plans

www.dilling.com

**ENGINEER:**  
**FORESITE group**  
Foresite Group, Inc. w | www.fg-inc.net  
3740 Davinci Ct. o | 770.368.1399  
Suite 100 f | 770.368.1944  
Peachtree Corners, GA 30092

**DEVELOPER:**  
  
75 LANGLEY DR.  
LAWRENCEVILLE, GEORGIA 30046  
770-822-8884  
**CONTACT:** MR. REX SCHUDER


**PROJECT:**  
**ELISHA WINN HOUSE**  
SITE IMPROVEMENTS  
908 DACULA RD  
DACULA GA, 30019  
PARCEL #R2001158

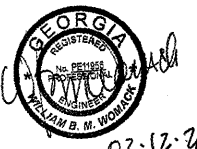
**SEAL:**  
  
02-12-2019

REVISIONS	DATE

PROJECT MANAGER: ##  
DRAWING BY: CPP  
JURISDICTION: GWINNETT COUNTY  
DATE: 02/12/2019  
SCALE: AS SHOWN  
TITLE:

**OVERALL SITE PLAN - POWER**  
SHEET NUMBER: **E-5**  
COMMENTS: ##  
JOB/FILE NUMBER: 223.082

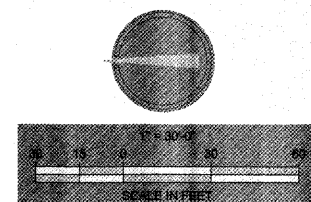

W&A PROJECT NUMBER - 18040  
  
2300 Lake Park Dr, Suite 250  
Suwanee, Georgia 30080  
Voice: 770-458-3095 Fax: 770-458-8388  
WOMACK & ASSOCIATES  
COA #FE006530 EXP - 06/30/2020  
PLOT SCALE: 1" = 1'