

PHILLIPS

KEYPLAN

CONSULTANT



**PROFICIENT  
ENGINEERING**  
6991 Peachtree Industrial Blvd Building 700  
Peachtree Corners, Georgia 30092  
404.330.9750  
PROJECT # 119288

SEAL



ISSUE & REVISION RECORD

#	DATE	DESCRIPTION
1	06.10.2019	30% DESIGN REVIEW SET
2	08.15.2019	90% REVIEW SET
3	08.23.2019	PERMIT SET

This document is ©Phillips Partnership, PC and is considered an Instrument of Service and is solely for use with respect to the project as indicated herein. All rights reserved. This document may not be reproduced without the prior written consent of Phillips Partnership, PC.

PROJECT

**Fairfield  
BY MARRIOTT  
INN & SUITES**

DAWSONVILLE, GEORGIA

PROTOTYPE VERSION 2016  
REV 7.12.21-18

4 STORY, 92 UNITS  
w/ INDOOR POOL

**FAIRFIELD  
DAWSON FOREST ROAD  
DAWSONVILLE, GA  
30534**

CLIENT

**RIMROCK COMPANIES**  
10000 RIVERSIDE AVE  
SUITE 32201  
JACKSONVILLE, FL 32204

PHILLIPS JOB NUMBER 1972101

ISSUE DATE 08/23/2019

DRAWN BY/CHECKED BY AT/RK

DRAWING TITLE

FLOOR PLAN LEVEL 3 -  
LIGHTING


SHEET NUMBER

**E-2.3**

5901 PEACHTREE DUNWOODY RD.  
BUILDING A, SUITE 450  
ATLANTA, GEORGIA 30328  
PHILLIPSPART.COM 770-394-1816

GENERAL NOTES

REFER TO ARCHITECTURAL REFLECTED CEILING PLAN FOR EXACT LOCATION OF CEILING MOUNTED DEVICES.  
PROVIDE UNSWITCHED HOT LEG OF CIRCUIT TO EMERGENCY LIGHTS AND EXIT SIGNS.  
REFER TO ENGAGED PLANS FOR ADDITIONAL RESTROOM INFORMATION.

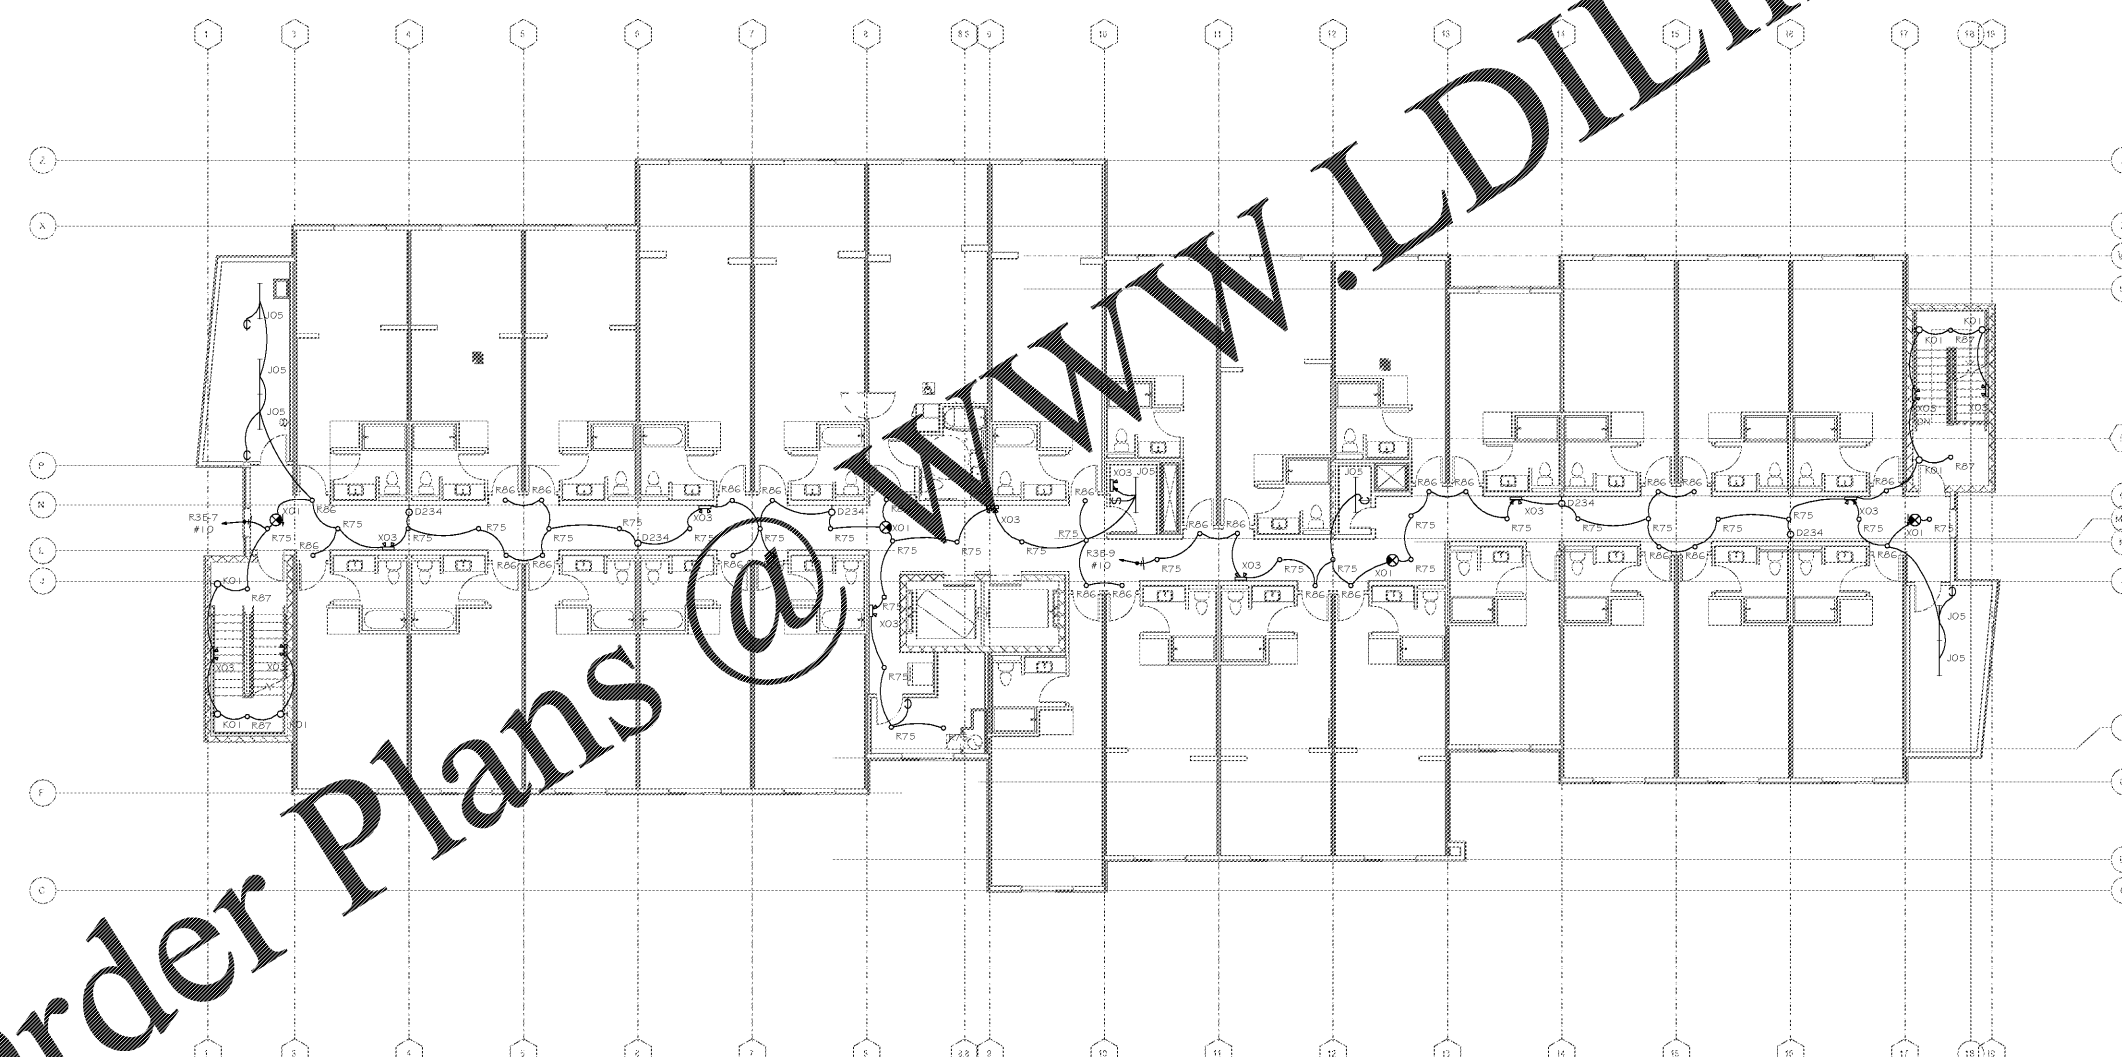

Order Plans @ WWW.LDILine.com

1 FLOOR PLAN - LEVEL 3 - LIGHTING  
E-2.3 1/8" = 1'-0"