



NEW CORPORATE HANGAR
 4005 AIRPORT ROAD
 SOUTHPORT, NC 28461



PO Box 5510 Charlotte, NC 28299
 704-331-9747 • www.twgarchitects.com

PROJECT MANAGER / CIVIL ENGINEER
TALBERT & BRIGHT

4810 SHELLEY DRIVE
 WILMINGTON, NC 28405
 (910) 763-5350
 FIRM NO.: C-0713

STRUCTURAL ENGINEER
STEWART

101 N. TRYON ST. SUITE 1400
 CHARLOTTE, NC 28202
 (704) 254-7925
 FIRM NO.: C-1051

FIRE PROTECTION, PLUMBING, MECHANICAL,
 & ELECTRICAL ENGINEER
SABER ENGINEERING

2923 S. TRYON ST. #200
 CHARLOTTE, NC 28203
 (704) 373-0068

WATER & SEWER ENGINEER
McGILL ASSOCIATES

712 S. VILLAGE ROAD SW, SUITE 103
 SHALLOTTE, NC 28470
 (910) 765-5072

COPYRIGHT © 2019
 THE WILSON GROUP ARCHITECTS
 ALL RIGHTS RESERVED
 PRINTED OR ELECTRONIC DRAWINGS AND
 DOCUMENTATION MAY NOT BE REPRODUCED
 IN ANY FORM WITHOUT WRITTEN PERMISSION
 FROM THE WILSON GROUP ARCHITECTS

REVISIONS

DATE 8/2/2019
 PROJECT NUMBER 9217-000

SHEET TITLE
FIRST LEVEL FLOOR PLAN


SHEET NUMBER
A-101

LEGEND

	2 HOUR FIRE RATED WALL
	1 HOUR FIRE RATED BARRIER

SF SUMMARY

HANGAR	9900 SF
OFFICE	273 SF
TLT	116 SF
ELEC	45 SF
	10334 SF

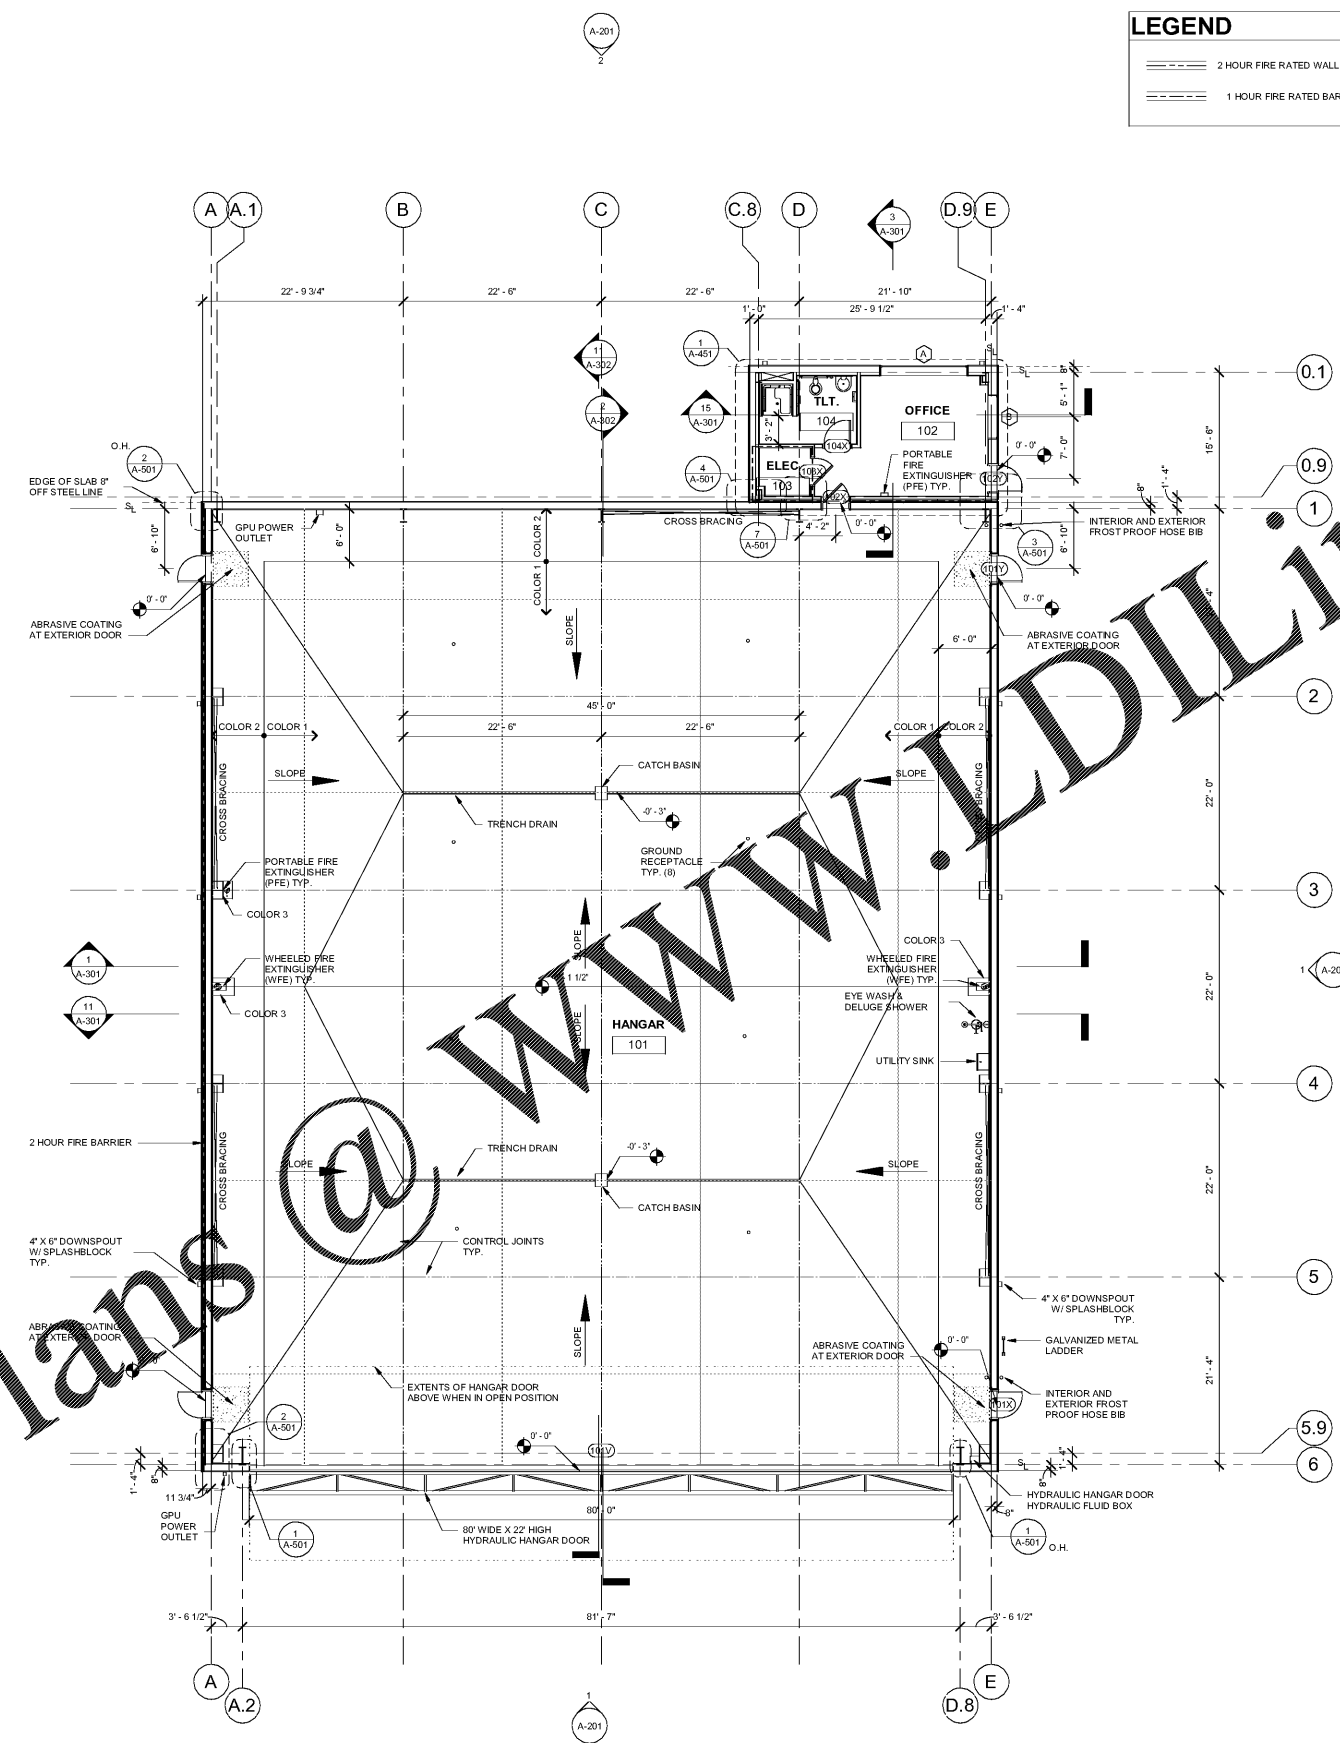

Order Plans @ WWW.DILine.com

1 FIRST LEVEL FLOOR PLAN
 1/8" = 1'-0"

