

THE WILSON GROUP
- ARCHITECTS -

PO Box 5510 Charlotte, NC 28299
704-331-9747 • www.twgarchitects.com

PROJECT MANAGER / CIVIL ENGINEER
TALBERT & BRIGHT

4810 SHELLEY DRIVE
WILMINGTON, NC 28405
(910) 763-5350
FIRM NO.: C-0713

STRUCTURAL ENGINEER
STEWART

101 N. TRYON ST., SUITE 1400
CHARLOTTE, NC 28202
(704) 334-7925
FIRM NO.: C-1051

FIRE PROTECTION, PLUMBING, MECHANICAL,
& ELECTRICAL ENGINEER
SABER ENGINEERING

2923 S TRYON ST #200
CHARLOTTE, NC 28203
(704) 373-0068

WATER & SEWER ENGINEER
McGILL ASSOCIATES

712 S VILLAGE ROAD SW, SUITE 103
SHALLOTTE, NC 28470
(910) 765-5072

COPYRIGHT © 2019
THE WILSON GROUP ARCHITECTS
ALL RIGHTS RESERVED
PRINTED OR ELECTRONIC DRAWINGS AND
DOCUMENTATION MAY NOT BE REPRODUCED
IN ANY FORM WITHOUT WRITTEN PERMISSION
FROM THE WILSON GROUP ARCHITECTS


REVISIONS

DATE 8/2/2019
PROJECT NUMBER 9217-000


SHEET TITLE
ENLARGED FLOOR PLANS AND ELEVATIONS

SHEET NUMBER
A-451


TOILET ACCESSORY LEGEND		
SYMBOL	DESCRIPTION	MODEL & NOTES
TA-1	19" GRAB BAR	BOBRICK B-5806.99X18
TA-2	36" GRAB BAR	BOBRICK B-5806.99X36
TA-3	42" GRAB BAR	BOBRICK B-5806.99X42
TA-4	SURFACE-MOUNTED HAND SOAP DISPENSER	BOBRICK B-2111
TA-5	WASTE RECEPTACLE	BOBRICK B-279
TA-6	24" X 48" FRAMED MIRROR	BOBRICK B-165.2436
TA-7	PAPER TOWEL DISPENSER	BOBRICK B-262
TA-8	SURFACE-MOUNTED TOILET TISSUE DISPENSER	BOBRICK B-2950
TA-9	SURFACE-MOUNTED SANITARY NAPKIN DISPOSAL	BOBRICK B-254
TA-10	SURFACE-MOUNTED CLOTHES HOOK	
TA-11	INSULATED TAIL PIECE AND HOT WATER PIPE (CLASS C RATING)	

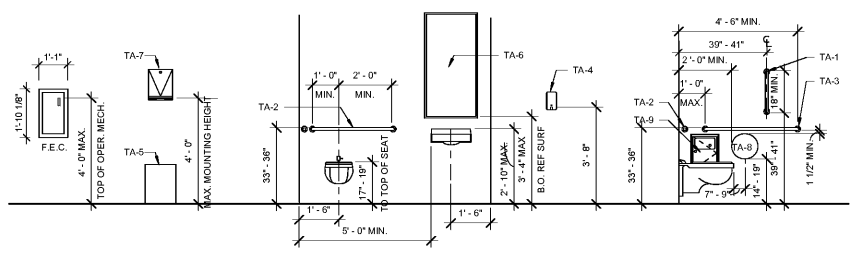


TYPICAL MOUNTING HEIGHTS
3/8" = 1'-0"

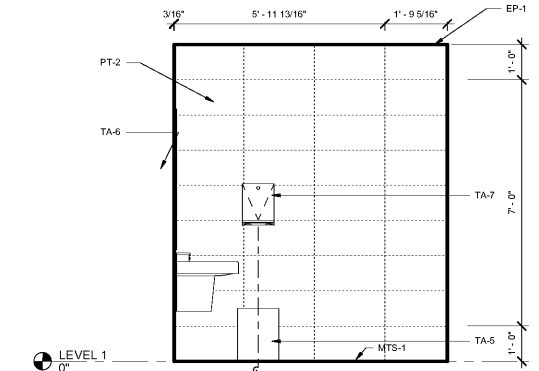


11 INTERIOR ELEVATION
1/2" = 1'-0"

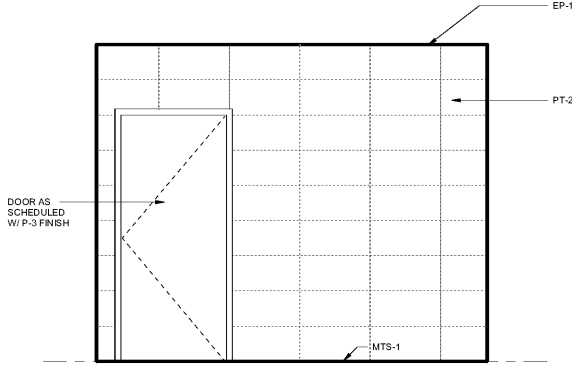


12 INTERIOR ELEVATION
1/2" = 1'-0"

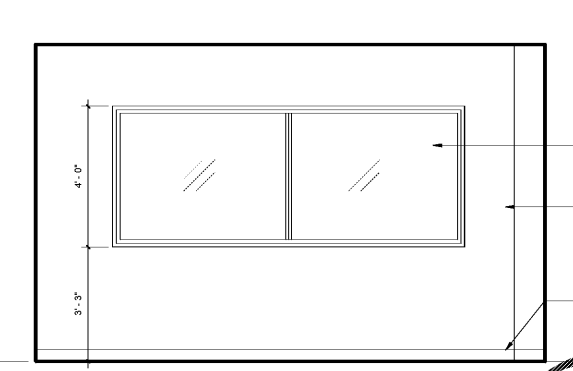


13 INTERIOR ELEVATION
1/2" = 1'-0"

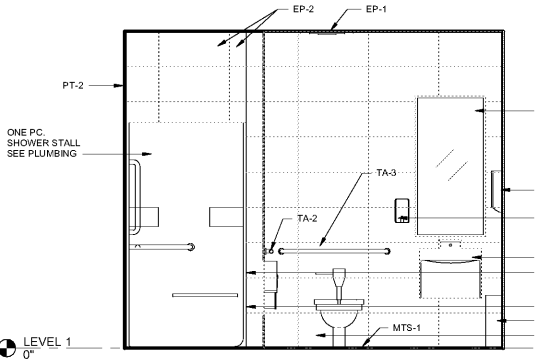


6 INTERIOR ELEVATION
1/2" = 1'-0"

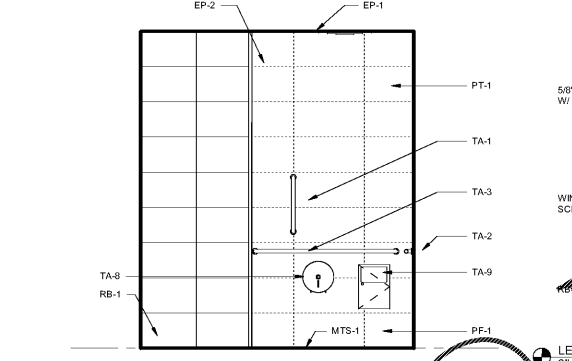


7 INTERIOR ELEVATION
1/2" = 1'-0"

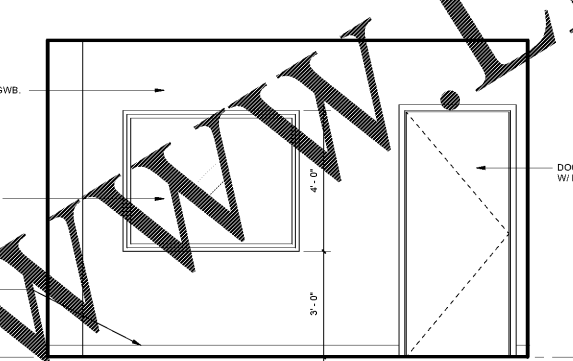


8 INTERIOR ELEVATION
1/2" = 1'-0"

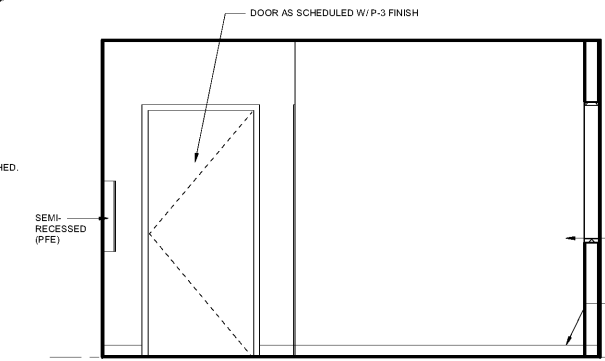

9 INTERIOR ELEVATION
1/2" = 1'-0"

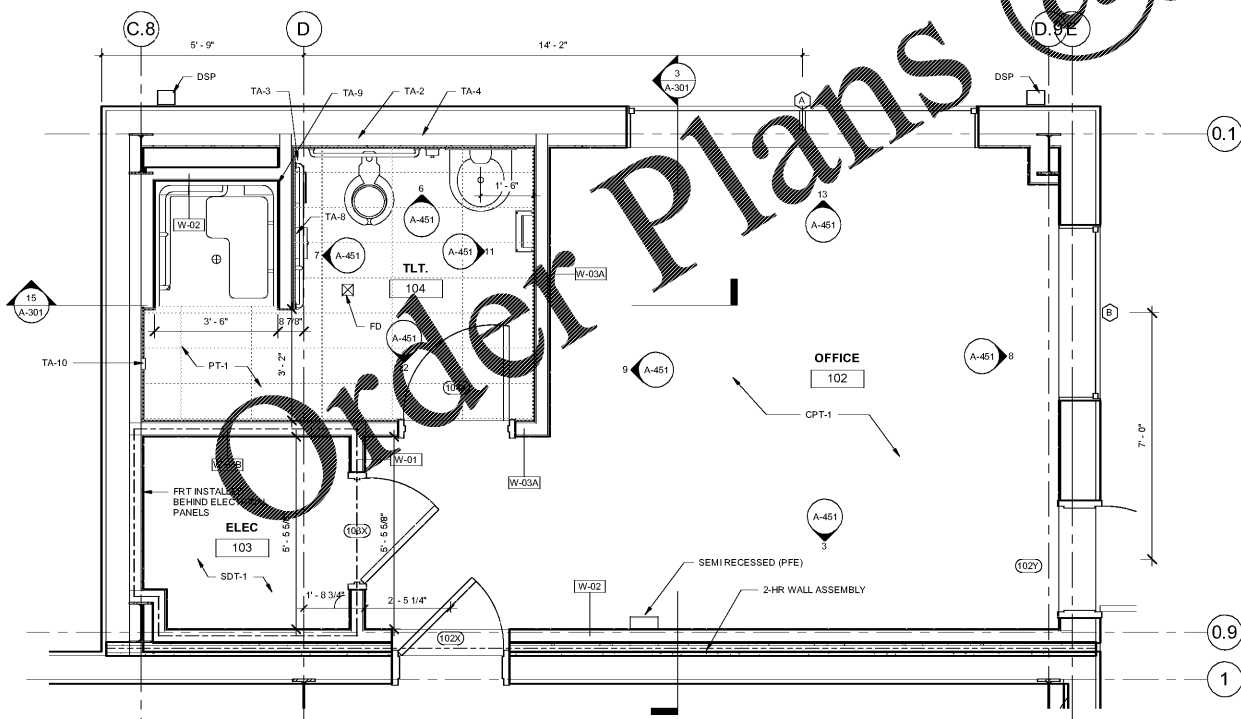

1 ENLARGED FLOOR PLAN
1/2" = 1'-0"

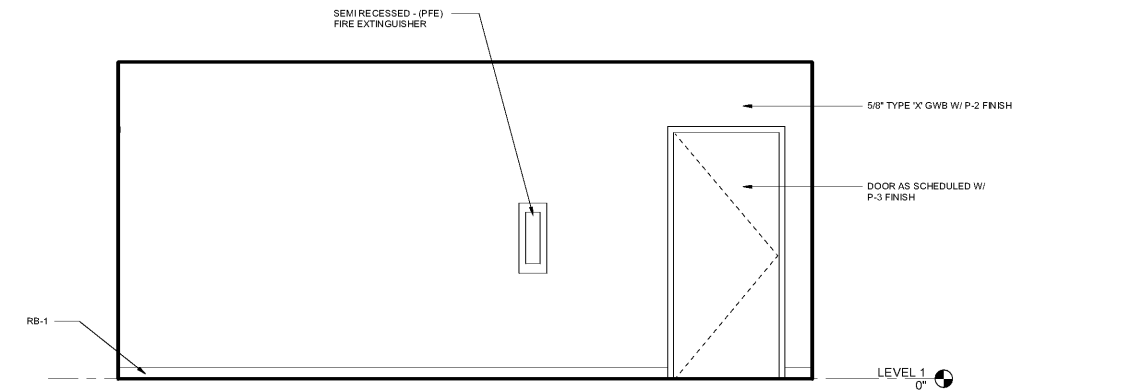

3 INTERIOR ELEVATION
1/2" = 1'-0"

WWW.LDILine.com

Order Plans @