




**SABER ENGINEERING**  
 2923 South Tryon Street Suite 280  
 Charlotte, North Carolina 28203  
 tel 704.373.0088

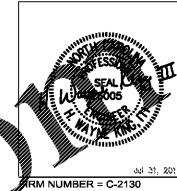


MECHANICAL ELECTRICAL PLUMBING  
 FIRM NUMBER = C-2130



**NEW CORPORATE HANGAR**  
 4005 AIRPORT ROAD  
 SOUTHPORT, NC 28441



ARCHITECT

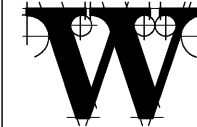

**THE WILSON GROUP**  
 P O BOX 5510  
 CHARLOTTE, NC 28226  
 (704) 331-8747

PROJECT MANAGER | CIVIL ENGINEER  
**TALBERT & BRIGHT**  
 4810 SHELLEY DRIVE  
 WILMINGTON, NC 28405  
 (910) 763-5350

STRUCTURAL ENGINEER  
**STEWART**  
 101 N. TRYON ST., SUITE 1400  
 CHARLOTTE, NC 28202  
 (704) 909-3523

MECHANICAL, ELECTRICAL, PLUMBING &  
 FIRE PROTECTION ENGINEER  
**SABER ENGINEERING**  
 2923 S. TRYON ST., SUITE 280  
 CHARLOTTE, NC 28203  
 (704) 373-0088


REVISIONS

NO.	DATE	DESCRIPTION

DATE **AUGUST 2, 2019**  
 PROJECT NUMBER **9217-000**

SHEET TITLE  
**MECHANICAL PLAN**

SHEET NUMBER  
**M2**

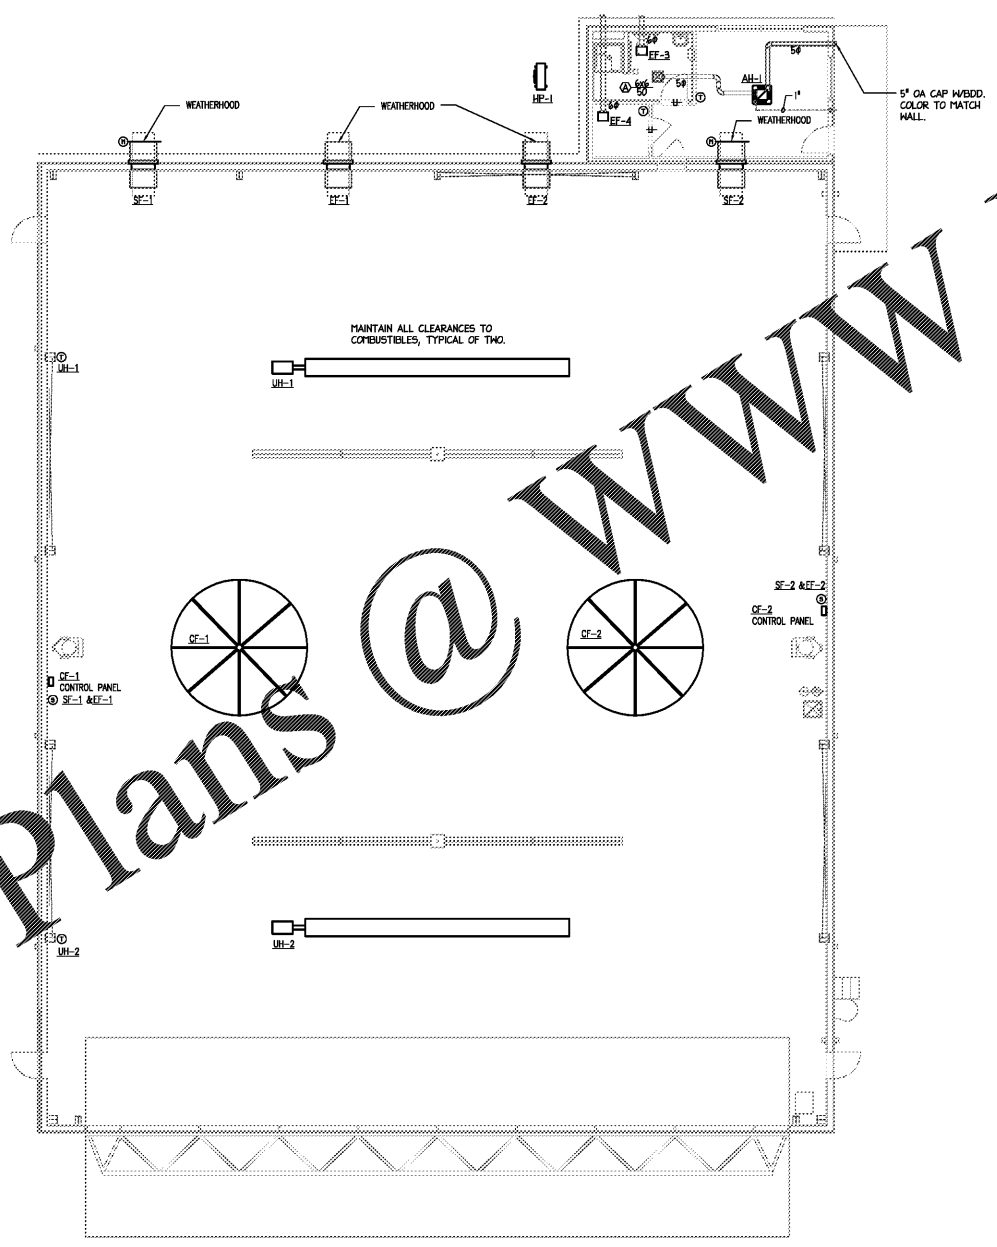

**1 MECHANICAL FLOOR PLAN**  
 1/8"=1'-0"

Order Plans @ [www.LDILine.com](http://www.LDILine.com)