



Pate Design Group, Inc.
Architecture / Interiors

4168 Abbotts Bridge Road
Duluth, Georgia 30097

(p) 770.814.0885
(f) 770.814.0886

Kirby@patedesigngroup.com


F-3 UNIT
WISTERIA RIDGE
Will-O-War LLC
75 North Main Street
Watkinsville, GA 30677

Issue & Revisions:

No.	Date	Description
1	04.01.19	CLARIFICATION

**LEVEL ONE
REFLECTED
CEILING PLAN**

Drawn
MWB
Checked
KEP
Contract No.
Scale
AS NOTED

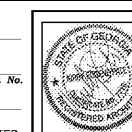


A2.1

040119

of sheets

THIS DRAWING IS THE PROPERTY OF PATE DESIGN GROUP AND IS NOT TO BE COPIED OR REPRODUCED IN ANY MANNER. IT IS TO BE USED ONLY FOR THE PROJECT AND SITE SPECIFICALLY IDENTIFIED HEREIN AND IS NOT TO BE USED IN ANY OTHER PROJECT. IT IS TO BE RETURNED UPON REQUEST.

RELEASED FOR CONSTRUCTION

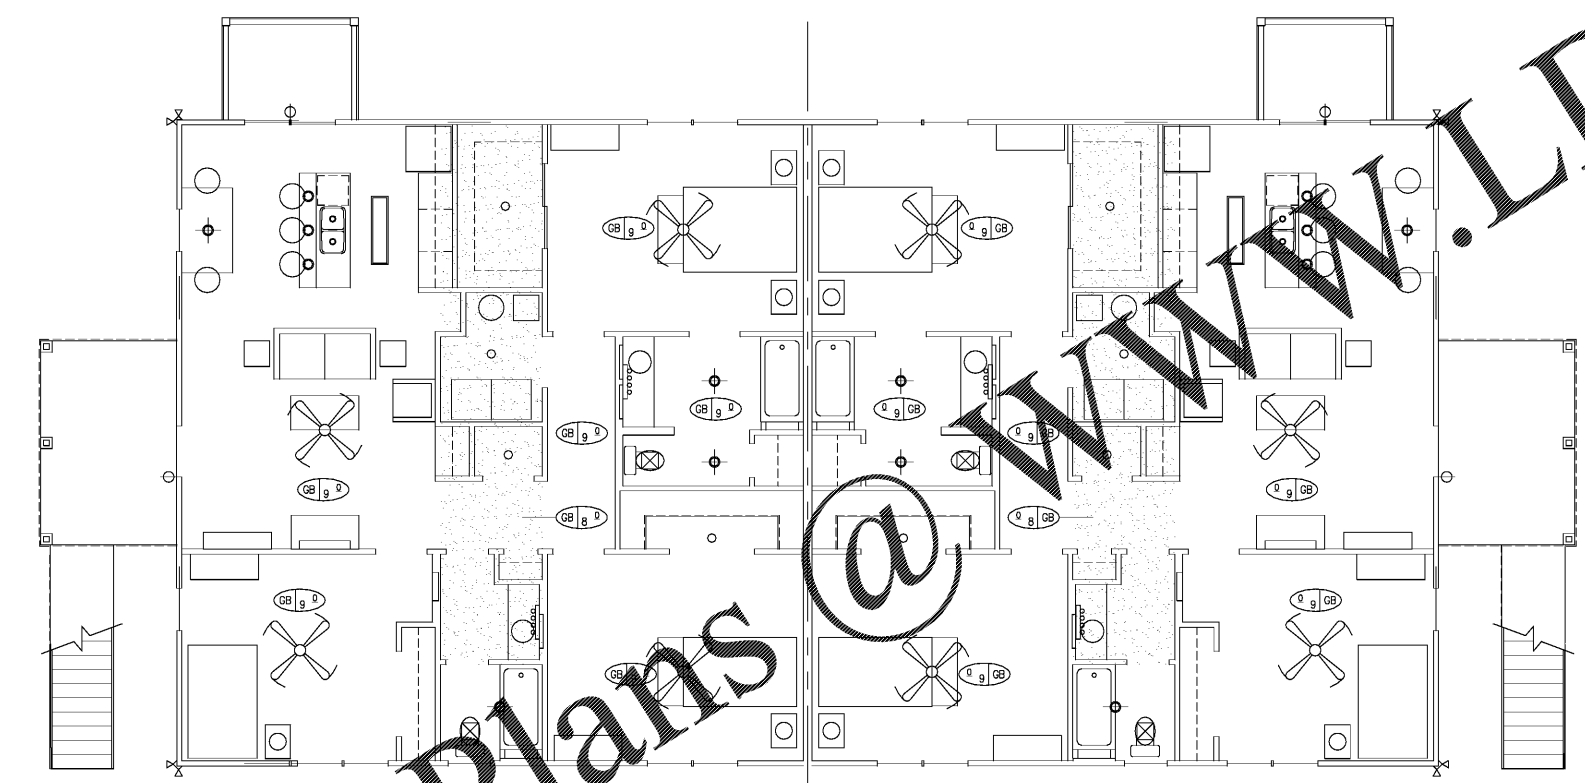

LIGHTING FIXTURE LEGEND	
	SURFACE MOUNT FAN/LIGHT FIXTURE SEE ELECTRICAL DRAWINGS
	TABLE LAMP
	SURFACE MOUNT 4 BULB VANITY LIGHT SEE ELECTRICAL DRAWINGS
	LOW-MOUNT PENDANT FIXTURE SEE ELECTRICAL DRAWINGS
	SURFACE MOUNT GLOBE FIXTURE SEE ELECTRICAL DRAWINGS
	SMALL GLASS PENDANT FIXTURE SEE ELECTRICAL DRAWINGS
	PHOTO-CONTROL HIGH PRESSURE SODIUM FIXTURE SEE ELECTRICAL DRAWINGS
	1'x4' SURFACE MOUNT FLOURESCENT FIXTURE SEE ELECTRICAL DRAWINGS
	EXTERIOR GRADE WALL MOUNTED FIXTURE SEE ELECTRICAL DRAWINGS
	4' SURFACE MOUNT FLOURESCENT STRIP FIXTURE - SEE ELECTRICAL DRAWINGS
	1'x2' SURFACE MOUNT FLOURESCENT FIXTURE SEE ELECTRICAL DRAWINGS
	EXHAUST FAN - SEE MECHANICAL DRAWINGS
	AREA OF 8'-0" A.F.F. GYP. CEILING
	2'x4' SURFACE MOUNT FLOURESCENT FIXTURE W/ CLOUD WRAP SEE ELECTRICAL DRAWINGS
	2'x4' SURFACE MOUNT FLOURESCENT FIXTURE W/ VANDAL RESISTANCE SEE ELECTRICAL DRAWINGS

CONSTRUCTION NOTES:

1. DOWNLIGHTS TO BE SWITCHED SEPARATELY AND ON DIMMERS.
2. NO EQUALS OR EQUIVALENTS ACCEPTED.
3. ALL FLOURESCENT LAMPS TO BE 3500K LAMPS.
4. ALL INCANDESCENT LAMPS TO BE FROSTED.

1 REFLECTED CEILING PLAN: Level One
SCALE: 1/4"=1'-0"
M1

Order Plans @ WWW.LDILine.com