



Pate Design Group, Inc.
Architecture / Interiors

4168 Abbots Bridge Road
Duluth, Georgia 30097

(p) 770.814.0885
(f) 770.814.0886

Kirby@patedesigngroup.com

G-1 AND G-2
WISTERIA RIDGE
Will-O-War LLC
75 North Main Street
Watkinsville, GA 30677

Issue & Revisions:

No.	Date	Description
1	04.01.19	CLARIFICATION

REFLECTED
CEILING PLAN
BASEMENT

Drawn
MWB
Checked
KEP
Contract No.
07-03
Scale
AS NOTED




A2.1

040119 of sheets

THIS DRAWING IS THE PROPERTY OF PATE DESIGN GROUP AND IS NOT TO BE COPIED IN WHOLE OR IN PART. IT IS TO BE USED FOR THE PROJECT AND FOR SPECIFICALLY IDENTIFIED ITEMS AND IS NOT TO BE USED IN ANY OTHER PROJECT. IT IS TO BE RETURNED UPON REQUEST.

RELEASED FOR CONSTRUCTION

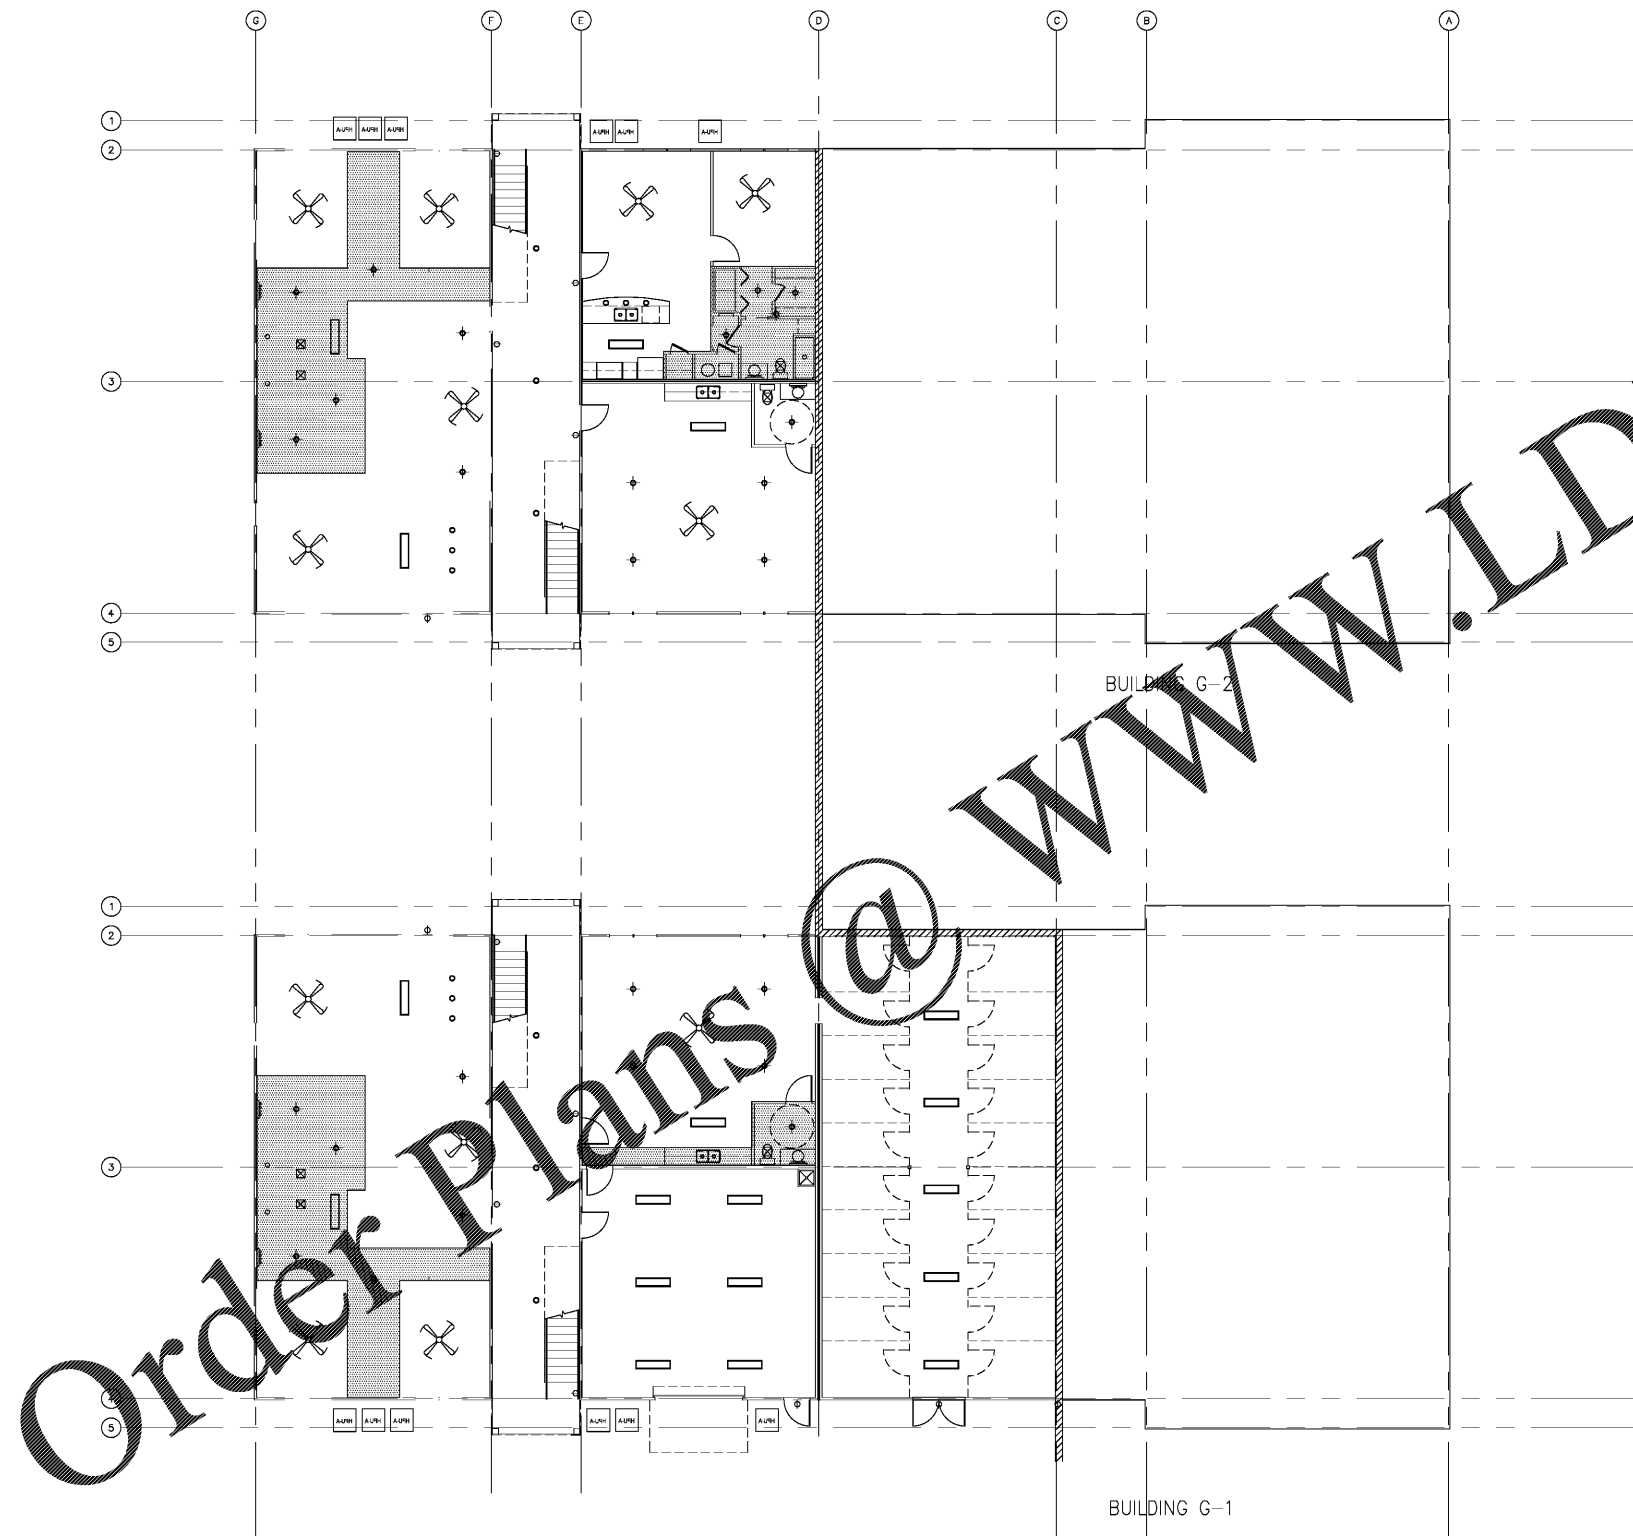

LIGHTING FIXTURE LEGEND

	SURFACE MOUNT FANLIGHT FIXTURE SEE ELECTRICAL DRAWINGS
	TABLE LAMP
	SURFACE MOUNT 4 BULB VANITY LIGHT SEE ELECTRICAL DRAWINGS
	LOW-MOUNT PENDANT FIXTURE SEE ELECTRICAL DRAWINGS
	SURFACE MOUNT GLOBE FIXTURE SEE ELECTRICAL DRAWINGS
	6" RECESSED DOWNLIGHT FIXTURE SEE ELECTRICAL DRAWINGS
	WALL MOUNT SCONCE FIXTURE SEE ELECTRICAL DRAWINGS
	1x4 SURFACE MOUNT FLOURESCENT FIXTURE SEE ELECTRICAL DRAWINGS
	EXTERIOR GRADE WALL MOUNTED FIXTURE SEE ELECTRICAL DRAWINGS
	4' SURFACE MOUNT FLOURESCENT STRIP FIXTURE - SEE ELECTRICAL DRAWINGS
	2'x2' RECESSED FLOURESCENT FIXTURE - ACRYLIC LENS SEE ELECTRICAL DRAWINGS
	2'x4' SURFACE MOUNT FLOURESCENT FIXTURE W/ ACRYLIC LENS - SEE ELECTRICAL DRAWINGS
	EXHAUST FAN - SEE MECHANICAL DRAWINGS
	AREA OF 8'-2" AFF. GYP. CEILING

CONSTRUCTION NOTES:

- ◆ DOWNLIGHTS TO BE SWITCHED SEPARATELY AND ON DIMMERS.
- ◆ NO EQUALS OR EQUIVALENTS ACCEPTED.
- ◆ ALL FLOURESCENT LAMPS TO BE 3500K LAMPS.
- ◆ ALL INCANDESCENT LAMPS TO BE FROSTED.
- ◆ DOWNLIGHTS TO BE PLACED ON CENTERLINE OF SOFFIT U.O.N.
- ◆ GYP. CEILING TO BE INSTALLED ON RESILIENT CHANNELS ON BOTTOM CHORD OF ROOF TRUSS.

- RCP NOTES:
1. ALL GWB CEILINGS AT 9' ATT. UNO
 2. INSTALL GWB CLSS IN ACCORDANCE W UL DETAILS FOR FLOOR/CLG ASSEMBLY
 3. COMPLY WITH GYP ASSOC BEST PRACTICES FOR GWB CLSS AND EXP/CONTROL JOINTS
 4. INCLUDE ALL REQUIRED ACCESS PANELS

1 REFLECTED CEILING PLAN: Basement
SCALE: 1/8"=1'-0"



JOB NORTH