



Pate Design Group, Inc.
Architecture / Interiors

4168 Abbotts Bridge Road
Duluth, Georgia 30097

(p) 770.814.0885
(f) 770.814.0886

Kirby@patedesigngroup.com


G-1 AND G-2
WISTERIA RIDGE
Will-O-War LLC
75 North Main Street
Watkinsville, GA 30677

Issue & Revisions:

No.	Date	Description
REV 1	04/01/19	CLARIFICATION

MAIN AND
UPPER FLOOR
ELECTRICAL
PLANS

Drawn
TSL
Checked
TSL
Contract No.

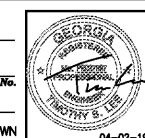

Scale
AS SHOWN

04-02-19

G-E1.2

03-05-19 of sheets

Lastinger & Associates, Inc.


6790 Abbotts Bridge Road - Suite 401
Johns Creek, GA 30097
Georgia #PE057597

PH: (770) 622-7023
LAB#19130

SHIRT SIZE: 30x42

THIS DRAWING IS THE PROPERTY OF PATE DESIGN GROUP AND IS NOT TO BE COPIED OR REPRODUCED IN ANY MANNER WITHOUT THE WRITTEN PERMISSION OF PATE DESIGN GROUP. IT IS TO BE USED FOR THE PROJECT AND THE SPECIFICALLY IDENTIFIED HEREIN AND IS NOT TO BE USED IN ANY OTHER PROJECT. IT IS TO BE RETURNED UPON REQUEST.

RELEASED FOR CONSTRUCTION

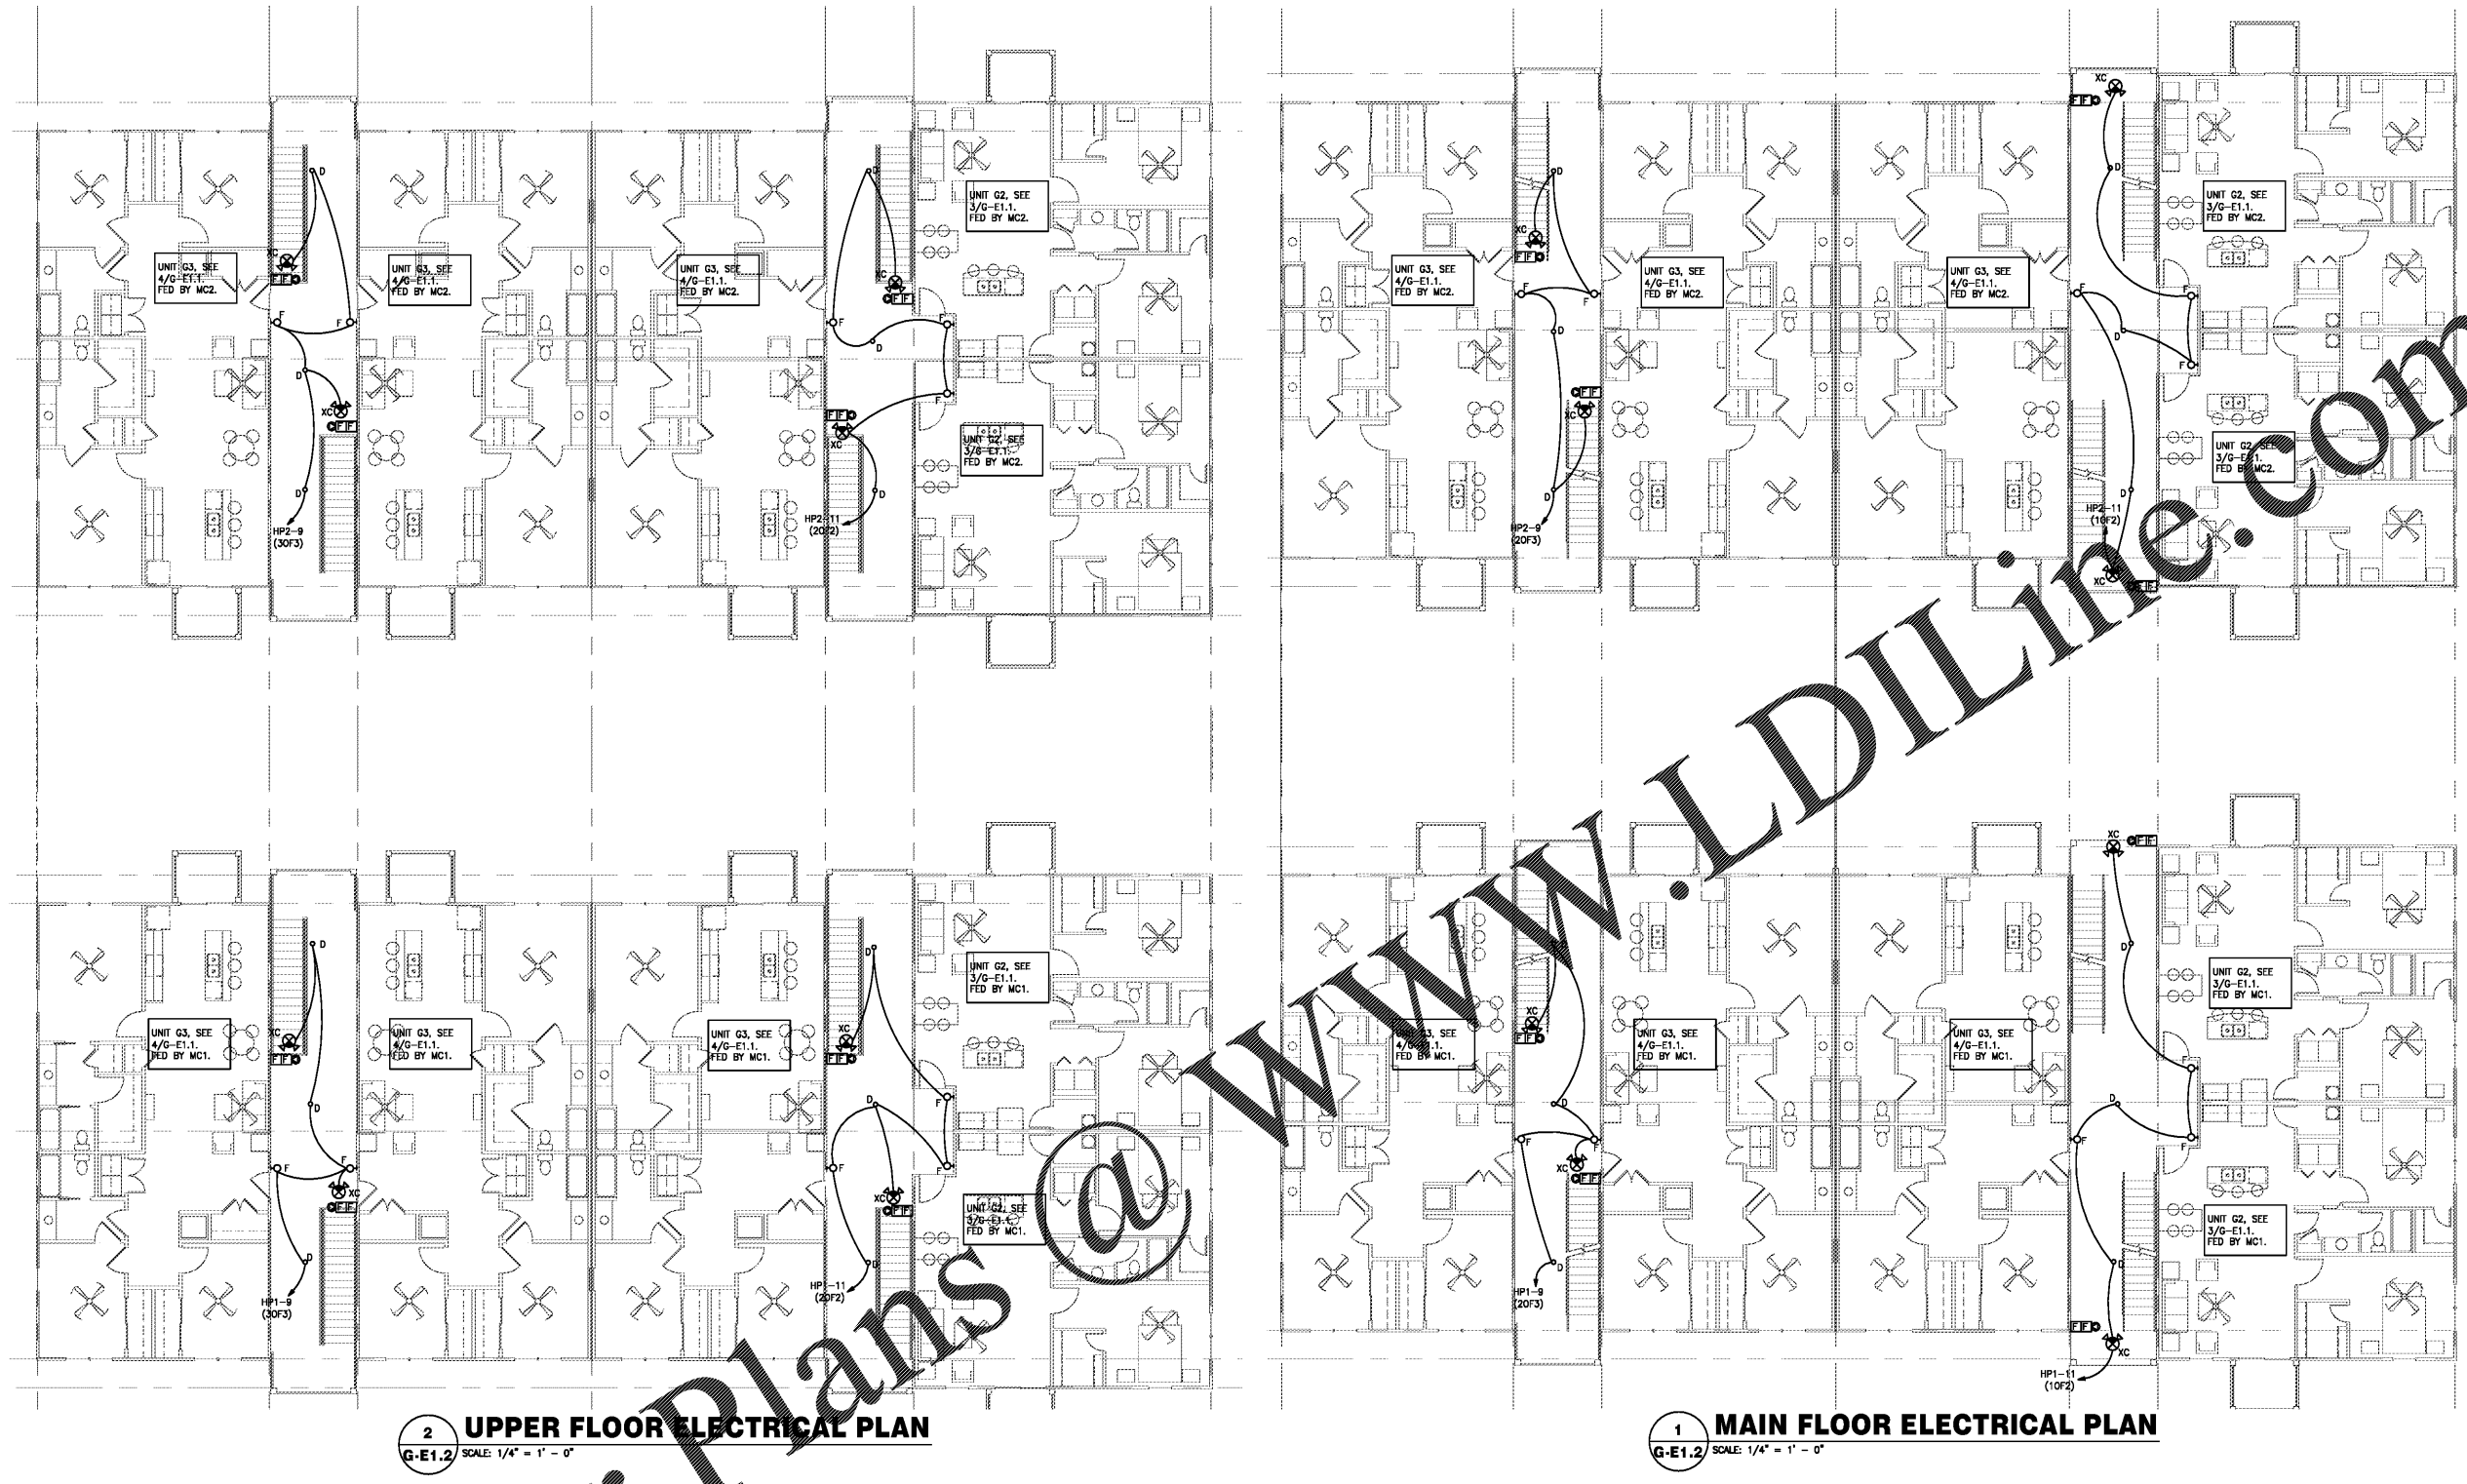

2 UPPER FLOOR ELECTRICAL PLAN
G-E1.2 SCALE: 1/4" = 1' - 0"

1 MAIN FLOOR ELECTRICAL PLAN
G-E1.1 SCALE: 1/4" = 1' - 0"

Order Plans @ WWW.LDILine.com