


BUILDING DIMS ARE PER BURGER KING'S ARCHITECTURALS. MUST BE VERIFIED!

FLOOR PLAN KEY

	ELECTRICAL OUTLET BY G.C.
	EIS HALF WALL
	NEW G.C. FULL HT. WALL
	G.C. TO FILL IN EXISTING WINDOW

NOTE: ALL ELECTRICAL OUTLETS TO BE CENTERED ON TABLE EXCEPT FOR ADA LOCATIONS. ADA LOCATION OUTLETS TO BE 7" O.C. FROM TABLE EDGE.

NOTE:
 - THIS IS PROPRIETARY TO EIS. ANY UNAUTHORIZED USE OR REPRODUCTION IS STRICTLY PROHIBITED.
 - EIS WILL NOT BE HELD LIABLE FOR NON-EIS ITEMS THE CUSTOMER PURCHASED AND DO NOT FIT IN THE INTENDED SPACE.

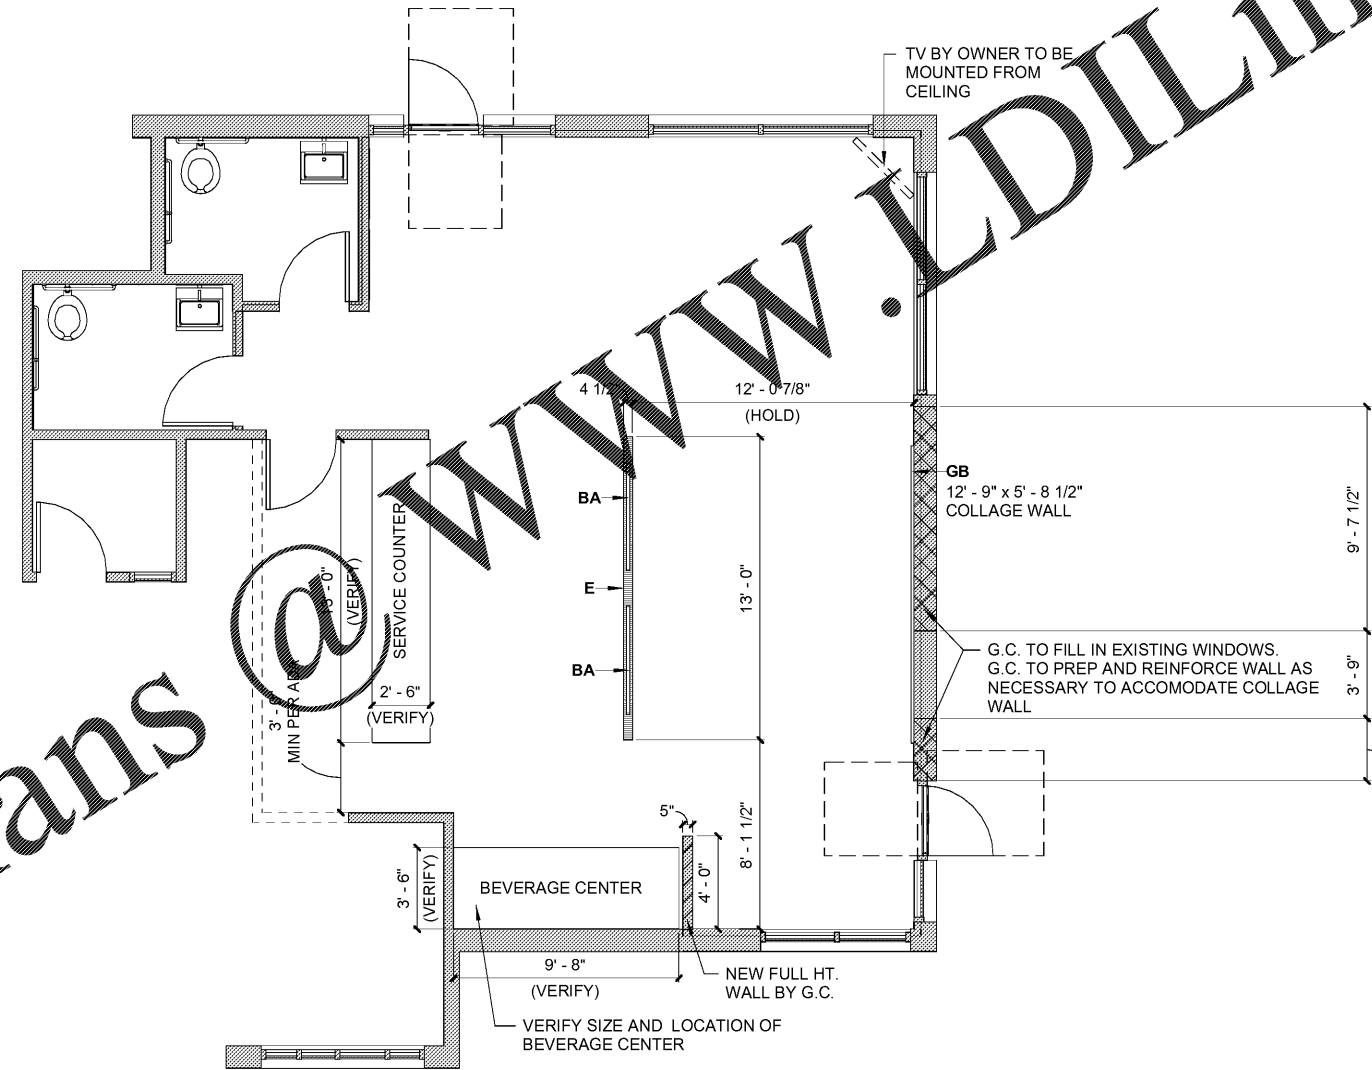

(A) Dimension Plan
 3/16" = 1'-0"

Order Plans

WWW.LDILine.com

FINAL PLANS



National #200380
 Garden Grill

Account Executive
Donnie Harrison
 706-604-7680
 donnie.harrison@elkay.com

 
Drawn By
DP
 Date:
06/11/2019

Contact
Bruce Daniels
 646-462-5481
 bruce.daniels@carolinfranchiseholdings.com

Designer
Grace Schneider
 414-847-0748
 grace.schneider@elkay.com

Location
 206 Longstreet St
Kingstree, SC
 29556

Project Manager
Ryan Spannagle
 414-847-0658
 ryan.spannagle@elkay.com



BY
 GS
 GS
 GS/KD

REVISIONS
 DATE DESCRIPTION
 06/11/19 Bid Set Created
 06/14/19 Brand Review Approved
 06/18/19 Final Set Created

Project Number
112891

Sheet Title
Dimension Plan

Sheet
I-1d