
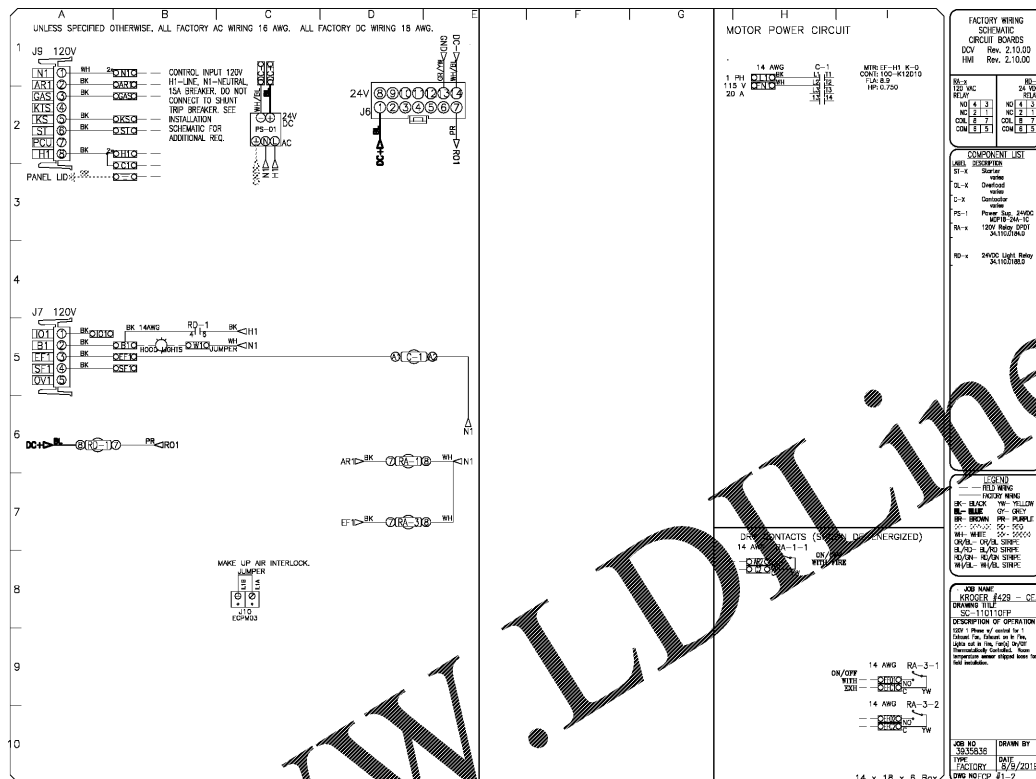



ELECTRICAL PACKAGE - Job#3935836

NO.	TAG	PACKAGE #	LOCATION	SWITCHES		OPTION	FANS CONTROLLED					
				LOCATION	QUANTITY		FAN TAG	TYPE	#	H.P.	VOLTS	FLA
1		SC-110110FP	Wall Mount In SS Box	UZ - FROG MOUNT RIGHT SIDE of Hood	1 Light	Smart Controls Thermostatic Control	EF-H1 K-006295	Exhaust	1	0.750	115	8.9

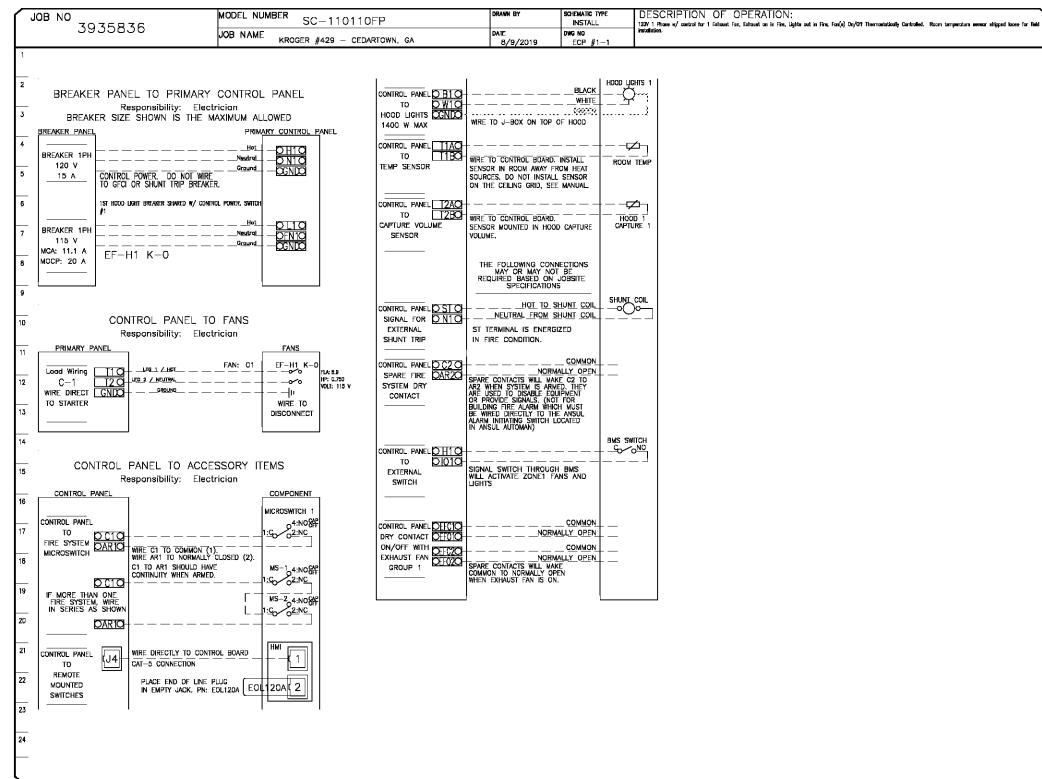


TEMPERATURE SENSOR INTERLOCK

THE TEMPERATURE SENSOR INTERLOCK OPTION COMPLIES WITH IMC 507.1.1.1 AND NFPA 96 11.1.1 BY INTERLOCKING WITH COOKING APPLIANCES THROUGH MEANS OF A HEAT SENSOR TO AUTOMATICALLY ACTIVATE EXHAUST FANS DURING COOKING OPERATIONS.

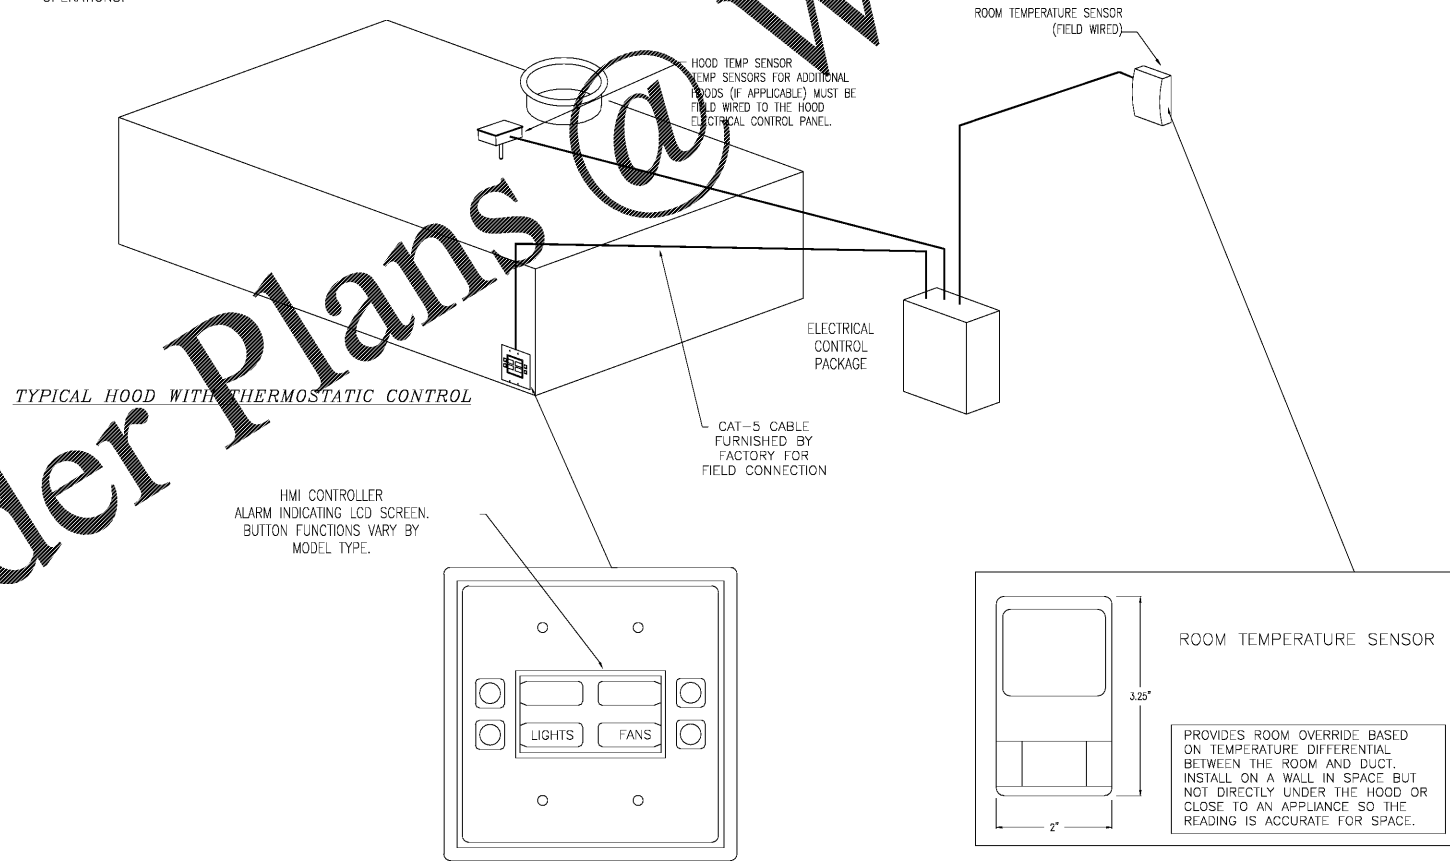

Order Plans @

WWW.LDOnline.com

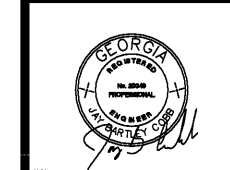

J. B. Cobb Engineering, LLC
 Mechanical/Industrial
 97 Lakewood Drive
 Dallas, GA 30132
 Office: (678) 363-8754
 Fax: (678) 363-8754
 Cell Phone: (404) 403-2126
 jbcobb@bellouth.net

A REMODEL FOR:
KROGER GA-429
 730 NORTH MAIN STREET
 CEDARTOWN, GA

8-12-2019
 CONSTRUCTION SET

HVAC DETAILS

NO.	DATE	DESCRIPTION

PROJECT NO. GPS2019-060.4
 CAD DWG FILE: GPS2019-060.4-P1.1
 DRAWN BY: JBC
 CHKD BY: JML/LEN

M5.3