



ITEM #	DESCRIPTION	QUANTITY	COMPANY	MODEL	MOUNT	FINISH	REMARKS/SUPPLY
1	MIRROR	4	CUSTOM		WALL MOUNTED ON Z-CLIPS		MIRROR SIZE: 2'-0" x 4'-0" G.C. SHALL FURNISH AND INSTALL FLYWOOD BLOCKING IN WALL.
2	RECESSED SEAT COVER DISPENSER	4	BOBRICK	B-3013	RECESSED	SATIN STAINLESS STEEL	
3	SANITARY NAPKIN DISPOSAL & TOILET TISSUE DISPENSER	4	BOBRICK	B-3004	RECESSED	SATIN STAINLESS STEEL	
4	PAPER TOWEL DISPENSER	4	BOBRICK	B-3944	RECESSED	SATIN STAINLESS STEEL	
5	GRAB BARS	10	BOBRICK	B-5806X18 5806X36 B-5806X42	WALL MOUNTED	SATIN STAINLESS STEEL	G.C. TO FURNISH AND INSTALL NECESSARY BLOCKING
6	TOILET	4		PREFERRED WALL MOUNT KOHLER K-4325-0.1.28 GPF K-7531-CP 1.28 GPF ALTERNATE FLOOR MOUNT (USE ONLY IF WALL CAVITY NOT SUFFICIENT FOR WALL MOUNT) AMERICAN STANDARD 3043.001	WALL MOUNTED / FLOOR MOUNTED	WHITE	16 1/2" H: K-4731-GC (WHITE) INSTALL WALL BLOCKING AS REQUIRED BY MANUFACTURER 17 1/2" H BEMIS NO. 1955-SSC. OPEN FRONT, SELF SUSTAINING CHECK HING SEAT HANDICAPPED ACCESSIBLE
7	LAVATORY	4	BATH COLLECTIONS	UNLIMITED 60 60 01	WALL MOUNTED	WHITE	23" W. REFERENCE PLUMBING SHEETS.
8	FAUCET	4	KOHLER	K-13467		CP	REFERENCE PLUMBING SHEETS.
9	DRINKING FOUNTAIN	1	ELKAY	LZSWSSP	WALL-MOUNTED		PROVIDE OPTIONAL LKAPREZ APRON.

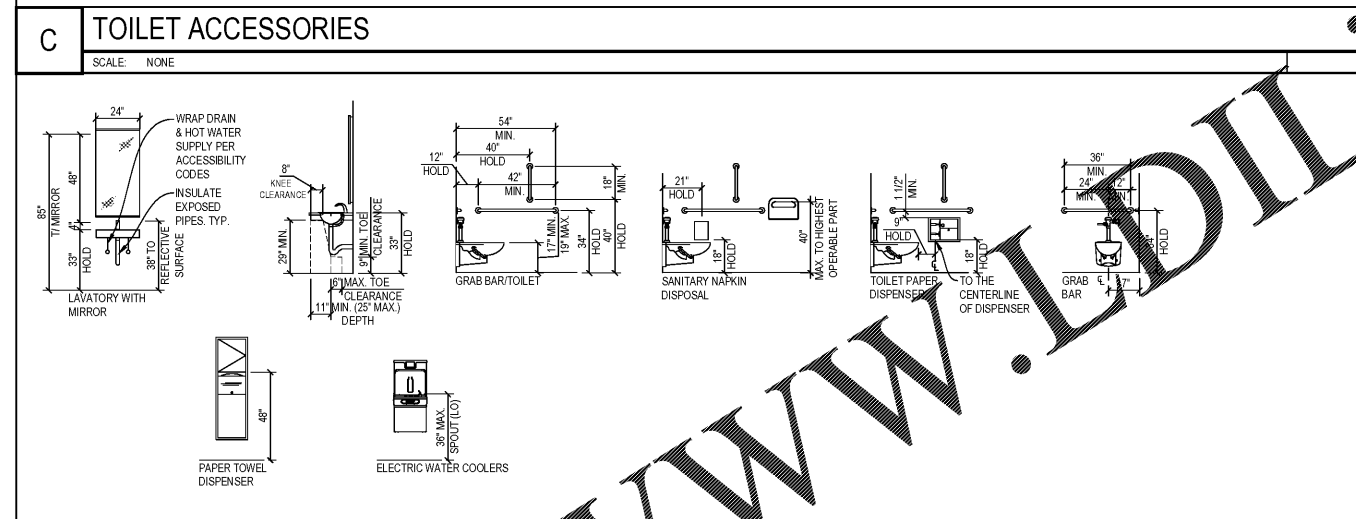


3 PATH OF TRAVEL TO COMMON AREA MOP SINK SCALE: N.T.S.

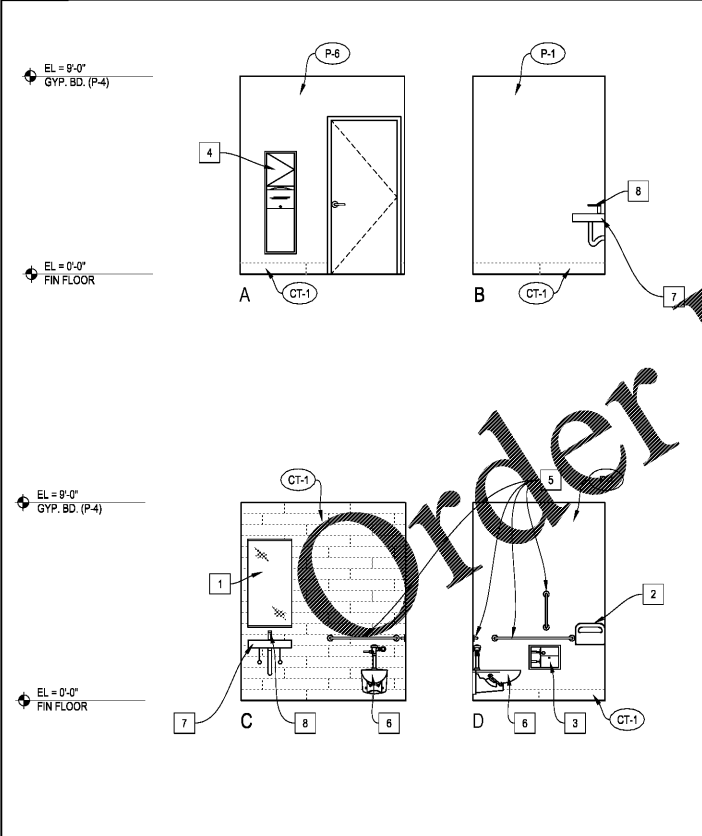


2 TYPICAL RESTROOM ELEVATION SCALE: 1/8" = 1'-0" NOTE: SEE SHEET A4.1 FOR FINISH SPECIFICATIONS

B TYPICAL MOUNTING DETAILS SCALE: 1/4" = 1'-0"

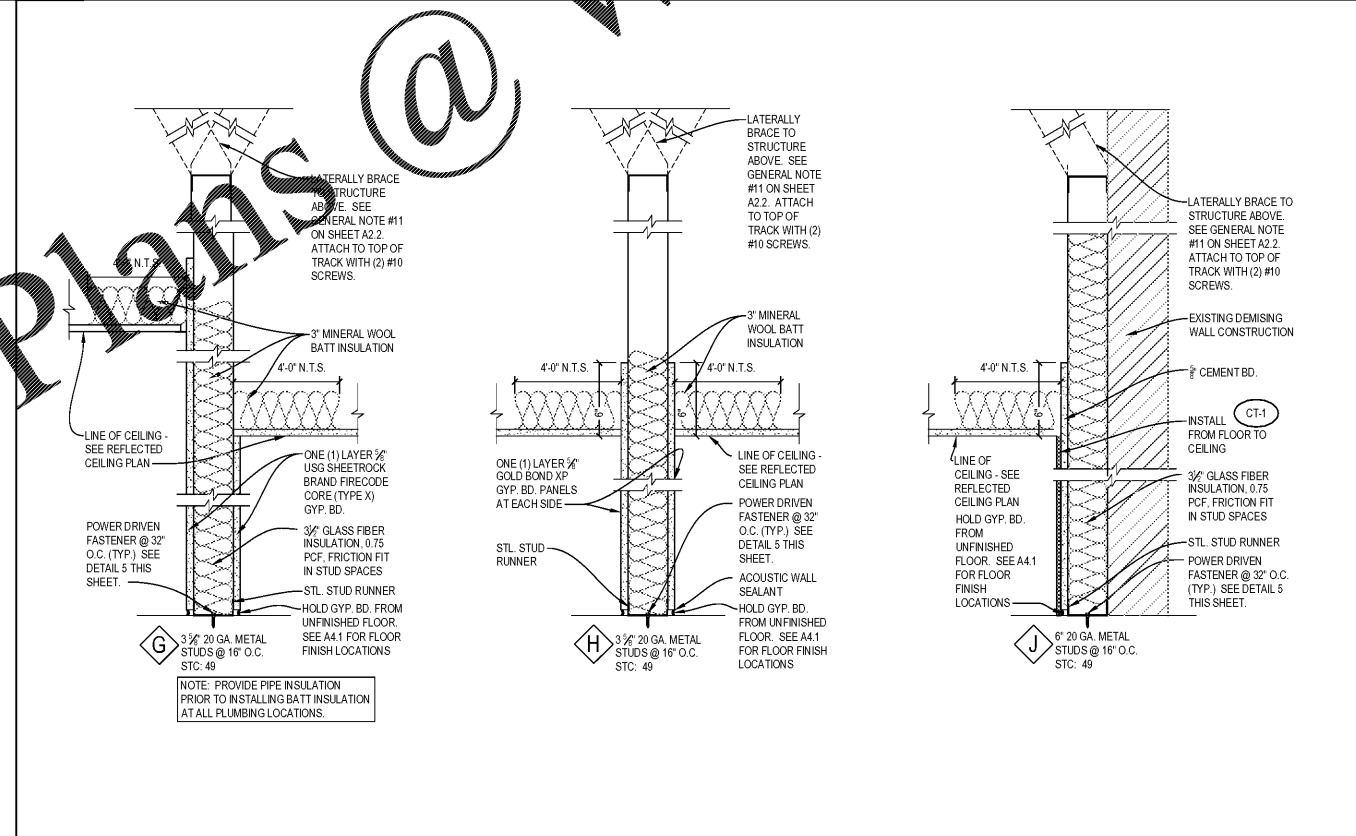

1 WALL TYPES SCALE: N.T.S.

- NOTE:
- ALL JOINTS/SEAMS AND PLUMBING FIXTURES WHERE THEY MEET WALL/FLOOR TO BE CAULKED WHERE CERAMIC TILE MEETS WALL. PAINT, CAULK COLOR: LATICRETE #59 - ESPRESSO
 - TOP TILE TO HAVE BULLNOSE EDGE.
 - WET WALL AND FLOOR TILE SHALL RUN IN THE SAME DIRECTION, HORIZONTAL.
 - DIMENSIONS ARE TO FACE OF GYP. BD., U.N.D. SEE WALL TYPES ON A2.2 SHEET FOR FURTHER INFORMATION.
 - UNDERCUT DOORS TO RESTROOMS 1".
 - G.C. TO FURNISH ALL RESTROOM ACCESSORIES UNLESS NOTED OTHERWISE.

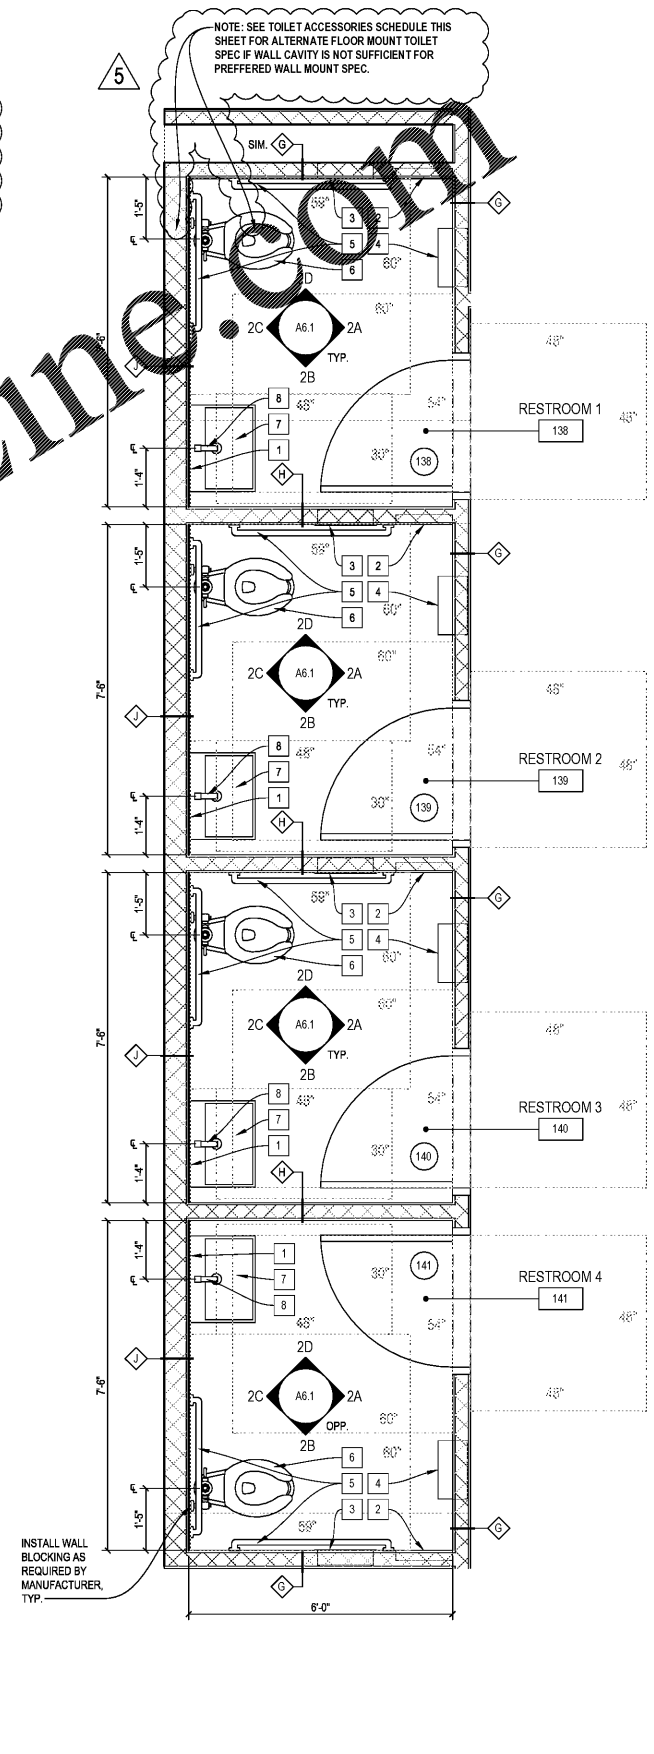

A RESTROOM DIMENSION PLAN SCALE: 1/4" = 1'-0"

fusion

FUSION ACADEMY
3540 TORINGDON WAY, STE #100
CHARLOTTE, NC 28277

RESTROOM DETAILS

CA

CHIPMAN DESIGN
ARCHITECTURE INC
JOHN A. CHIPMAN, ARCHITECT
1000 W. WILSON ST., SUITE 100
CHARLOTTE, NC 28202
PHONE: 847.798.9990

- Revisions
- △ ISSUE FOR PERMIT 08/19/19
 - △ ISSUE FOR CLIENT/LIANT REVIEW 08/23/19
 - △ REVISION PER CLIENT 08/30/19
 - △ ISSUE FOR BID 08/30/19

08/19/2019 06/30/2020
DATE EXPIRATION DATE

I HEREBY CERTIFY THAT THESE PLANS HAVE BEEN PREPARED UNDER MY SUPERVISION AND THAT TO THE BEST OF MY KNOWLEDGE, THE SAME COMPLY WITH ALL RULES, REGULATIONS AND ORDINANCES OF CHARLOTTE, NC RELATING TO STRUCTURES AND BUILDINGS.

ARCHITECT

Drawn By: BB Checked By: BW
Scale: AS NOTED Date: 08/19/19
Job No: 18-7842
Sheet No: A6.1