


K
J
H
G
F
E
D
C
B
A

Order Plans @ www.LDILine.com

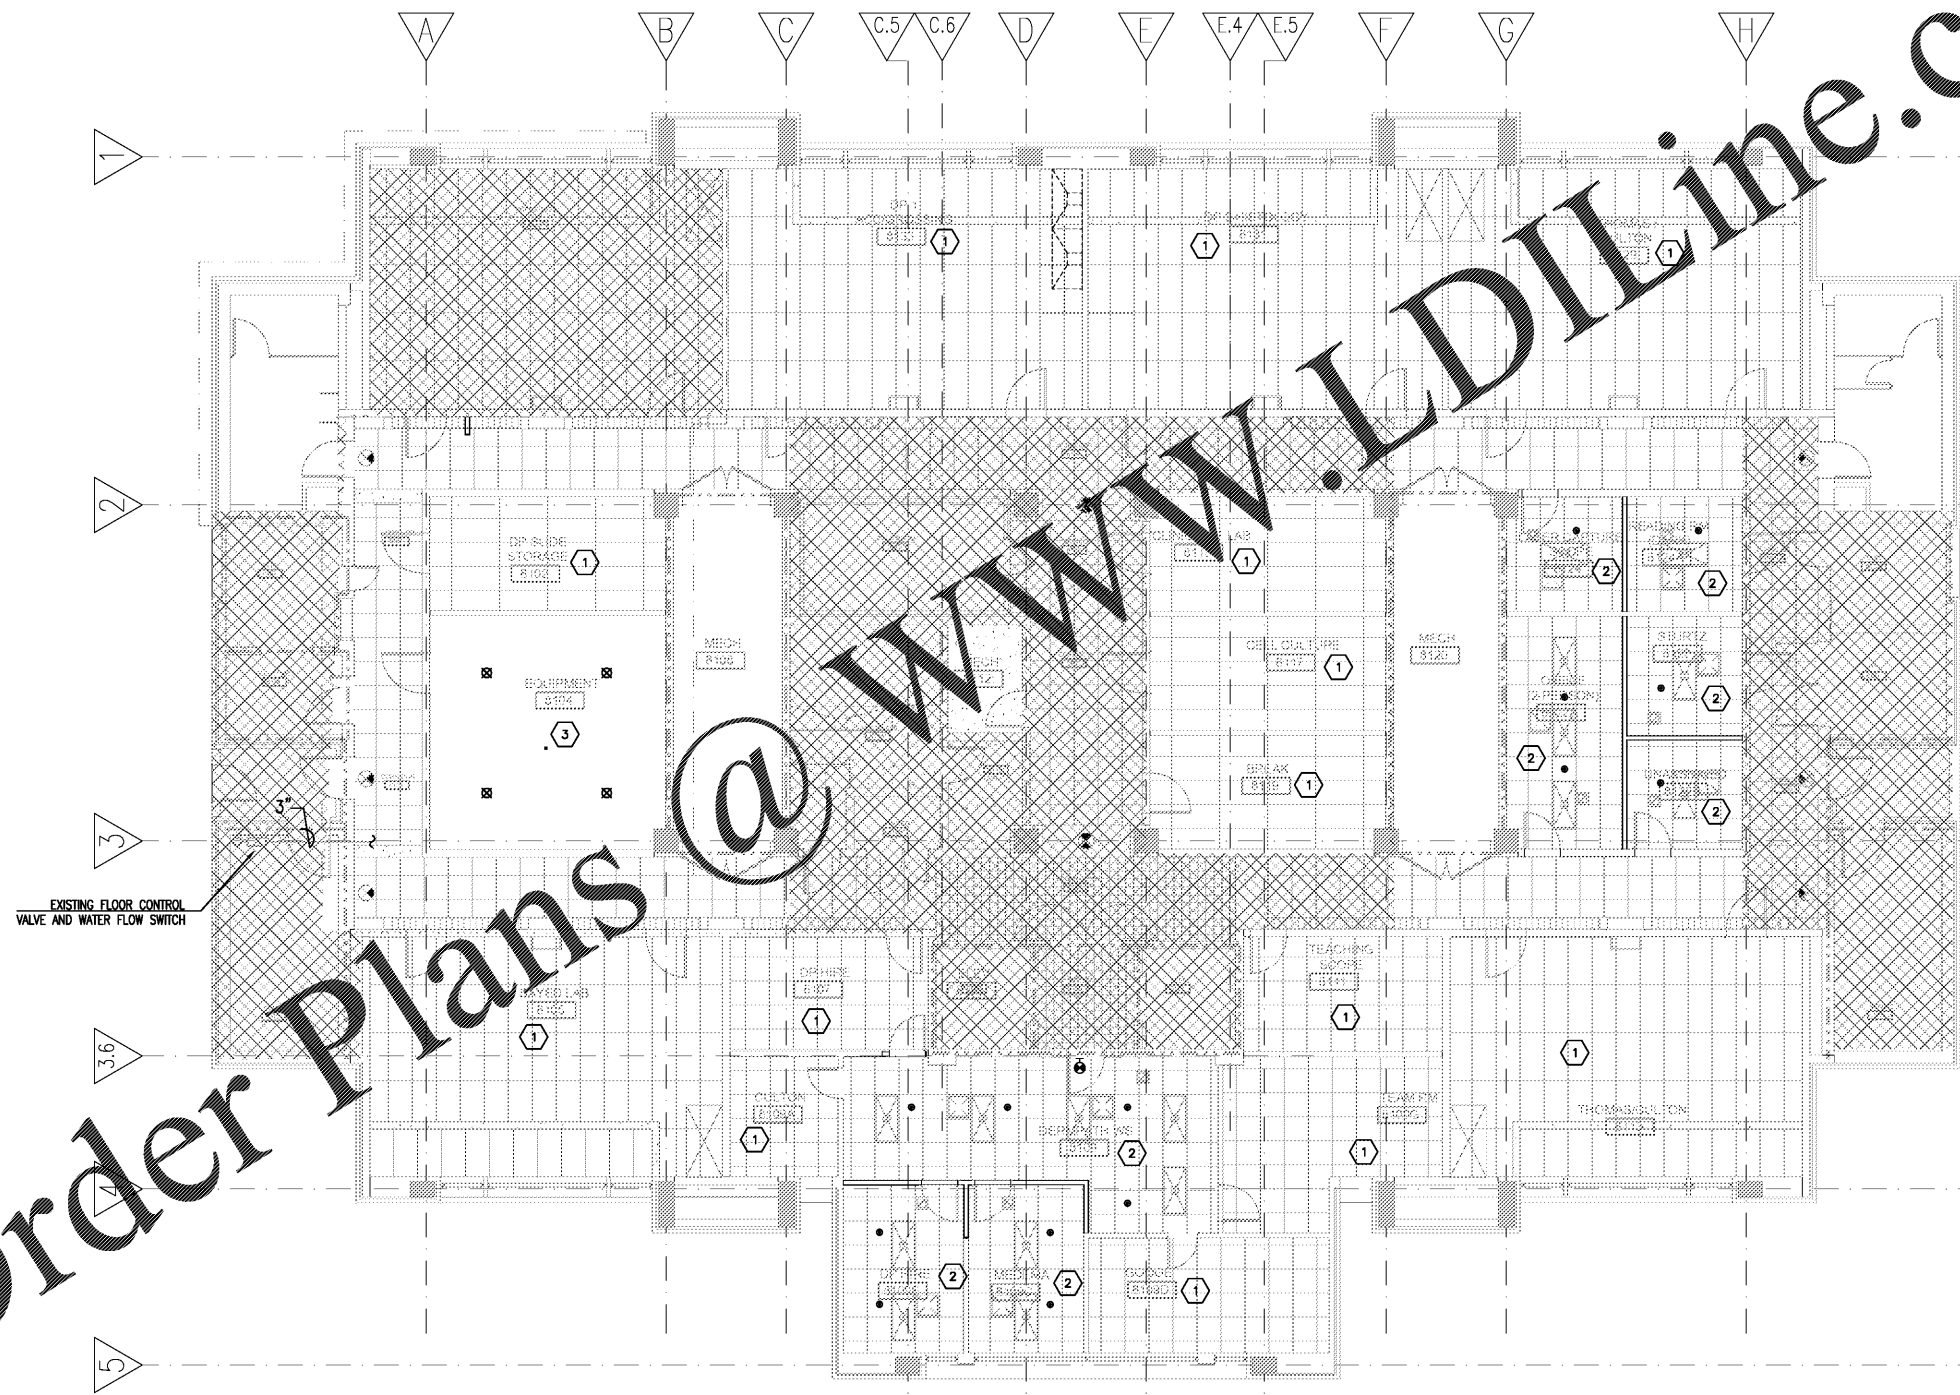

- GENERAL NOTES**
- BRANCH PIPING SHALL BE INSTALLED TO MATCH CONTRACTOR WORKING DRAWINGS AND SHALL BE RE-WORKED AS NEEDED TO COORDINATE WITH DUCTWORK, REHEAT COILS, LIGHT FIXTURES, ETC.
 - SPRINKLER HEADS SHALL BE CENTERED IN CEILING TILES.
 - REFER ALSO TO ARCHITECT'S REFLECTED CEILING PLAN, SHEET A408.
 - FLEXIBLE PIPE SPRINKLER CONNECTORS SHALL NOT BE UTILIZED UNLESS HYDRAULIC CALCULATIONS ARE COMPLETED.

- SHEET KEYED NOTES:**
- NO SPRINKLER WORK THIS ROOM.
 - REMOVE AND REPLACE EXISTING PENDANT SPRINKLERS WITH NEW, PENDANT SPRINKLERS IN THIS ROOM. SPRINKLERS SHALL BE CENTERED IN CEILING TILES. RE-WORK BRANCH PIPING AS NEEDED TO COORDINATE WITH OTHER TRADES INCLUDING LIGHT FIXTURES, DIFFUSERS, AND DUCTWORK.
 - REMOVE AND REPLACE EXISTING PENDANT SPRINKLERS WITH NEW, UPRIGHT SPRINKLERS IN THIS ROOM. RE-WORK BRANCH PIPING AS NEEDED TO COORDINATE WITH OTHER TRADES INCLUDING LIGHT FIXTURES, FAN COIL UNIT, AND DUCTWORK. SPRINKLER HEADS SHALL BE LOCATED SO THAT DUCTWORK, FAN COIL UNIT, AND LIGHTS DO NOT OBSTRUCT SPRINKLER FLOW.

PARTITION AND WALL LEGEND

	1-HOUR FIRE BARRIER
	2-HOUR FIRE BARRIER

1 EIGHTH FLOOR PLAN - FIRE PROTECTION
FP100 1/8" = 1'-0"



Kramer Engineering Services, plc
5517 Cascade Dr.
Chapel Hill, NC 27514
TEL: (919) 933-3350
email: Donna@KESplc.com
Firm License: P-1099



REVISION

UNC SCHOOL OF MEDICINE
NEUROSCIENCES RESEARCH BUILDING
7th & 8th FLOORS FOR DERMATOLOGY

LOCATION
115 Mason Farm Road, Campus Box 7250
Chapel Hill, North Carolina 27598-7250

ISSUE DATE
09/25/2019
JOB NO.
10761-00
DWG. NO.

FP108

BID SET

LORD AECK SARGENT
A KATERRA COMPANY
© 2019 Lord Aeck Sargent. All rights reserved. This document is the sole property of Lord Aeck Sargent and is to be returned upon demand. The information contained herein may not be used or divulged without the written permission of Lord Aeck Sargent.