

GENERAL NOTES

1. MEASURE AND RECORD AIRFLOW PRIOR TO START OF CONSTRUCTION IN ALL RENOVATION AREAS.
2. PATCH, SEAL AND INSULATE DUCTWORK WHERE BRANCH DUCTS ARE REMOVED AND NOT RE-USED. REMOVE UNUSED DUCT HANGERS.
3. WHERE EXISTING DIFFUSERS OR GRILLES ARE REINSTALLED IN NEW CEILINGS, CLEAN DIFFUSER OR GRILLE. FLEXIBLE DUCT CONNECTORS SHALL BE REPLACED.

LORD AECK SARGENT
A KATERRA COMPANY

© 2019 Lord Aeck Sargent, Inc. All rights reserved. This document is the property of Lord Aeck Sargent, Inc. and is to be returned upon demand. The information contained herein may not be used or divulged without the written permission of Lord Aeck Sargent.

Kramer Engineering Services, plc
5517 Cascade Dr.
Chapel Hill, NC 27514
TEL: (919) 933-3350
email: Donna@KESplc.com
Firm License: P-1099



REVISION

SHEET KEYED NOTES

- 1 WORK IN THIS ROOM IS LIMITED TO REBALANCE OF SUPPLY AND EXHAUST. MEASURE AND RECORD SUPPLY AND EXHAUST AT PROJECT START TO ESTABLISH EXISTING BASELINE AIRFLOW. SUBMIT RESULTS TO ENGINEER.
- 2 REMOVE AND REINSTALL THERMOSTAT IN NEW LOCATION TO ACCOMMODATE NEW DOOR OPERATOR.
- 3 EXISTING DEDICATED EXHAUST RISER AND FAN SHALL BE RE-PURPOSED FOR NEW FUME HOOD. REFER TO NEW WORK PLAN.
- 4 REMOVE DIFFUSERS AND GRILLES IN THIS ROOM. REMOVE AND REPLACE FLEXIBLE DUCT CONNECTOR TO DIFFUSER. REMOVE EXHAUST DUCT BACK TO A POINT WHERE IT MAY BE EXTENDED TO NEW EXHAUST GRILLE.
- 5 EXISTING FUME HOOD TO REMAIN. EACH FUME HOOD IS PROVIDED WITH A DEDICATED EXHAUST FAN LOCATED ON THE ROOF. REFER TO SHEET M107 FOR FAN ID.
- 6 REMOVE DUCT BACK TO POINT INDICATED.


PARTITION AND WALL LEGEND

- 1-HOUR FIRE BARRIER
- 2-HOUR FIRE BARRIER

UNC SCHOOL OF MEDICINE
NEUROSCIENCES RESEARCH BUILDING
7th & 8th FLOORS FOR DERMATOLOGY

ISSUE DATE: 09/25/2019
JOB NO: 10761-00
DWG. NO: MD107

SEAL
DONNA Q. KRAMER
ENGINEER

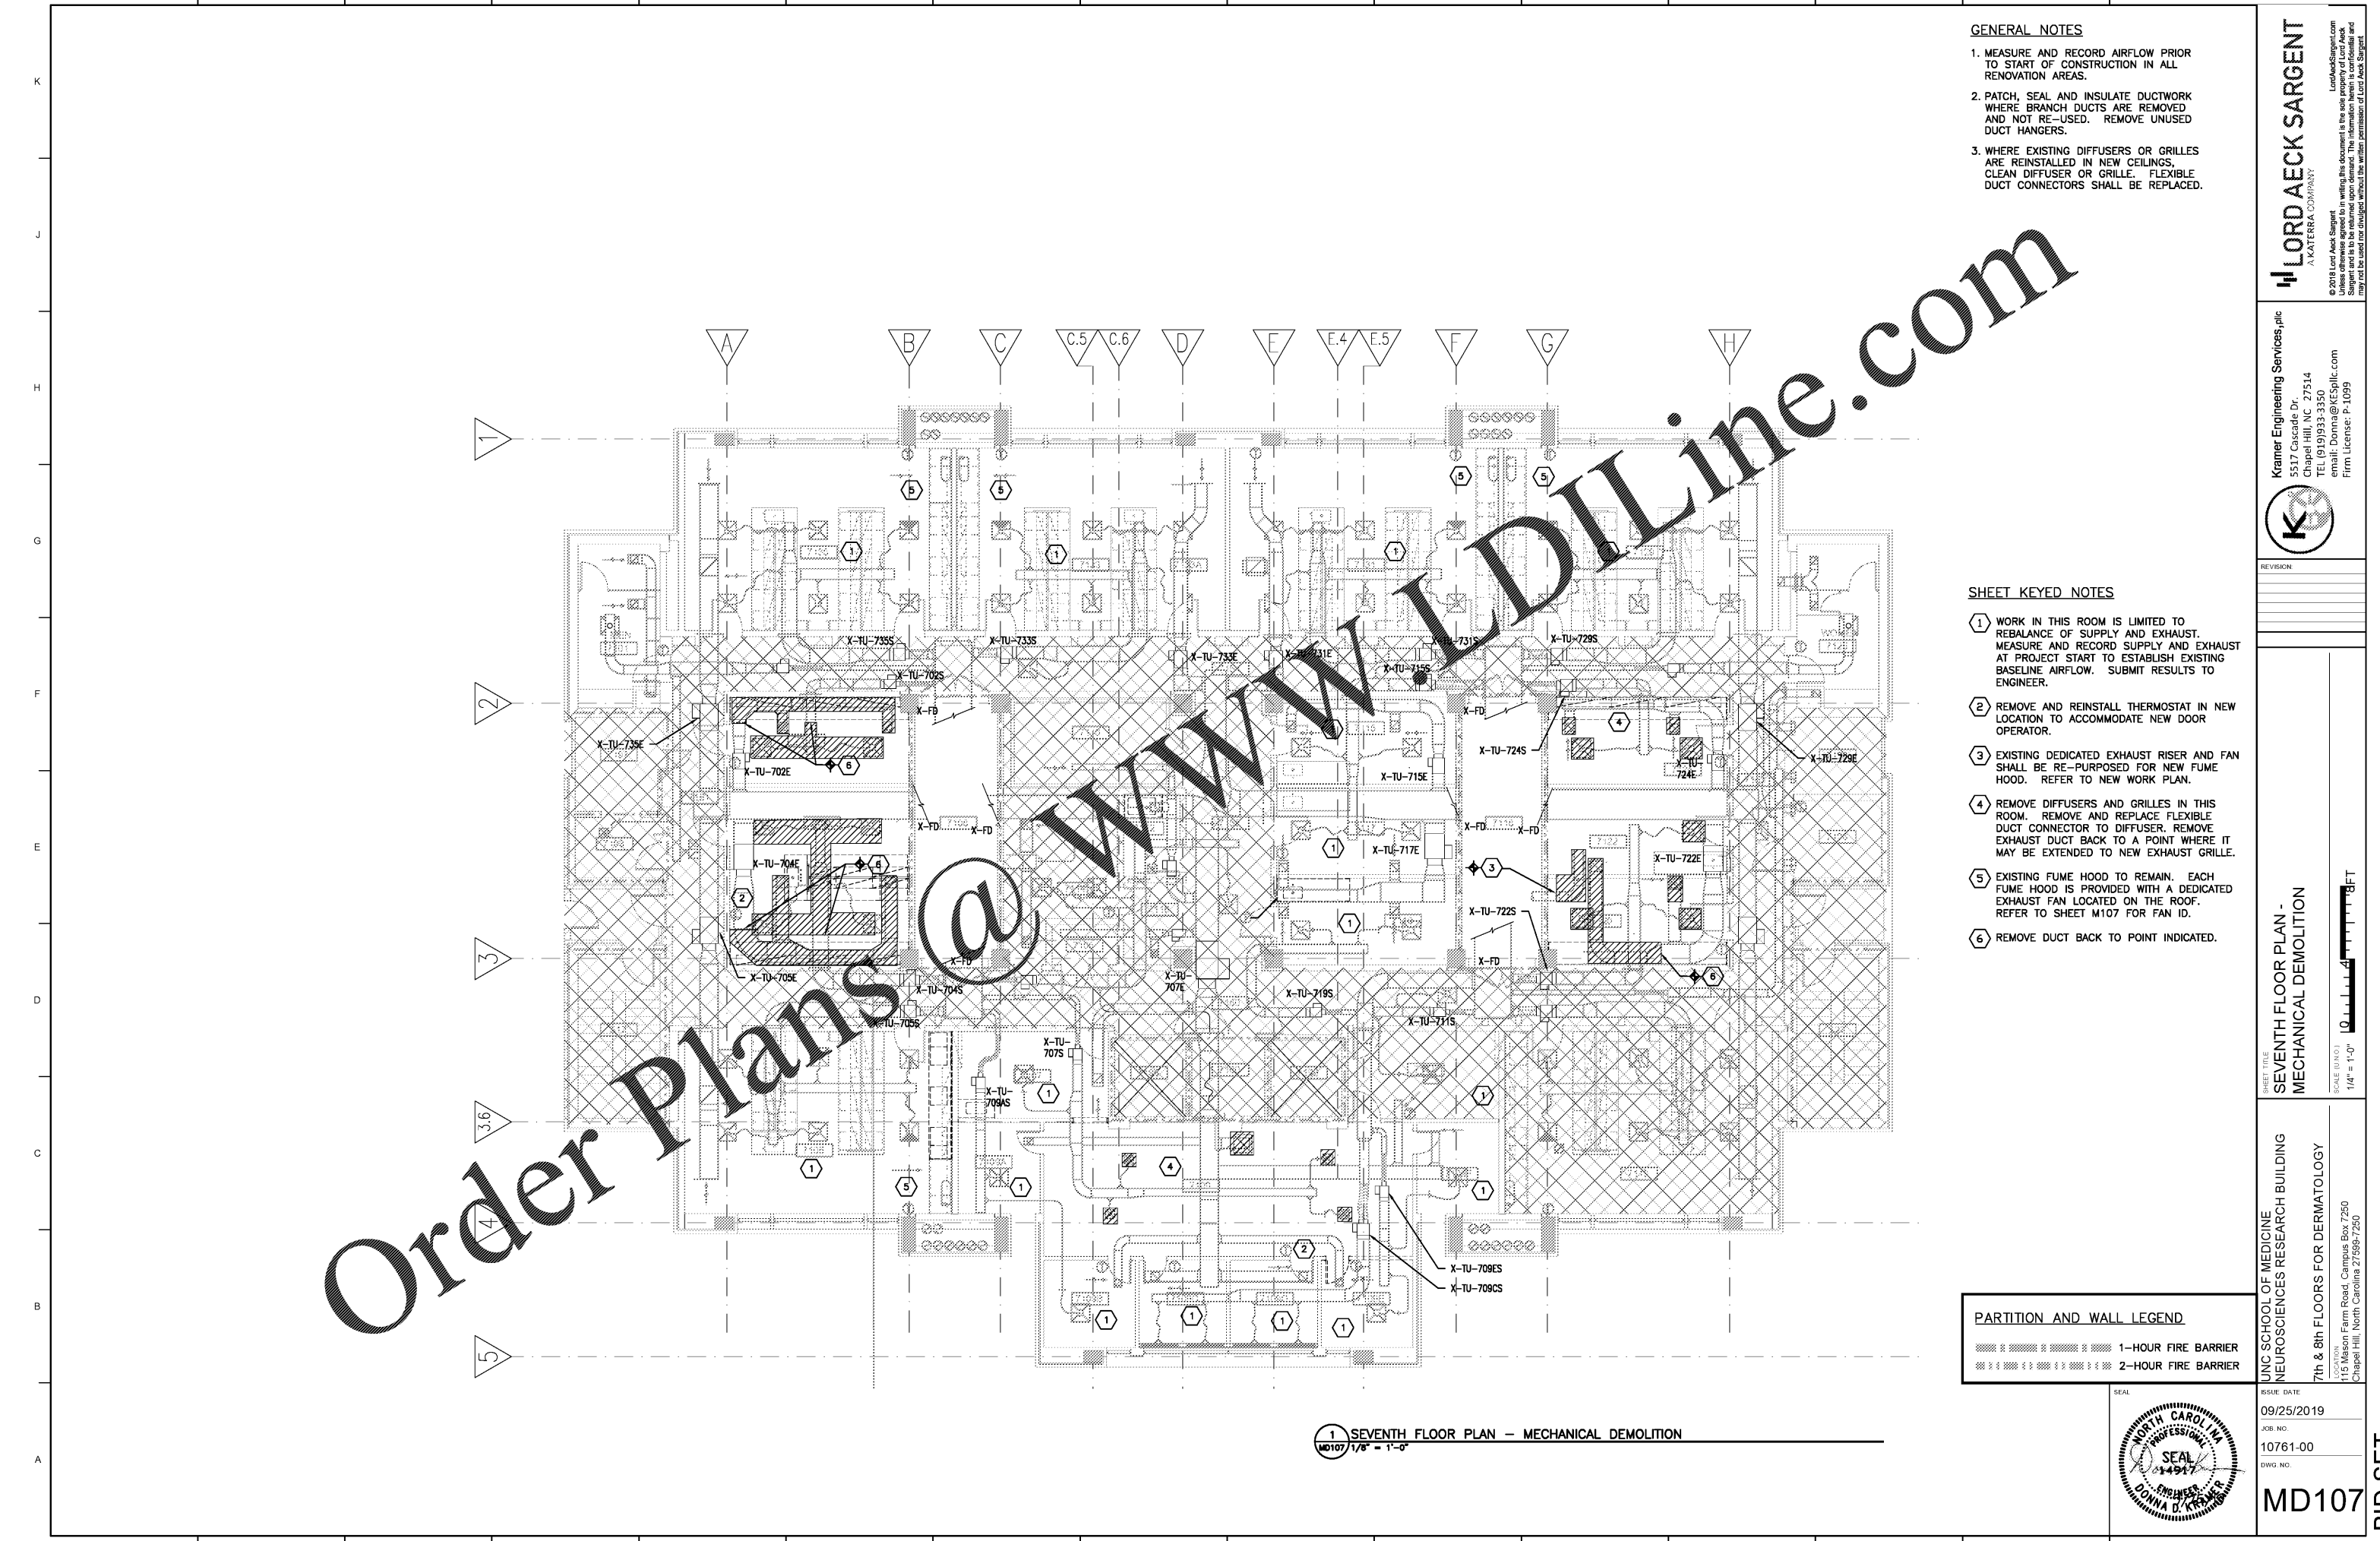

Order Plans @ WWW.DIline.com

1 SEVENTH FLOOR PLAN - MECHANICAL DEMOLITION
MD107 1/8" = 1'-0"

BID SET