

STIPULATION FOR REUSE
 THIS DRAWING WAS PREPARED FOR MICCO, INC. AND IS NOT TO BE REPRODUCED, COPIED, REPRODUCED, OR TRANSMITTED IN ANY FORM OR BY ANY MEANS, ELECTRONIC OR MECHANICAL, INCLUDING PHOTOCOPYING, RECORDING, OR BY ANY INFORMATION STORAGE AND RETRIEVAL SYSTEM. WITHOUT THE WRITTEN PERMISSION OF MICCO, INC. ANY REUSE OF THIS DRAWING FOR ANY PROJECT OTHER THAN THAT SPECIFICALLY AUTHORIZED BY MICCO, INC. IS STRICTLY PROHIBITED. THE ENGINEER'S RESPONSIBILITY IS LIMITED TO THE PROJECT AND THIS DRAWING. THE ENGINEER DOES NOT WARRANT THE ACCURACY OF THIS DRAWING OR THE RESULTS OF ANY PROJECT. THE USER OF THIS DRAWING SHALL BE RESPONSIBLE FOR OBTAINING ALL NECESSARY PERMITS AND FOR OBTAINING ALL NECESSARY INFORMATION FROM THE PROJECT OWNER AND ALL OTHER PROJECT PARTICIPANTS. THE USER OF THIS DRAWING SHALL BE RESPONSIBLE FOR OBTAINING ALL NECESSARY INFORMATION FROM THE PROJECT OWNER AND ALL OTHER PROJECT PARTICIPANTS. THE USER OF THIS DRAWING SHALL BE RESPONSIBLE FOR OBTAINING ALL NECESSARY INFORMATION FROM THE PROJECT OWNER AND ALL OTHER PROJECT PARTICIPANTS.


Cumberland
 Store Number: 9747
 8090 US 1
 Micco, FL 32976
 JOB NUMBER: 41-17-00190

ISSUE BLOCK


CLIENT REVIEW	08/30/19
100%	09/27/19

CHECKED BY: BRT
 DRAWN BY: BRT

PLUMBING SANITARY PLAN

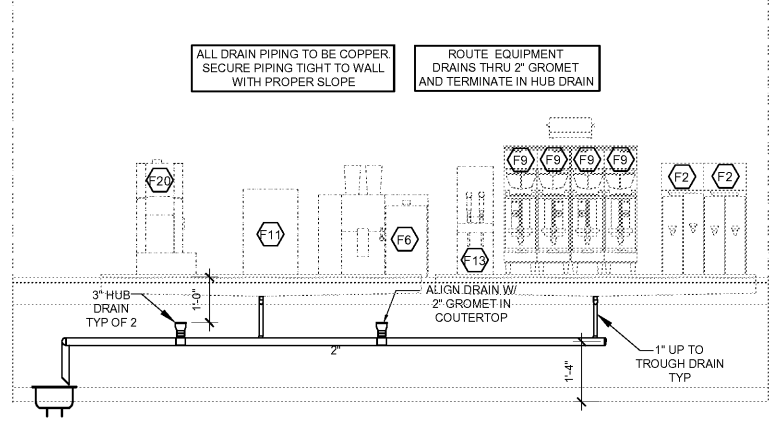

2 EQUIPMENT DRAIN ELEVATION
 SCALE: N.T.S.

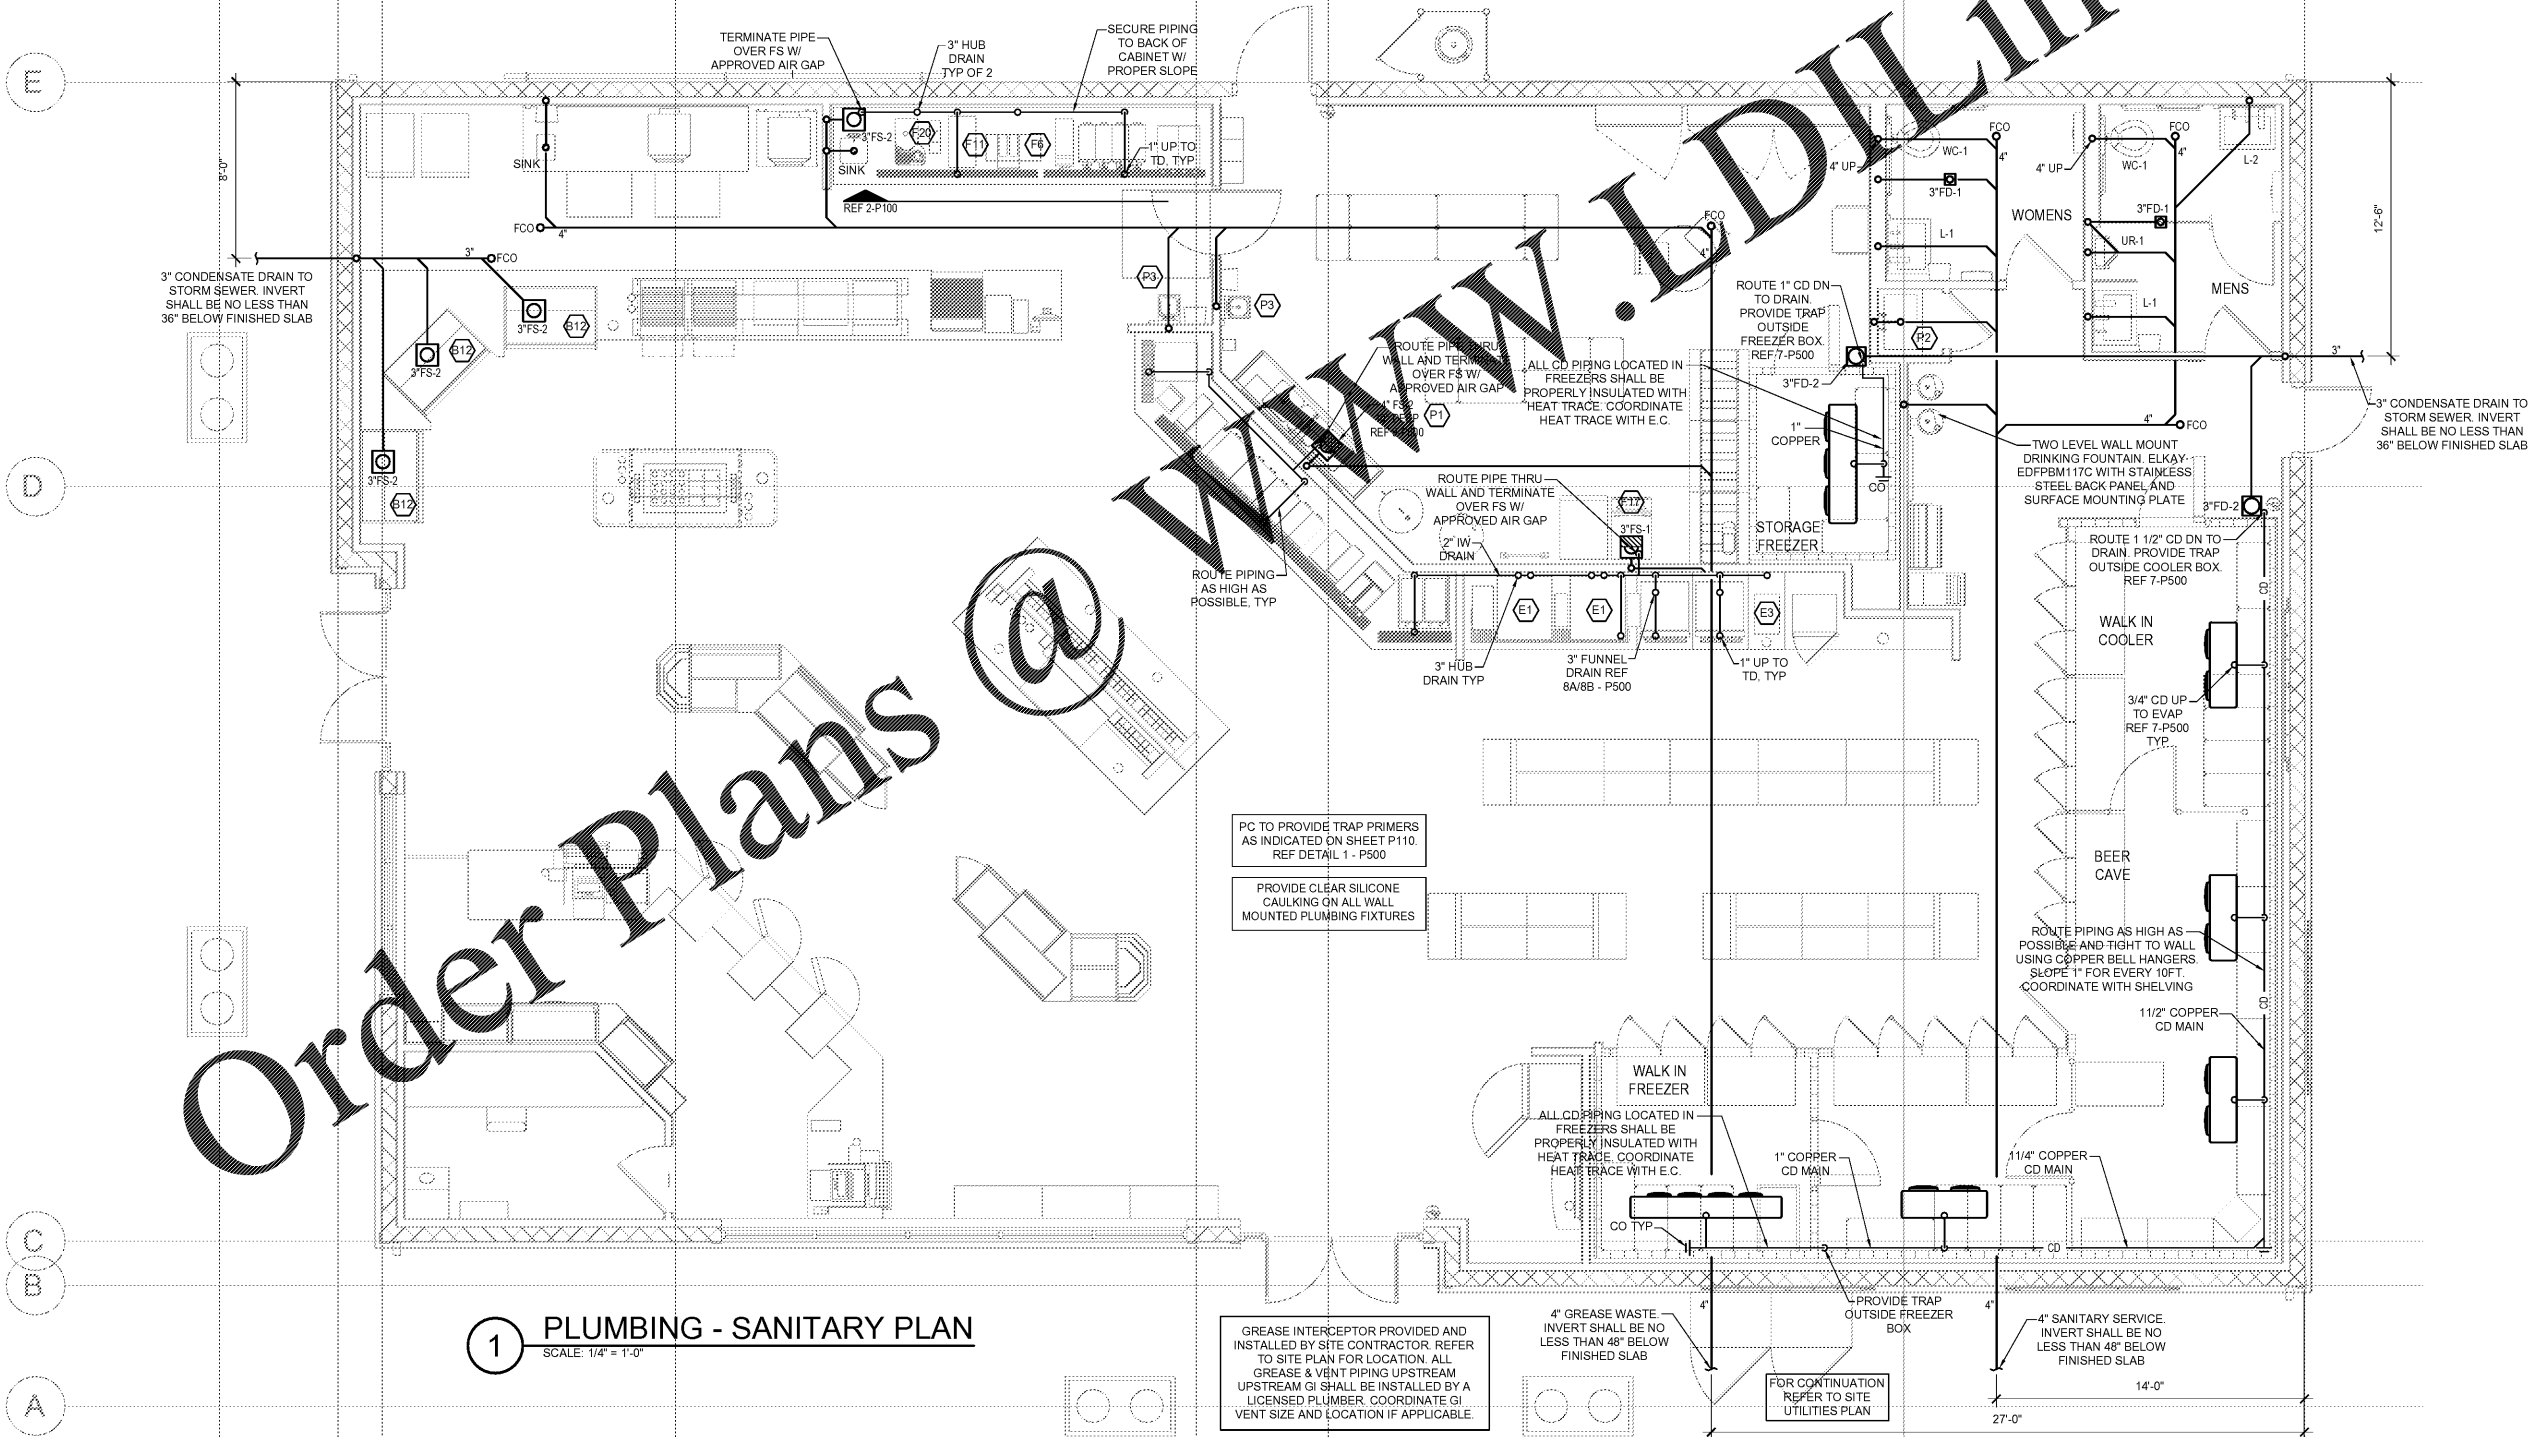

1 PLUMBING - SANITARY PLAN
 SCALE: 1/4" = 1'-0"

GREASE INTERCEPTOR PROVIDED AND INSTALLED BY SITE CONTRACTOR. REFER TO SITE PLAN FOR LOCATION. ALL GREASE & VENT PIPING UPSTREAM UPSTREAM GI SHALL BE INSTALLED BY A LICENSED PLUMBER. COORDINATE GI VENT SIZE AND LOCATION IF APPLICABLE.

PC TO PROVIDE TRAP PRIMERS AS INDICATED ON SHEET P110. REF DETAIL 1 - P500

PROVIDE CLEAR SILICONE CAULKING ON ALL WALL MOUNTED PLUMBING FIXTURES

ROUTE PIPING AS HIGH AS POSSIBLE AND TIGHT TO WALL USING COPPER BELL HANGERS. SLOPE 1" FOR EVERY 10FT. COORDINATE WITH SHELVING

ALL CD PIPING LOCATED IN FREEZERS SHALL BE PROPERLY INSULATED WITH HEAT TRACE. COORDINATE HEAT TRACE WITH E.C.

4" GREASE WASTE. INVERT SHALL BE NO LESS THAN 48" BELOW FINISHED SLAB

4" SANITARY SERVICE. INVERT SHALL BE NO LESS THAN 48" BELOW FINISHED SLAB

Order Plans @

WWW.LDILine.com