

GENERAL NOTES

- E.C. TO PROVIDE LIQUID TIGHT FLEXIBLE CONDUIT BETWEEN DISCONNECT SWITCH AND ROOF TOP UNITS, 3 FEET MAXIMUM.
- E.C. TO COORDINATE WITH THE MECHANICAL CONTRACTOR THE FINAL LOCATIONS FOR ALL ROOF TOP UNITS PRIOR TO ANY ROUGH-IN WORK IS PERFORMED.

HFA
HARRISON FRENCH & ASSOCIATES, LTD.
+479.273.7780
1705 S. Walton Blvd, Suite 3
Bentonville, Arkansas 72712
www.hfa-ac.com

STIPULATION FOR REUSE
USE ON ANY PROJECT AS A REFERENCE ONLY. THIS DOCUMENT IS THE PROPERTY OF HARRISON FRENCH & ASSOCIATES, LTD. AND IS NOT TO BE REPRODUCED OR TRANSMITTED IN ANY FORM OR BY ANY MEANS, ELECTRONIC OR MECHANICAL, INCLUDING PHOTOCOPYING, RECORDING, OR BY ANY INFORMATION STORAGE AND RETRIEVAL SYSTEM, WITHOUT THE WRITTEN PERMISSION OF HARRISON FRENCH & ASSOCIATES, LTD. THIS DOCUMENT IS THE PROPERTY OF HARRISON FRENCH & ASSOCIATES, LTD. AND IS NOT TO BE REPRODUCED OR TRANSMITTED IN ANY FORM OR BY ANY MEANS, ELECTRONIC OR MECHANICAL, INCLUDING PHOTOCOPYING, RECORDING, OR BY ANY INFORMATION STORAGE AND RETRIEVAL SYSTEM, WITHOUT THE WRITTEN PERMISSION OF HARRISON FRENCH & ASSOCIATES, LTD.


Kimberland
Store Number: 9747
8090 US1 & MICCO ROAD
MICCO, FL
JOB NUMBER: 41-17-2019B

ISSUE BLOCK		
1	CLIENT REVIEW	08/30/19
2	100%	09/27/19

CHECKED BY:	JAC
DRAWN BY:	JLB
DOCUMENT DATE:	

ELECTRICAL
ROOF PLAN

SHEET:
E140

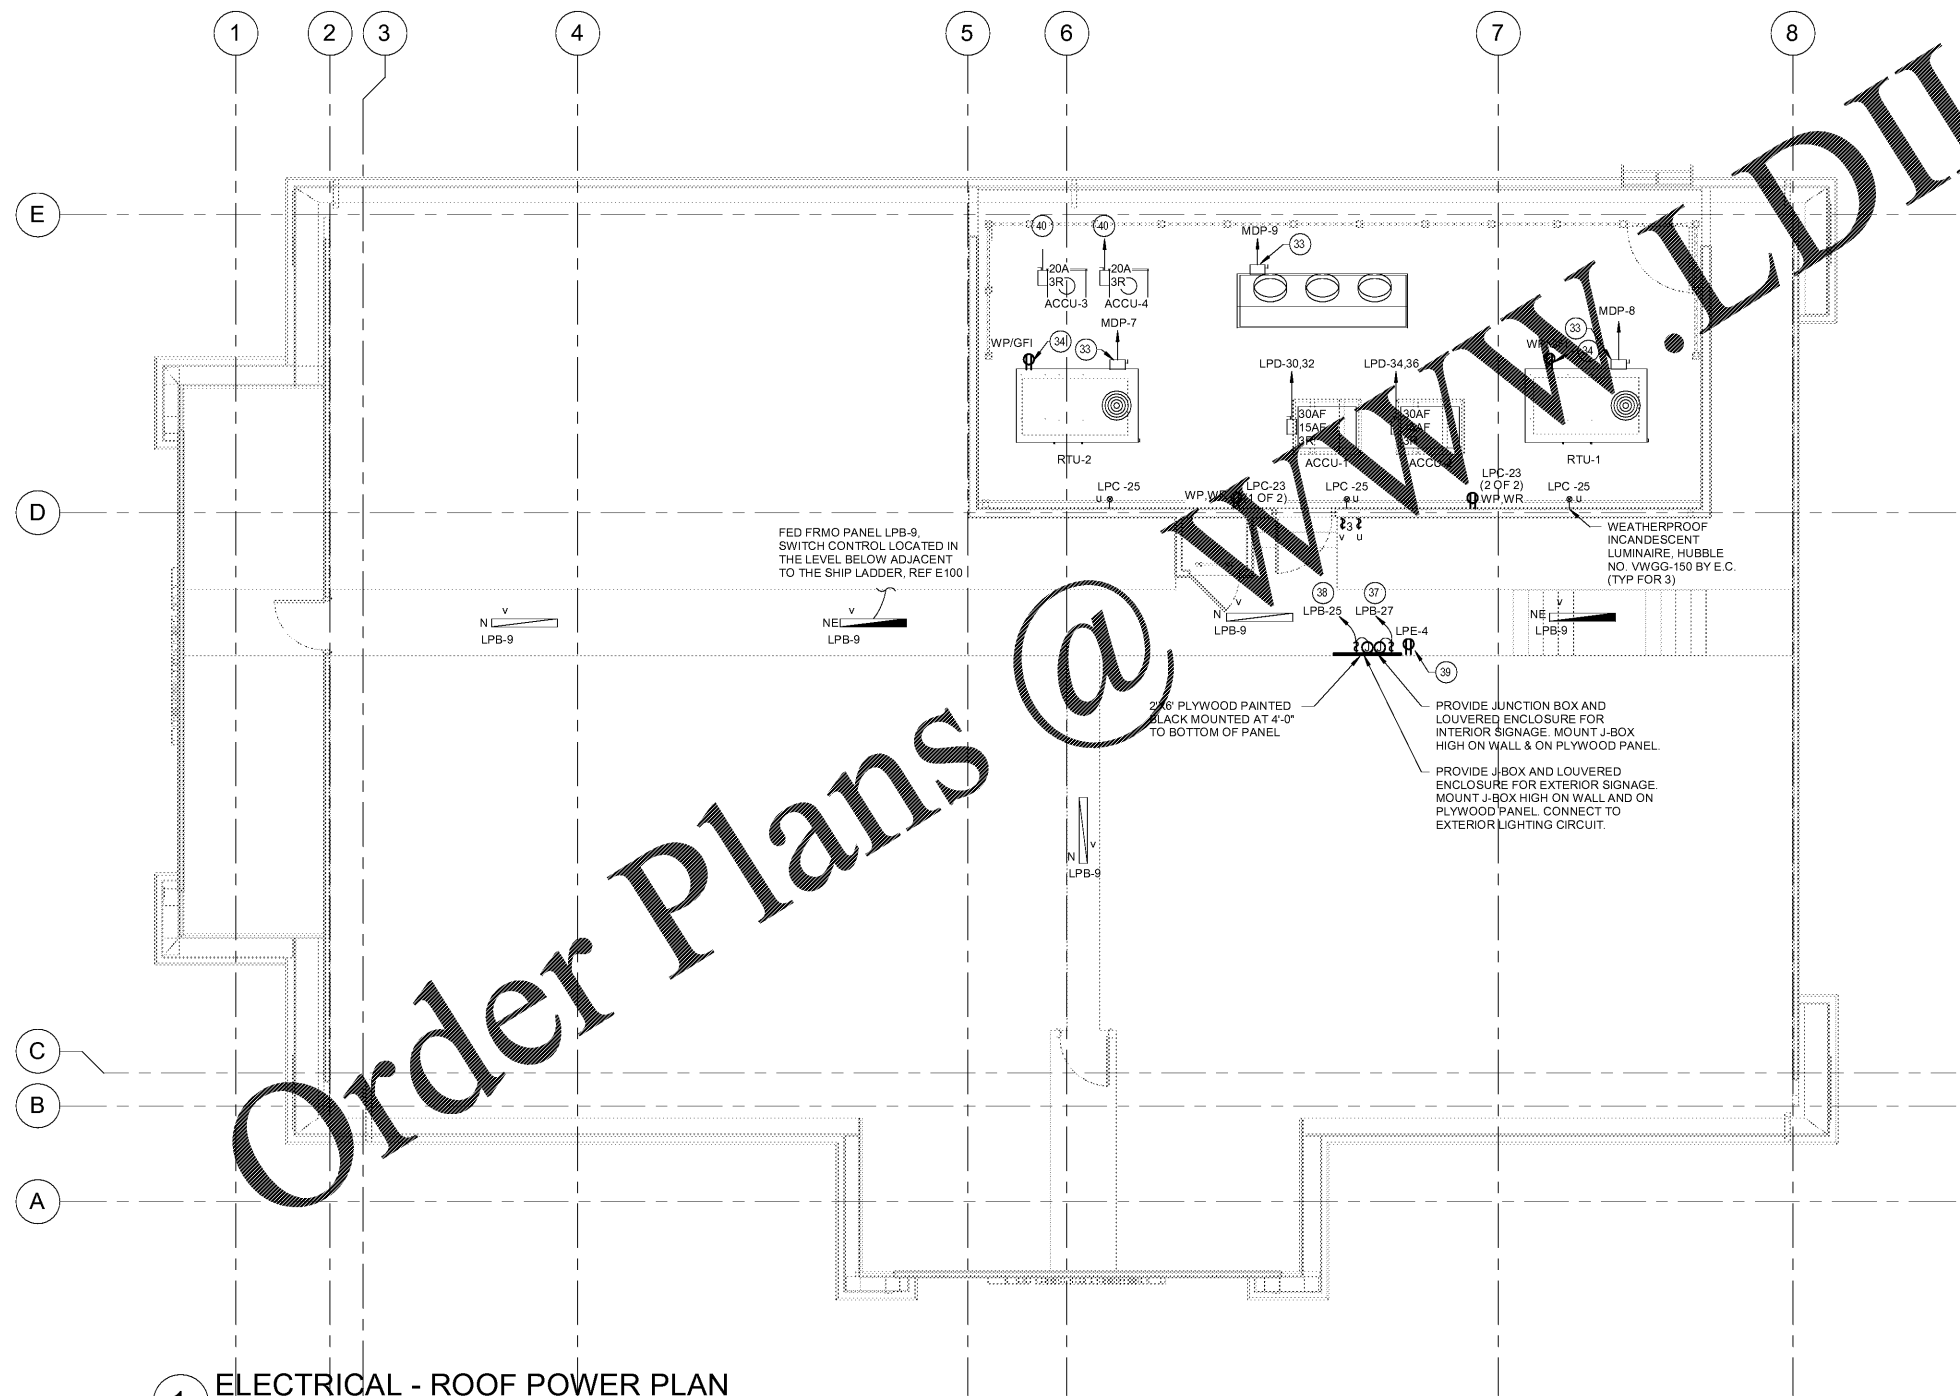

1 ELECTRICAL - ROOF POWER PLAN
3/16" = 1'-0"

9/20/2019 1:20:58 PM
 C:\Users\jacob\OneDrive\Documents\2019 Roof Plans\41-17-2019B_Mico_FL_A144 (E.C.)_Roof Power Plan.dwg
 Plot: 41-17-2019B_Electrical_Roof Power Plan.dwg

Order Plans @ www.LDILine.com