


STIPULATION FOR REUSE
THIS DOCUMENT IS THE PROPERTY OF HARRISON FRENCH & ASSOCIATES, LTD. (HFA). IT IS TO BE USED ONLY FOR THE PROJECT AND SITE SPECIFICALLY IDENTIFIED IN THE PROJECT TITLE. IT IS NOT TO BE REPRODUCED, COPIED, EITHER WHOLLY OR IN PART, FOR ANY OTHER PROJECT WITHOUT THE WRITTEN PERMISSION OF HFA. UNAUTHORIZED REUSE OF THIS DOCUMENT FOR ANY OTHER PROJECT IS STRICTLY PROHIBITED AND MAY BE CONSIDERED AS A VIOLATION OF APPLICABLE LAW.

Cumberland
Store Number: 9747
8090 US1 & MICCO ROAD
MICCO, FL
JOB NUMBER: 41-17-2019B


ISSUE BLOCK		
1	CLIENT REVIEW	08/30/19
2	100%	09/27/19

CHECKED BY: JAC
DRAWN BY: JLB
DOCUMENT DATE:


ELECTRICAL DETAILS

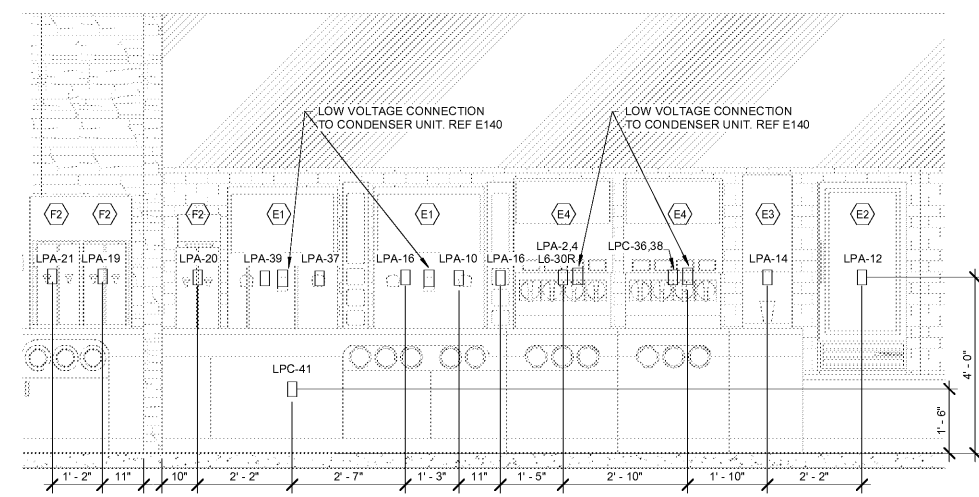


1 CHILL ZONE ELEVATION
1/2" = 1'-0"

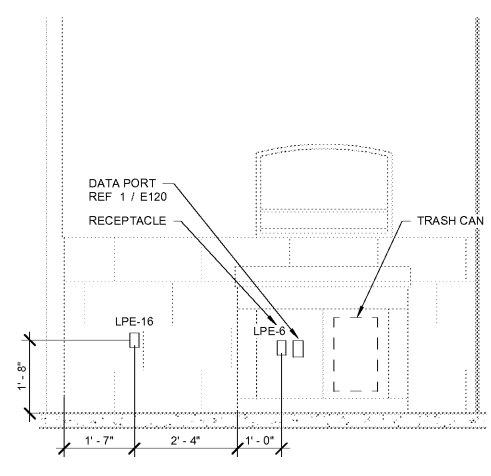


2 LOTTERY STATION ELEVATION
1/2" = 1'-0"

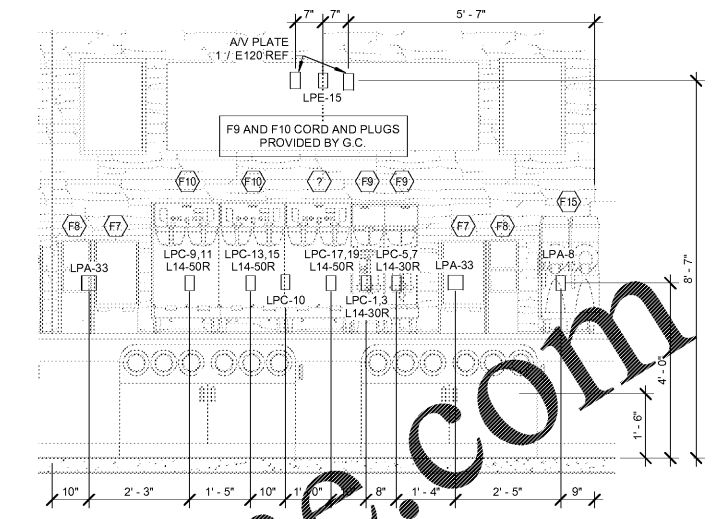


3 COFFEE BAR ELEVATION
1/2" = 1'-0"

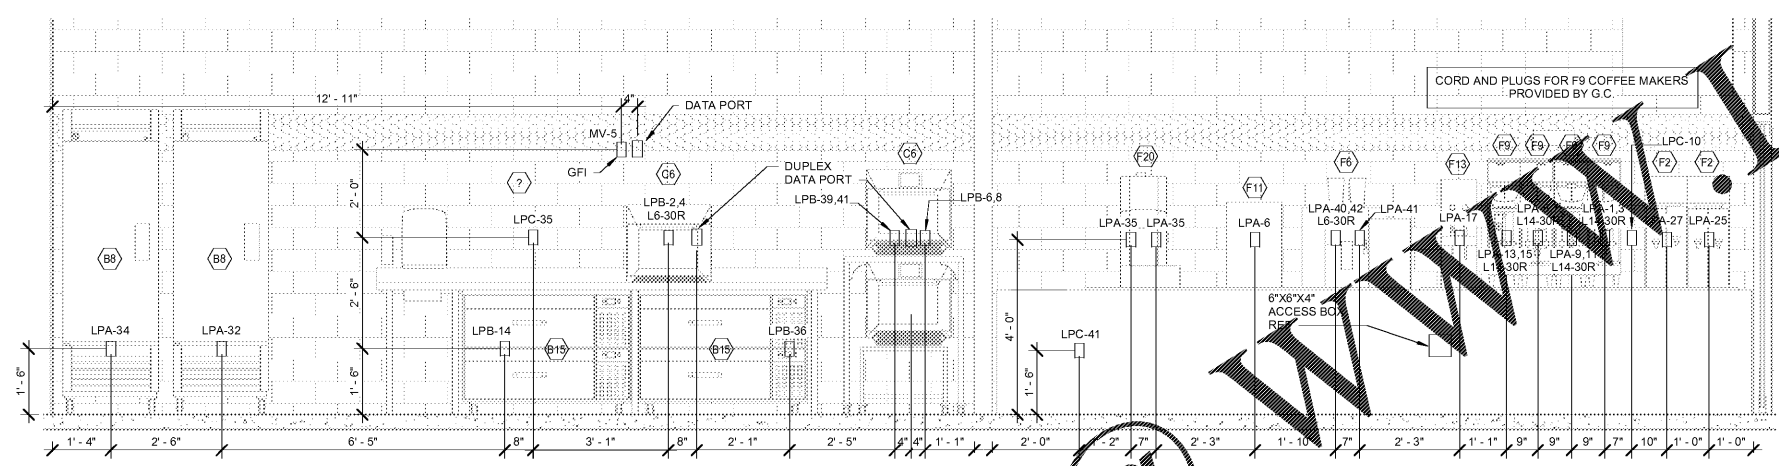


4 FOOD PREP ELEVATION
1/2" = 1'-0"

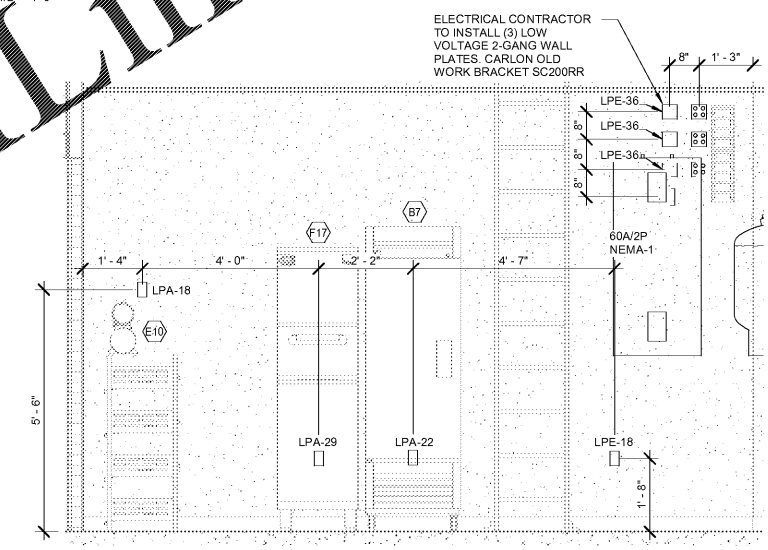


5 DIGITAL MENU BOARD CONTROLLERS
1/2" = 1'-0"

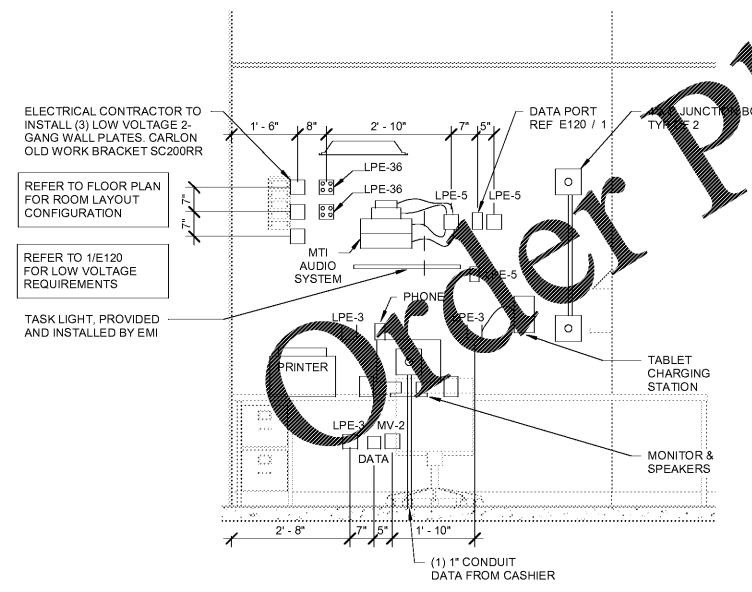

6 MANAGERS OFFICE
1/2" = 1'-0"

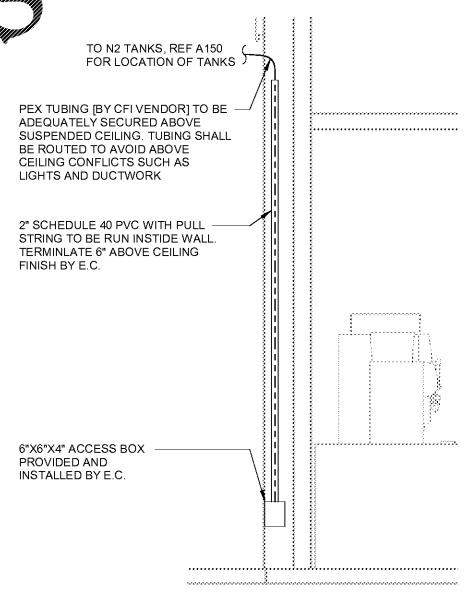

7 N2 TANK LINE CONDUIT ROUTING
1/2" = 1'-0"

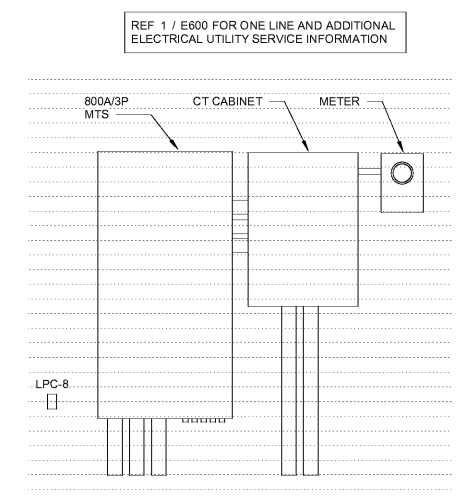

8 ELECTRICAL SERVICE
1/2" = 1'-0"

09/23/2019 12:31:05 PM
 C:\Users\jacob.donovan\Documents\2019 Rev\Projects\17-0919_Mico_FL_Arks\17-Elec_Micro_FL_Elec_JLB.dwg
 1705 S. WALTON BLVD, SUITE 3, BENTONVILLE, ARKANSAS 72712
 WWW.HFA-AC.COM