



Order Plans @ [www.dlline.com](http://www.dlline.com)

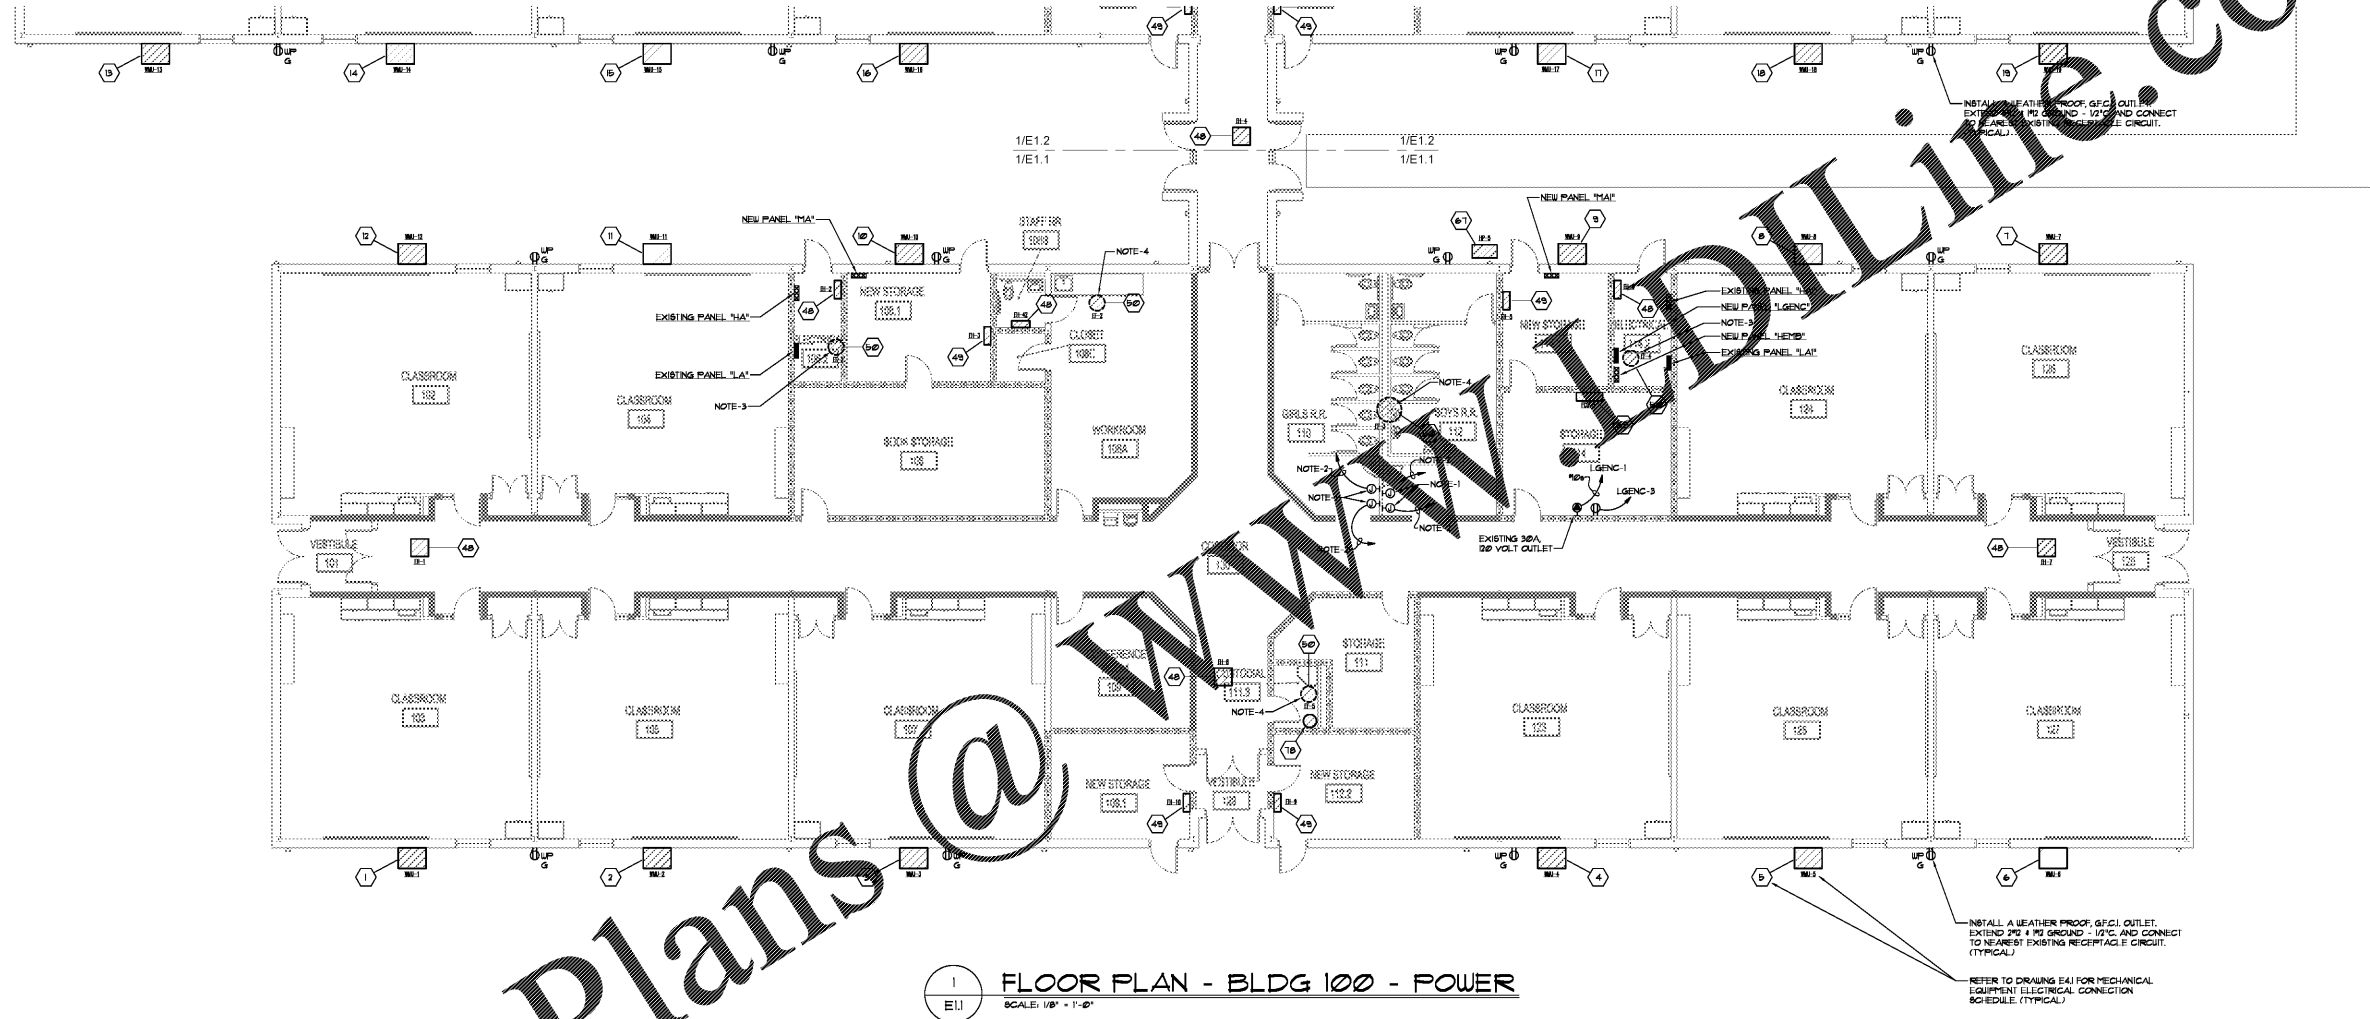

**FLOOR PLAN - BLDG 100 - POWER**  
SCALE: 1/8" = 1'-0"

**ELECTRICAL NOTES**

1. INSTALL JUNCTION BOX TO ACCOMMODATE WALL MOUNTED HAND DRYER. COORDINATE EXACT LOCATION AND MOUNTING HEIGHT WITH ARCHITECT. FURNISH AND INSTALL A 1/2" XL-BU HAND DRYER.
2. EXTEND 20A 100V GROUND - 100V AND CONNECT TO A NEW 20A/100V GFCI TYPE BREAKER IN NEAREST EXISTING 600V/250V PANELBOARD. NEW BREAKER SHALL BE OF SAME MANUFACTURER AS EXISTING PANEL AND MATCH AIC RATING OF EXISTING BREAKERS. PROPERLY UPDATE PANEL DIRECTORY.
3. INSTALL A NEW LINE VOLTAGE T-BIT FURNISHED BY DIVISION 23.
4. INSTALL A RELAY TO ALLOW 20VOLT PAN TO BE CONTROLLED BY 211 VOLT CORRIDOR LIGHTING. PAN SHALL ENERGIZE WHEN NON-EMERGENCY CORRIDOR LIGHTS ARE ENERGIZED.

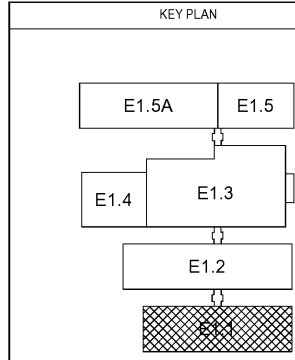

NO	DESCRIPTION	DATE