



#	KEYNOTE DESCRIPTION
L6	PROVIDE 0-10V CLASS 2 WIRING FROM ROOM CONTROLLER TO EACH FIXTURE IN THIS SPACE FOR DIMMING CONTROL. REFER TO WIRING DIAGRAM(S) ON DETAIL SHEETS.
L7	PROVIDE CONNECTION FROM POWER PACK AND/OR ROOM CONTROLLER TO FIRE ALARM SYSTEM CONTROL MODULE FOR OVERRIDE OF OCCUPANCY SENSOR(S) DURING AN ALARM EVENT.
L9	CONNECT EXTERIOR LIGHTING CIRCUIT THROUGH LIGHTING CONTACTOR. REFER TO EXTERIOR LIGHTING CONTROL SCHEMATIC.
L11	PROVIDE 0-10V CLASS 2 DIMMING CONDUCTORS FROM WALL SWITCH DIMMER TO EACH LIGHTING FIXTURE IN THIS SPACE FOR DIMMING CONTROL, ACCORDING TO ZONE DESIGNATION.
L13	CONNECT DISPLAY CASE LIGHTING TO LOAD SIDE OF OCCUPANCY SENSOR POWER PACK.

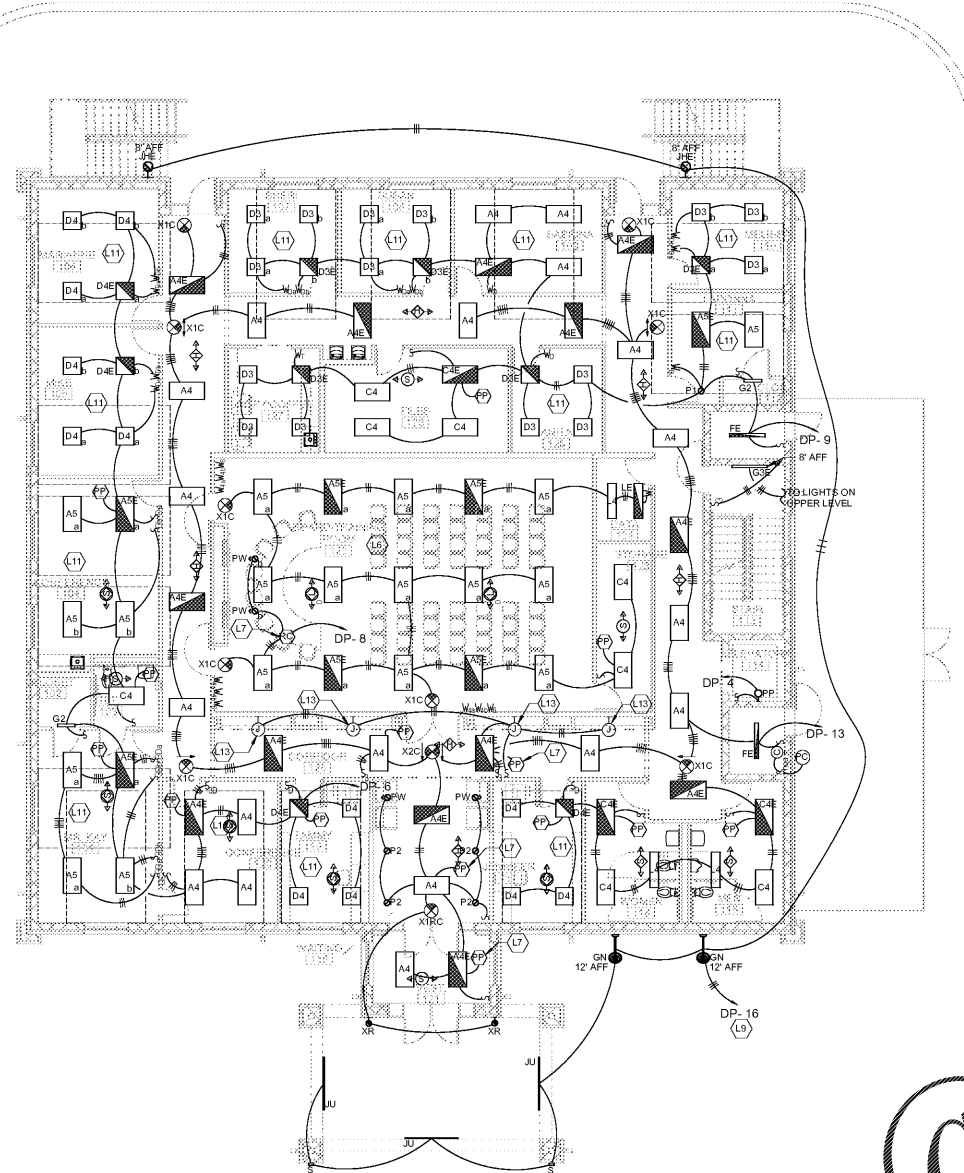

1 LEVEL 01 - LIGHTING PLAN  
1/8" = 1'-0"

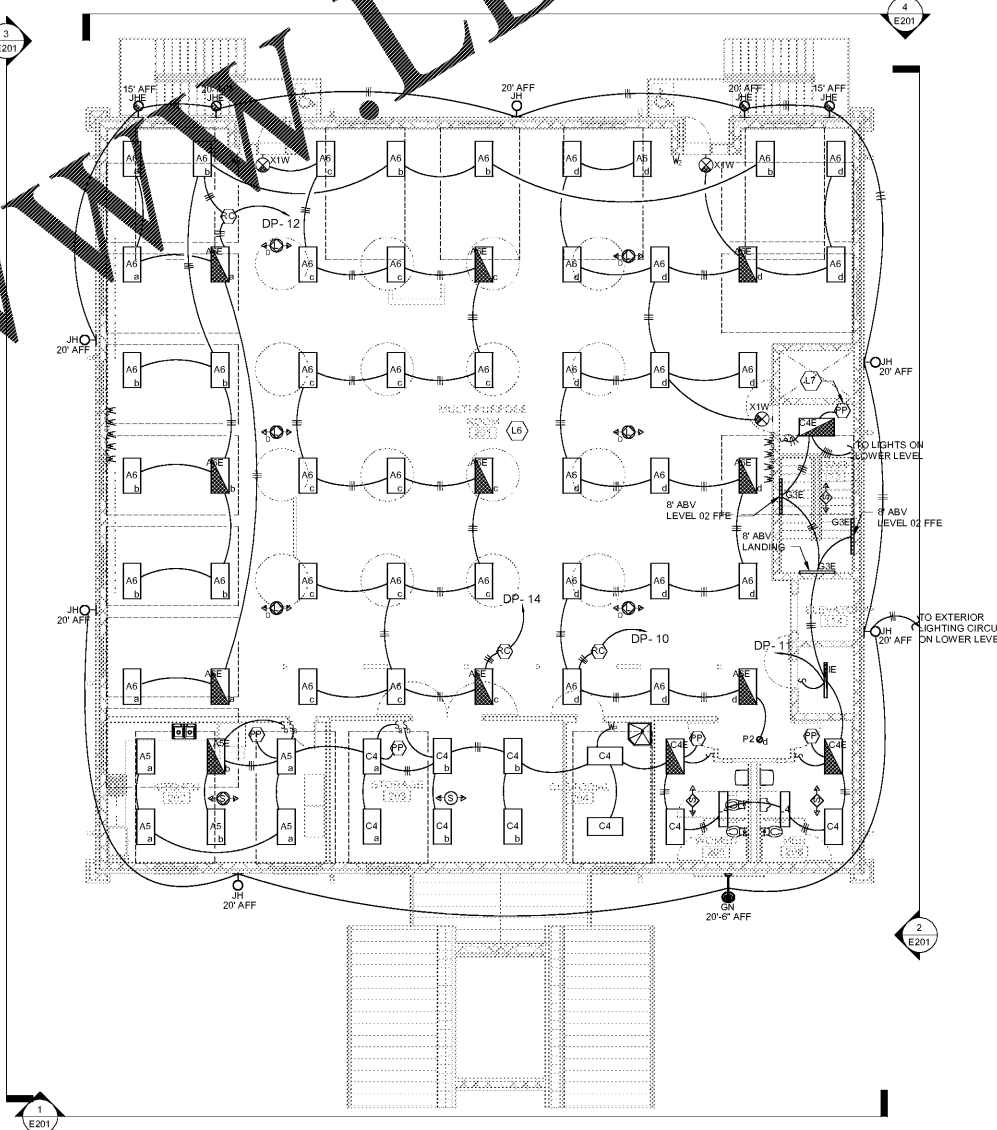

2 LEVEL 02 - LIGHTING PLAN  
1/8" = 1'-0"

Order Plans @ WWW.LDILine.com

WWW.LDILine.com

SA&E PROJECT NUMBER	01-615-057
BID PACKAGE / PHASING	BP-1
ISSUED FOR CONSTRUCTION	10/15/2019
<b>Southern AE</b> 7951 Truon Circle Austell, Ga 30168 (770) 519-7777 architects & engineers	REVISIONS
	R # Doc # Date
© COPYRIGHT 2019 BY SOUTHERN AE, LLC. ALL RIGHTS RESERVED. THIS DOCUMENT IS THE PROPERTY OF SOUTHERN AE, LLC AND SHALL NOT BE COPIED OR REPRODUCED IN WHOLE OR IN PART WITHOUT EXPRESS WRITTEN PERMISSION BY SOUTHERN AE, LLC.	

ADD ALTERNATE #1  
BOARD OF EDUCATION OFFICE FOR:  
**HEARD COUNTY SCHOOLS**  
4647 PEA RIDGE ROAD, FRANKLIN, GA 30217  
HEARD COUNTY SCHOOL SYSTEM  
FRANKLIN, GEORGIA

LIGHTING PLAN

DRAWING NUMBER  
**E101**