
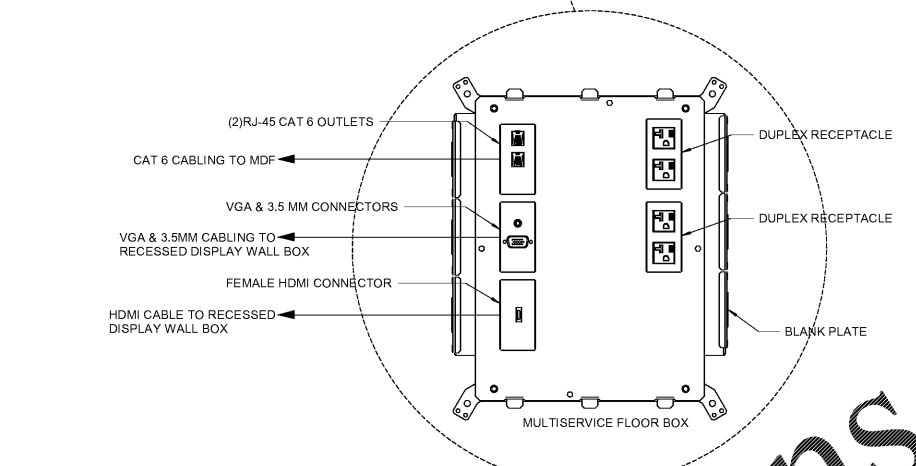



A
B
C
D
E
F
G
H
I
A
K
L
M
N

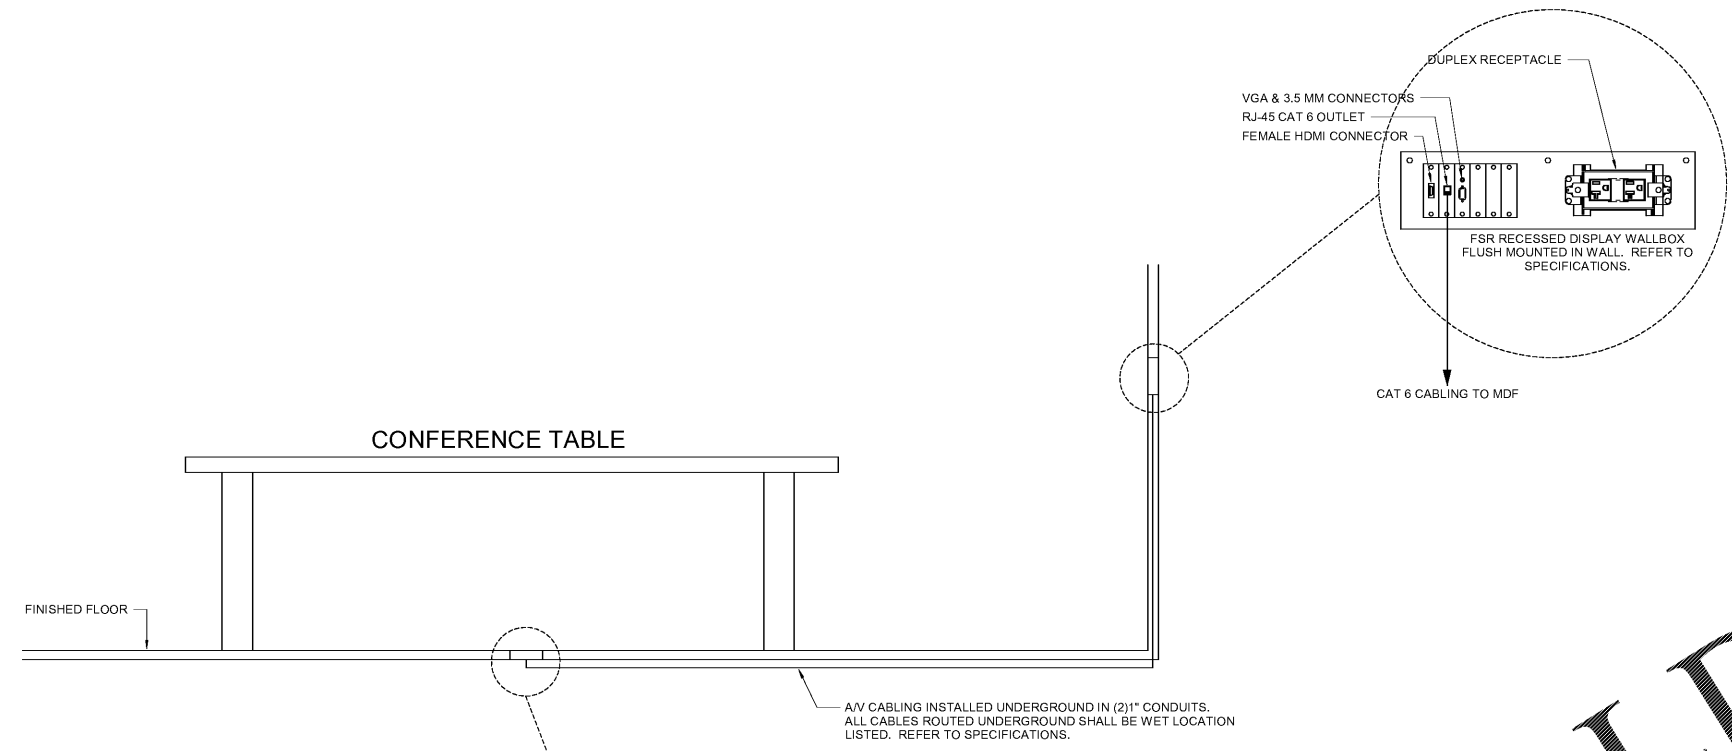

A/V CABLING INSTALLED UNDERGROUND IN (2)1" CONDUITS. ALL CABLES ROUTED UNDERGROUND SHALL BE WET LOCATION LISTED. REFER TO SPECIFICATIONS.

1 ONE-LINE DIAGRAM FOR CONFERENCE ROOM A/V
NO SCALE

 Order Plans @ www.LDILine.com



SA&E PROJECT NUMBER	01-615-057
BID PACKAGE / PHASING	BP-1
ISSUED FOR CONSTRUCTION	10/15/2019
Southern AE 7951 Troon Circle Austell, Ga 30168 (770) 819-7777 architects & engineers	REVISIONS
	R # Doc # Date
ADD ALTERNATE #1 BOARD OF EDUCATION OFFICE FOR: HEARD COUNTY SCHOOLS 4647 PEA RIDGE ROAD, FRANKLIN, GA 30217 HEARD COUNTY SCHOOL SYSTEM FRANKLIN, GEORGIA	
DETAILS	
	DRAWING NUMBER E507