


A  
B  
C  
D  
E  
F  
G  
H  
I  
A  
K  
L  
M  
N

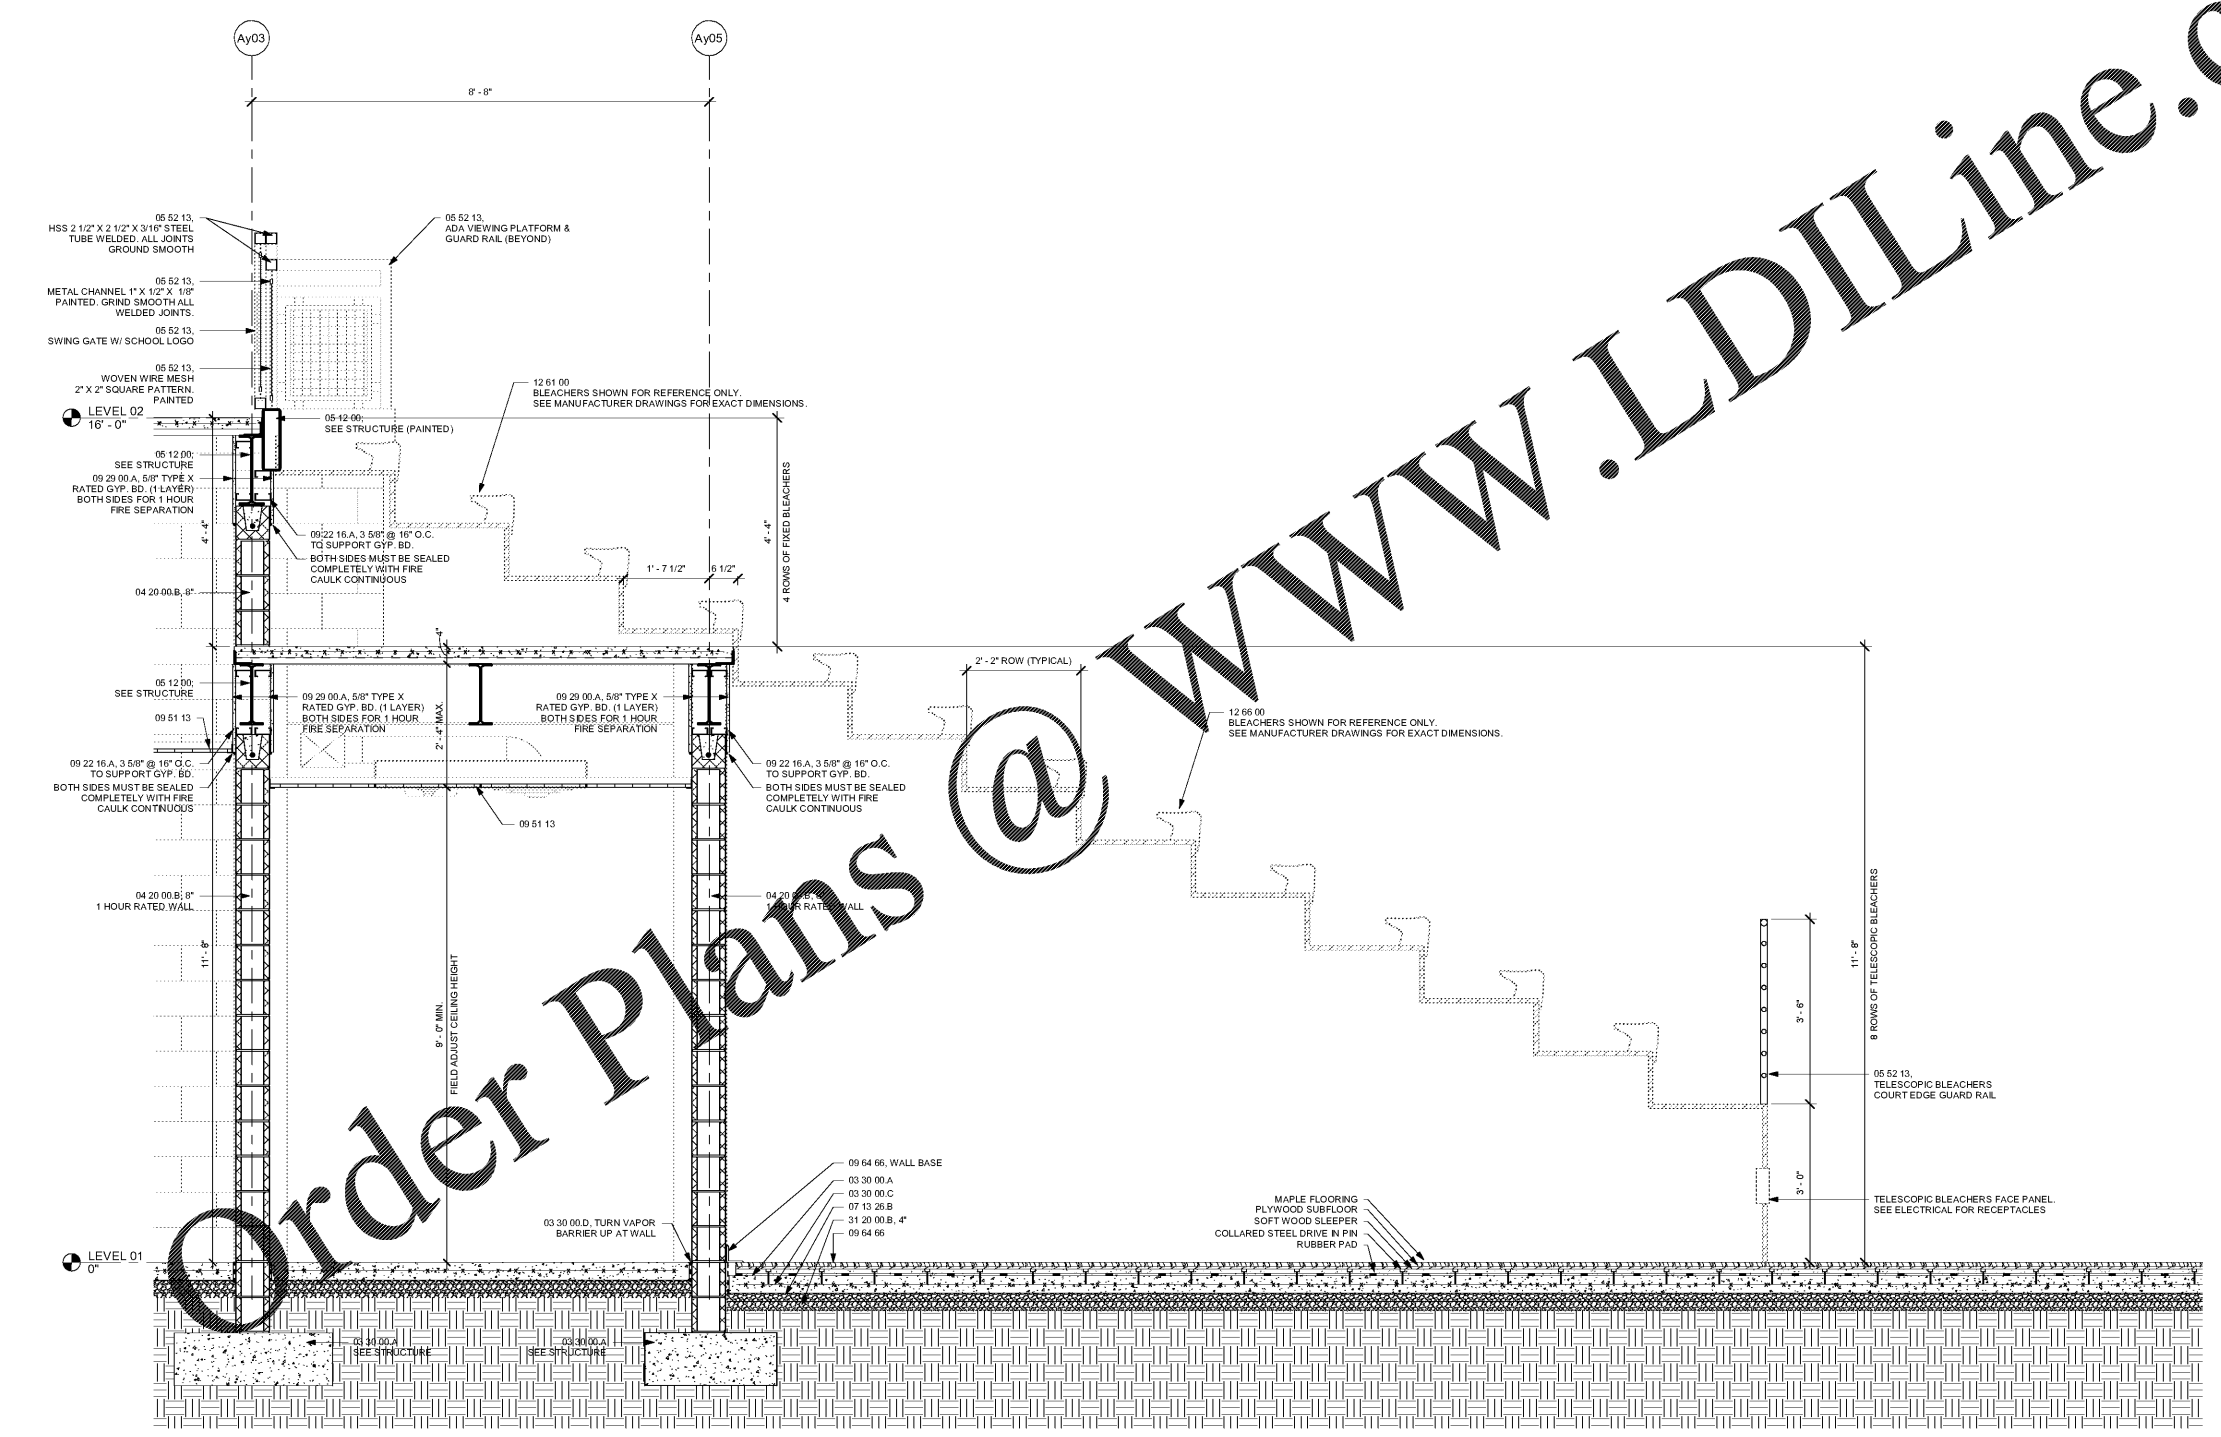

1 WALL SECTION - GYMNASIUM BLEACHERS - LOWER LEVEL  
3/4" = 1'-0"

WWW.LDILine.com

Order Plans @

SA&E PROJECT NUMBER	01-615-056
BID PACKAGE	BP-1
ISSUED FOR CONSTRUCTION	10/15/2019
<b>Southern AE</b> 7951 Tron Circle Austell, Ga 30168 (770) 819-7777 architects & engineers	REVISIONS
	R # Doc # Date
FACILITY CODE NUMBER: 674-0110 <b>GYMNASIUM/AUDITORIUM FOR:</b> <b>HEARD COUNTY SCHOOLS</b> 545 MAIN STREET, FRANKLIN, GA 30217 <b>HEARD COUNTY SCHOOL SYSTEM</b> FRANKLIN, GEORGIA	
GYMNASIUM BLEACHER DETAILS	
	DRAWING NUMBER
	A505