


A
B
C
D
E
F
G
H
I
A
K
L
M
N

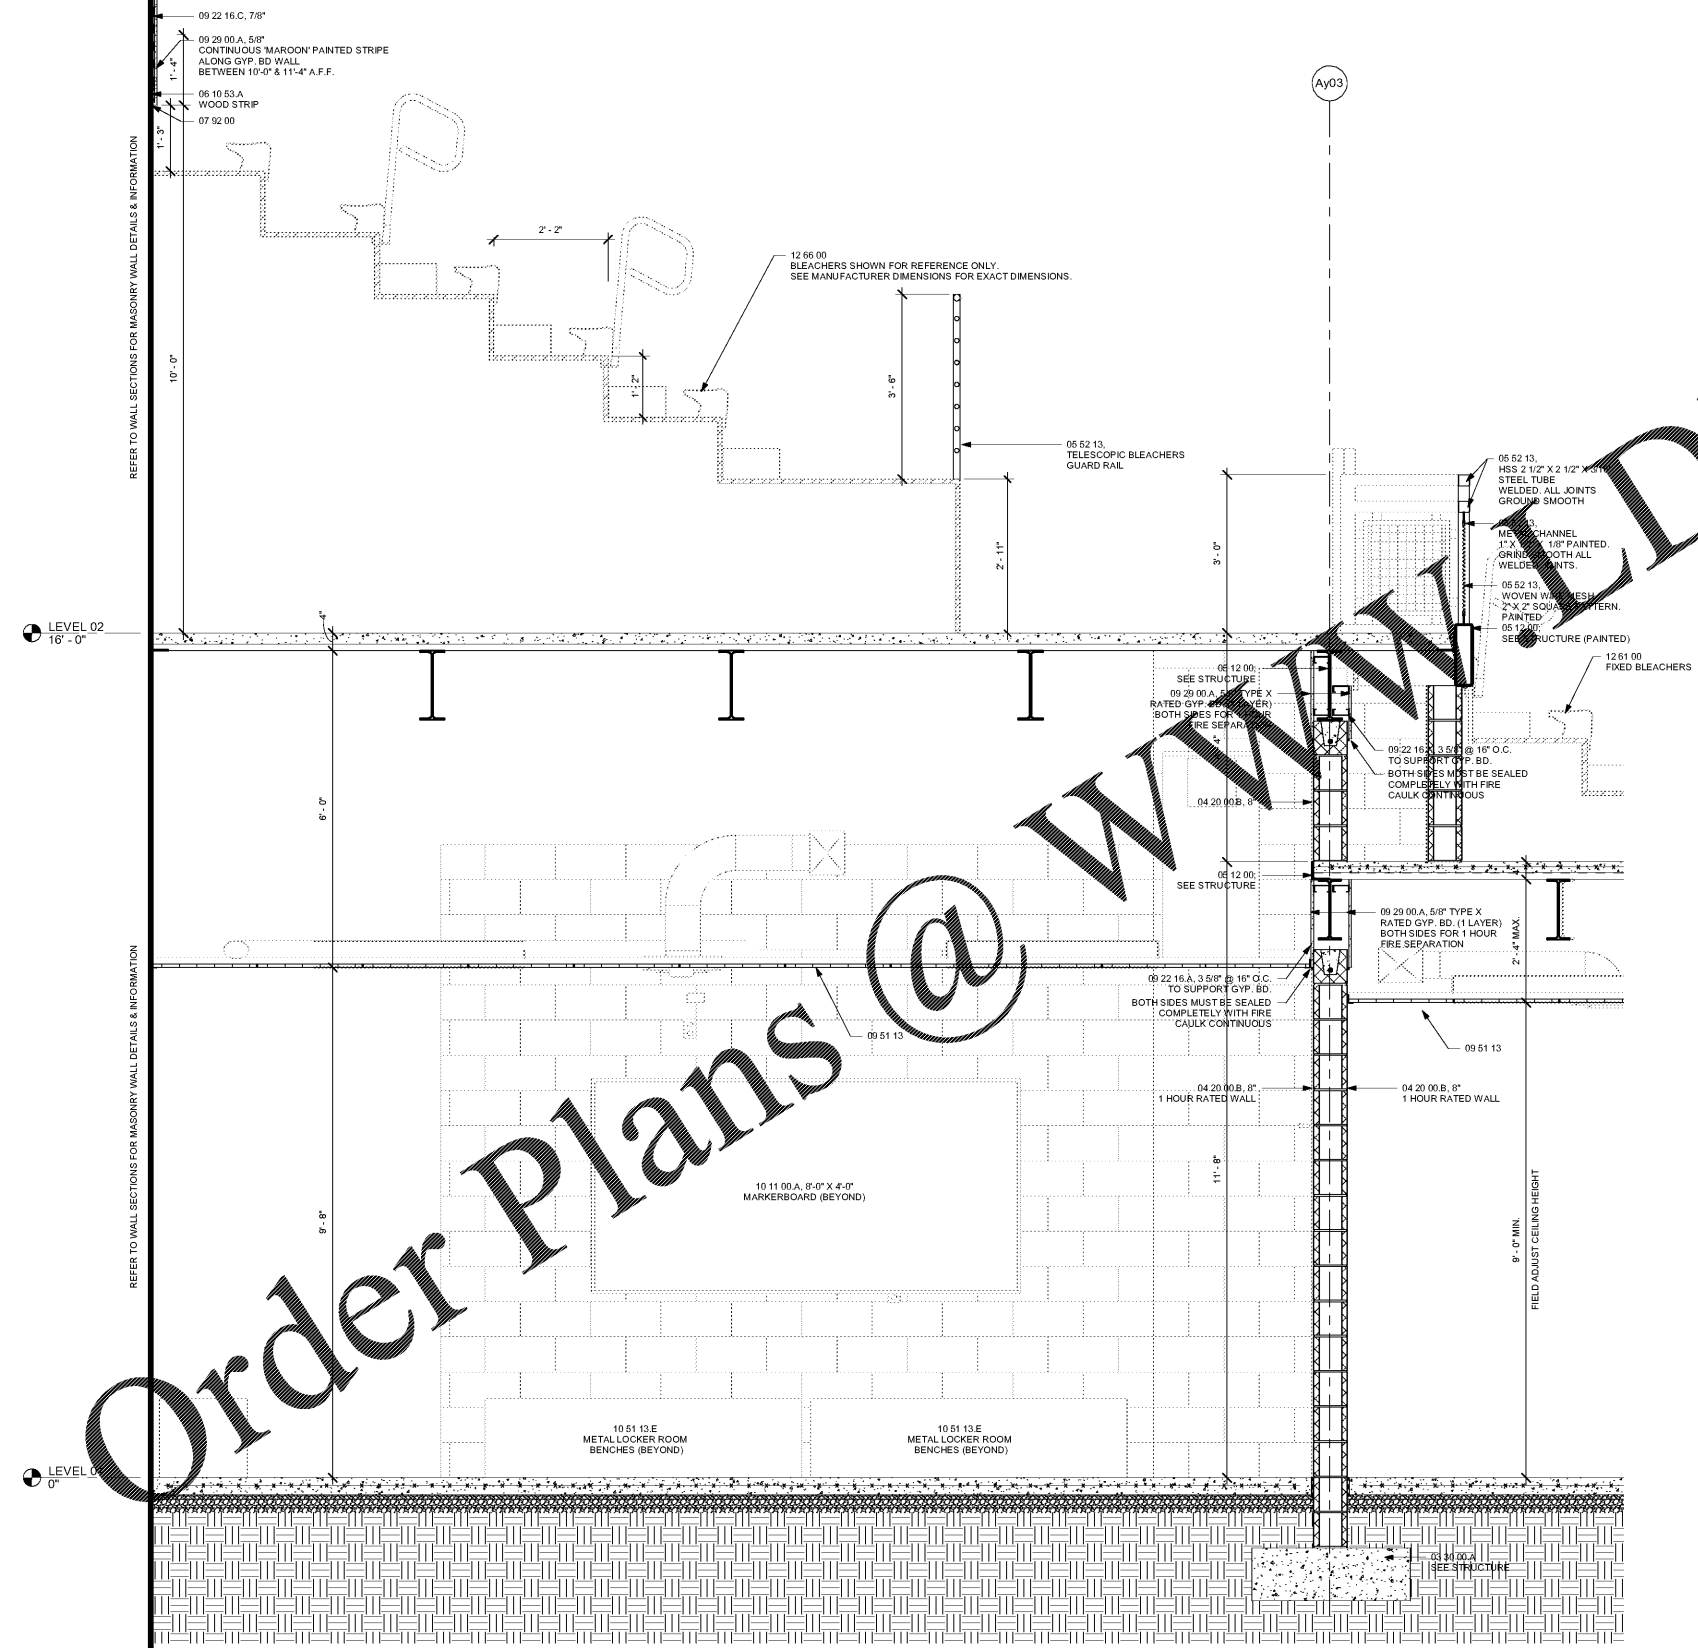

1 WALL SECTION - GYMNASIUM BLEACHERS - UPPER LEVEL
3/4" = 1'-0"

WWW.DILine.com

SA&E PROJECT NUMBER	01-615-056
BID PACKAGE	BP-1
ISSUED FOR CONSTRUCTION	10/15/2019
Southern AE 7951 Truon Circle Austell, Ga 30168 (770) 819-7777 architects & engineers	REVISIONS
	R # Doc # Date
FACILITY CODE NUMBER: 674-0110 GYMNASIUM/AUDITORIUM FOR: HEARD COUNTY SCHOOLS 545 MAIN STREET, FRANKLIN, GA 30217 HEARD COUNTY SCHOOL SYSTEM FRANKLIN, GEORGIA	
GYMNASIUM BLEACHER DETAILS	
	DRAWING NUMBER
	A506