



- SPECIFIC PLUMBING PLAN NOTES - P103**
- ① 4" SAN. WASTE LINE-RE: 1/U101 FOR CONTINUATION.
 - ② 4" F.C.O.-2-RE: SPEC'S. AND DETAIL 5/P501.
 - ③ 3" C.W., 1 1/2" H.W. AND 2 1/2" H.W. LINES-RE: 3/P406 FOR CONTINUATION.
 - ④ 3" SAN. WASTE DOWN AND 2" SAN. VENT UP.
 - ⑤ 3/4" C.W. AND 3/4" H.W. LINES DOWN.
 - ⑥ 3" SAN. WASTE DOWN FROM CONDENSATE DRAIN.

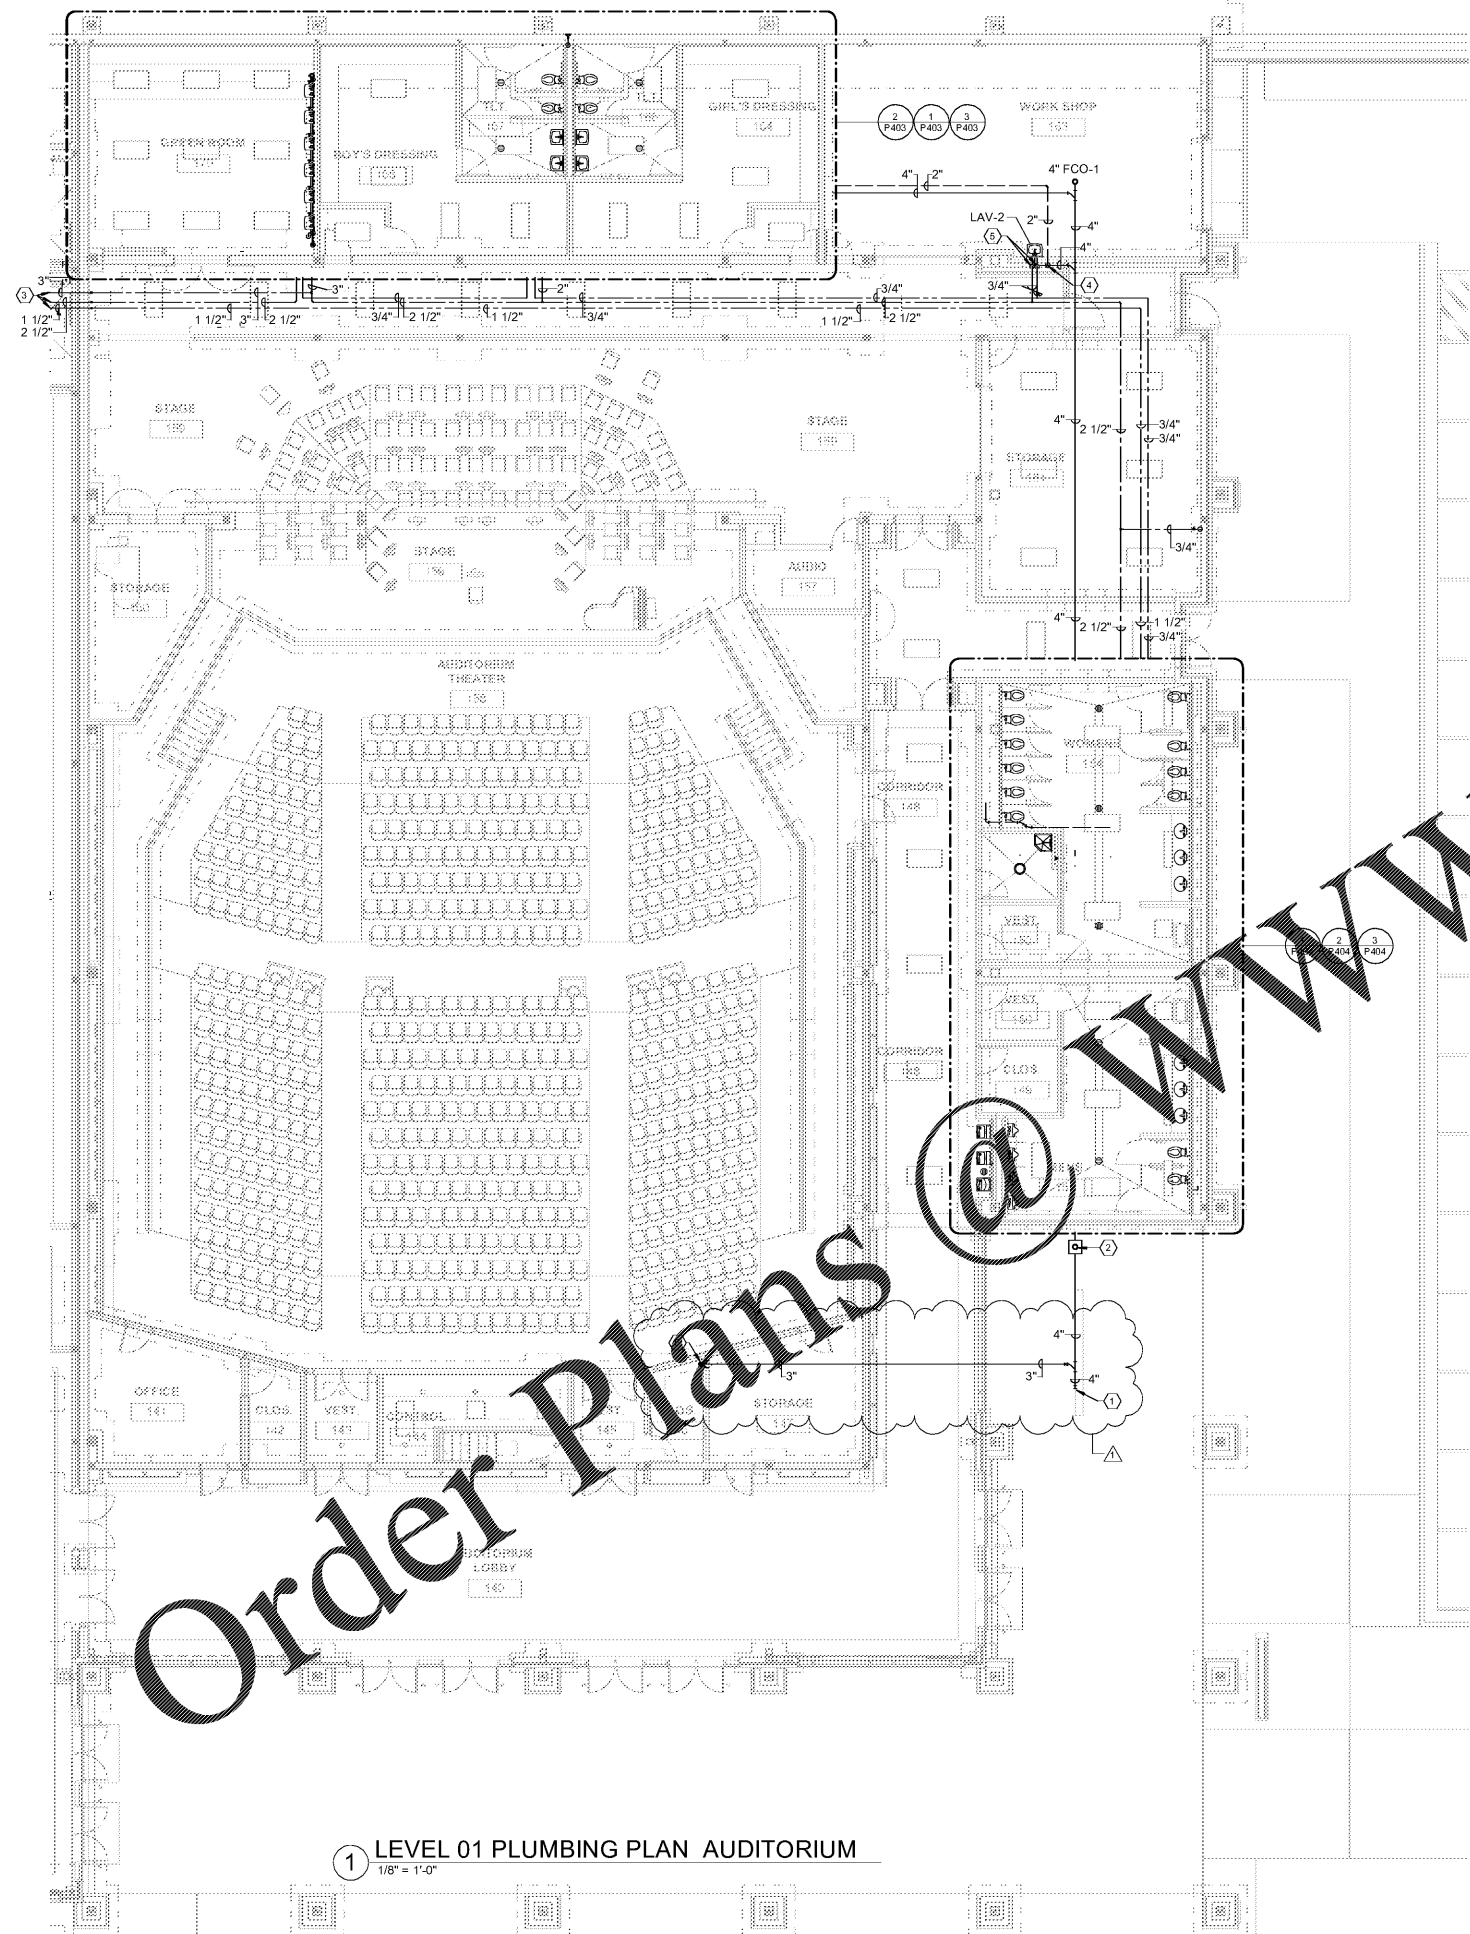

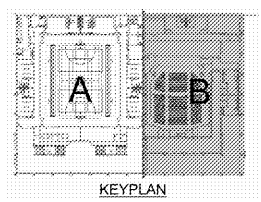

Order Plans @ www.LDILine.com

www.LDILine.com



① LEVEL 01 PLUMBING PLAN AUDITORIUM
1/8" = 1'-0"

SA&E PROJECT NUMBER	01-615-056
BID PACKAGE	BP-1
ISSUED FOR CONSTRUCTION	10/15/2019
Southern AE 7951 Troon Circle Austell, Ga 30168 (770) 819-7777 architects & engineers	REVISIONS R # Doc # Date 1 AD1 11.4.2019
	FACILITY CODE NUMBER: 674-0110 GYMNASIUM/AUDITORIUM FOR: HEARD COUNTY SCHOOLS 545 MAIN STREET, FRANKLIN, GA 30217 HEARD COUNTY SCHOOL SYSTEM FRANKLIN, GEORGIA
AUDITORIUM - LOWER LEVEL	
 	DRAWING NUMBER
	P103