



- SPECIFIC PLUMBING PLAN NOTES - P105**
- 2" LOW PRESSURE (7" WC) GAS LINE DOWN TO RISER ROOM # 214. CONNECT 2" LOW PRESSURE (7" WC) GAS LINE TO GAS WATER HEATERS—SEAL PENETRATION THROUGH ROOF WATER TIGHT. RE: 4/P403 FOR CONTINUATION.
 - CONNECT 1" LOW PRESSURE (7" WC) GAS LINE TO GAS ROOF TOP UNIT—RE: DETAIL 1/P502.
 - ROOF PIPE SUPPORT—RE: SPEC'S AND DETAIL 8/P501.
 - EXTERIOR POST HYDRANT ON ROOF. SEAL PENETRATION THROUGH ROOF WATER TIGHT.—RE: SPEC'S, SCHEDULE AND DETAIL 4/P502.
 - 1 1/2" MED. PRESSURE (5PSI) GAS LINE UP FROM LEVEL 1—RE: 1/U101 FOR CONTINUATION
 - CONNECT 1 1/4" LOW PRESSURE (7" WC) GAS LINE TO GAS ROOF TOP UNIT—RE: DETAIL 1/P502.
 - RISE 1 1/2" MEDIUM PRESSURE (5 PSI) GAS LINE UP TO ABOVE SECOND ROOF LEVEL. SEAL PENETRATION THROUGH ROOF WATER TIGHT.

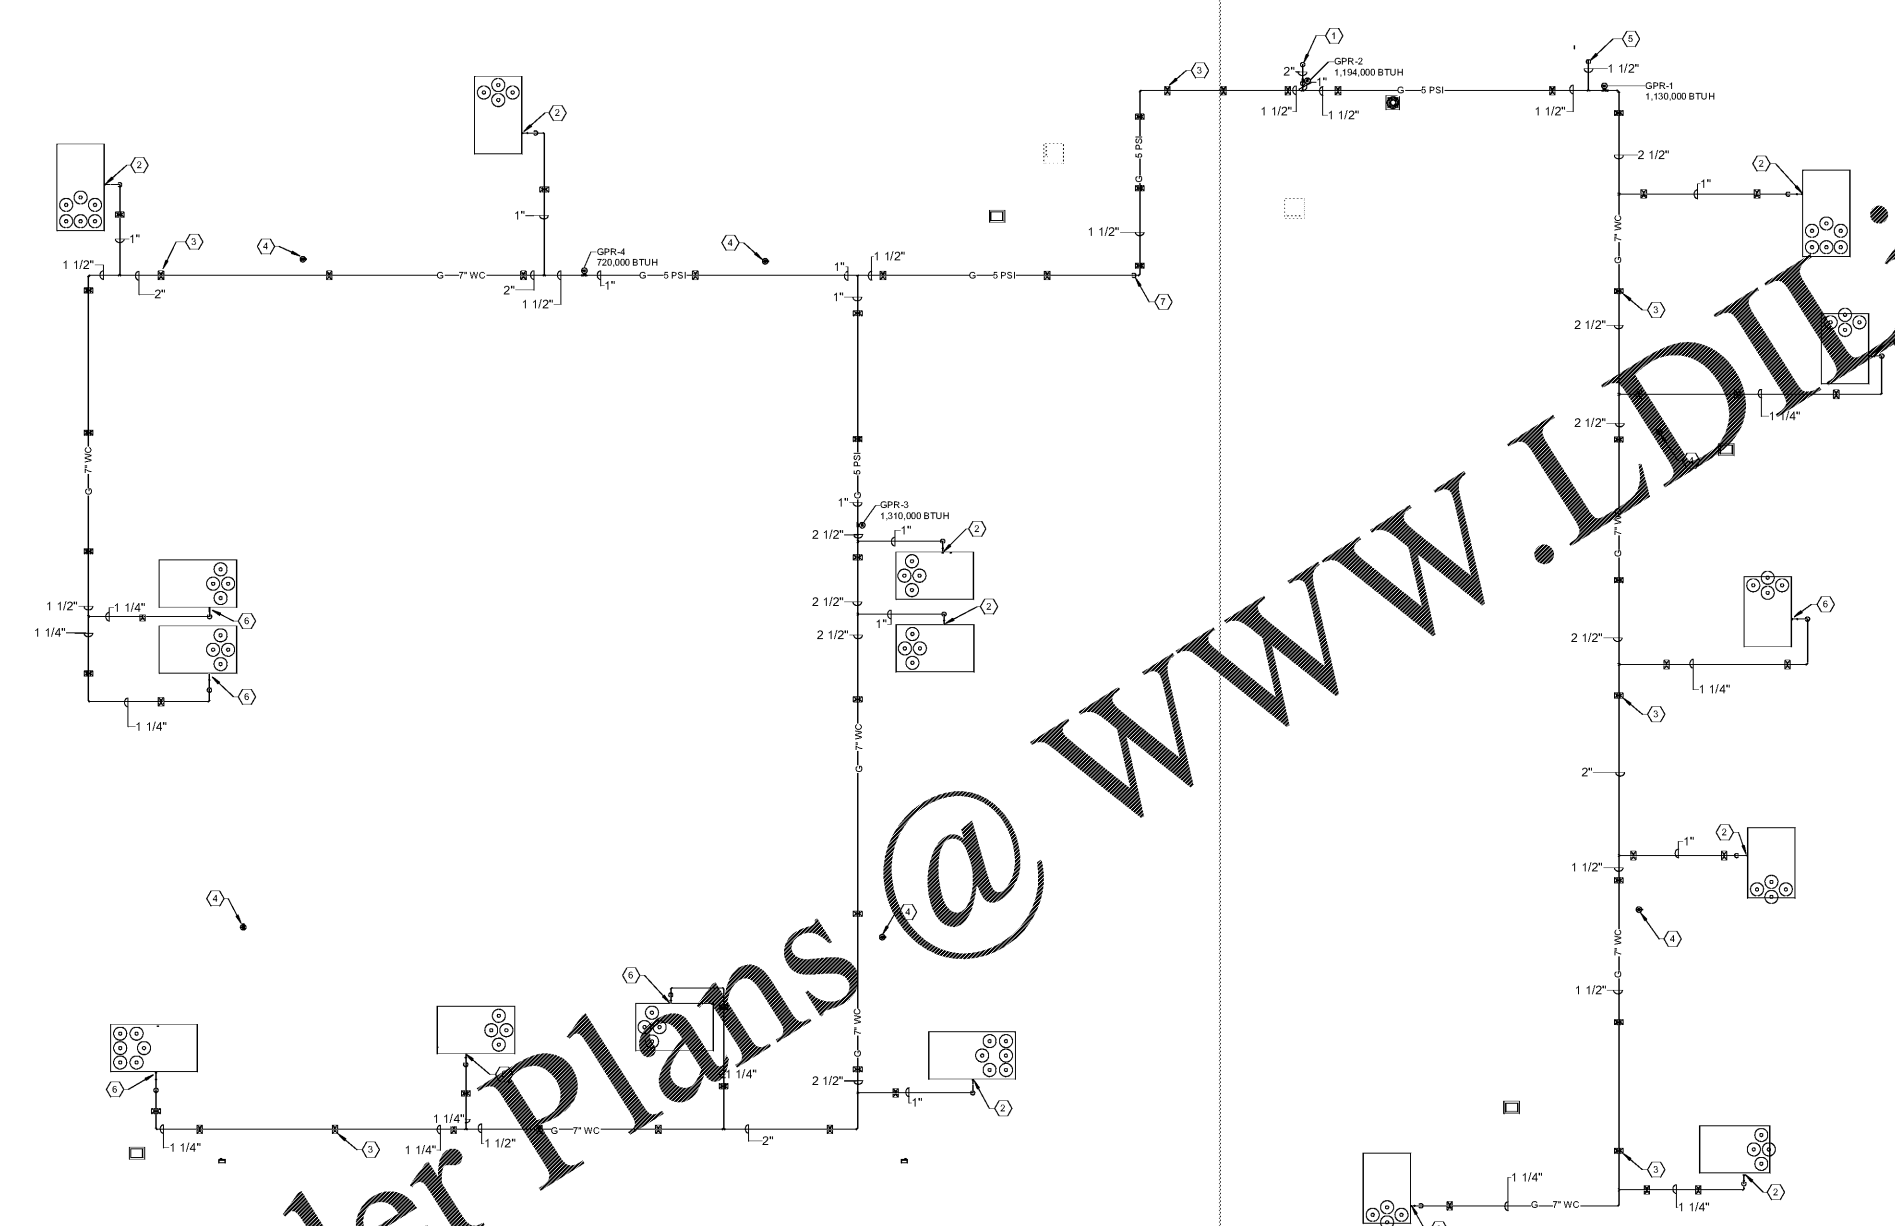


www.LDILine.com

Order Plans @

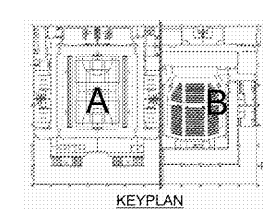

1 PLUMBING GAS PLAN - ROOF
3/32" = 1'-0"

SA&E PROJECT NUMBER	01-615-056
BID PACKAGE	BP-1
ISSUED FOR CONSTRUCTION	10/15/2019
Southern AE 7951 Tricon Circle Austell, Ga 30168 (770) 819-7777 architects & engineers	REVISIONS
	R # Doc # Date
FACILITY CODE NUMBER: 674-0110 GYMNASIUM/AUDITORIUM FOR: HEARD COUNTY SCHOOLS 545 MAIN STREET, FRANKLIN, GA 30217 HEARD COUNTY SCHOOL SYSTEM FRANKLIN, GEORGIA	
PLUMBING GAS PLAN	
	DRAWING NUMBER P105