




1 ENLARGED PLUMBING BELOW FLOOR PLAN HOME - BOYS 124 - LEVEL 1
1/4\" = 1'-0"

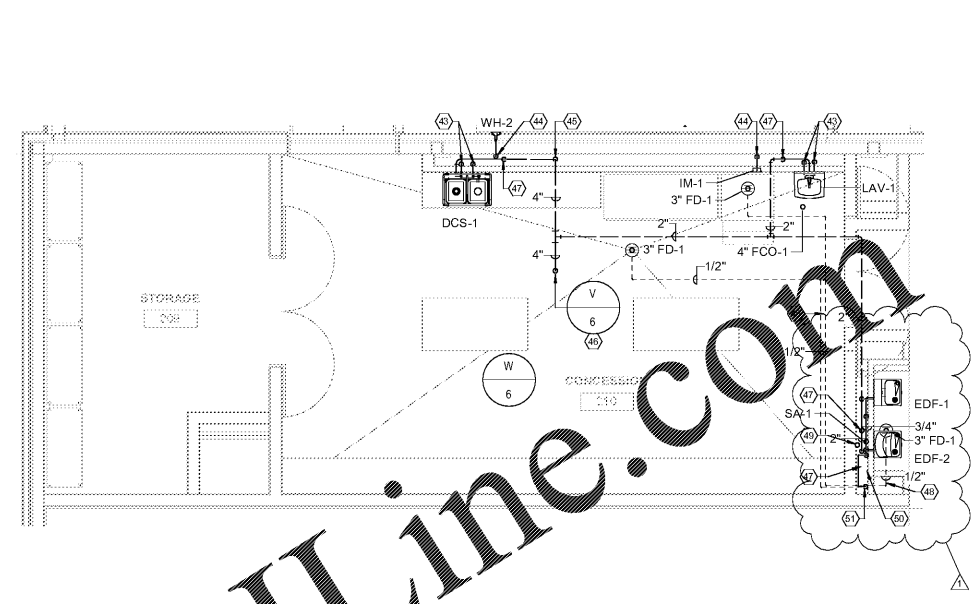

4 LEVEL 02 ENLARGED PLUMBING UPPER FLOOR PLAN CONCESSION 208
1/4\" = 1'-0"

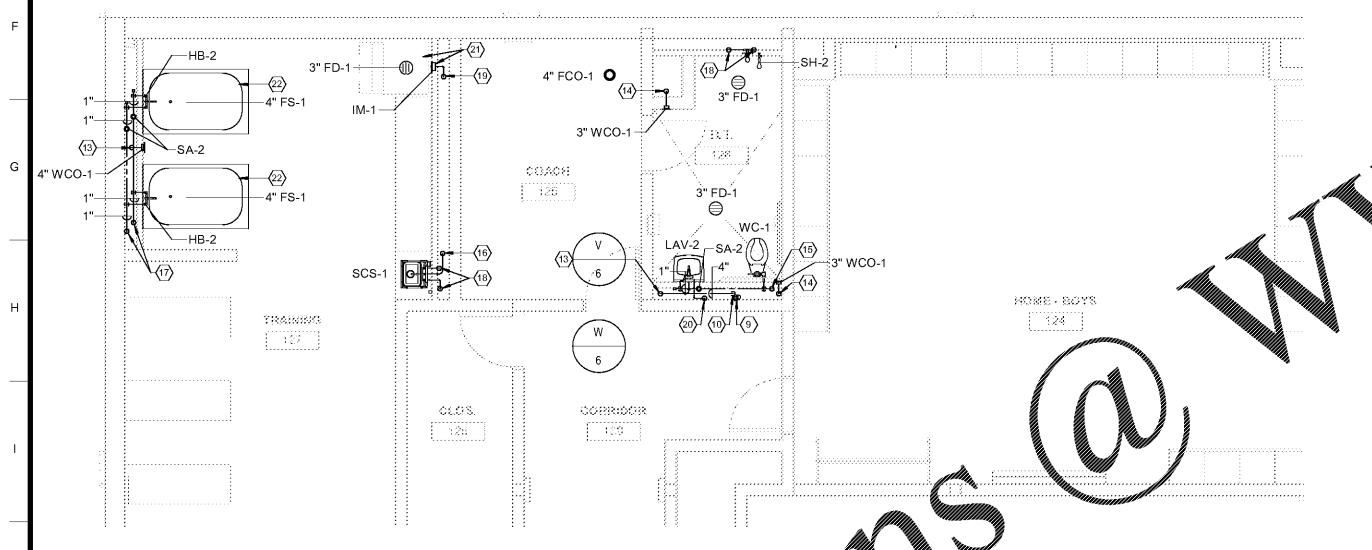

2 ENLARGED PLUMBING ABOVE FLOOR PLAN HOME - BOYS 124 - LEVEL 1
1/4\" = 1'-0"

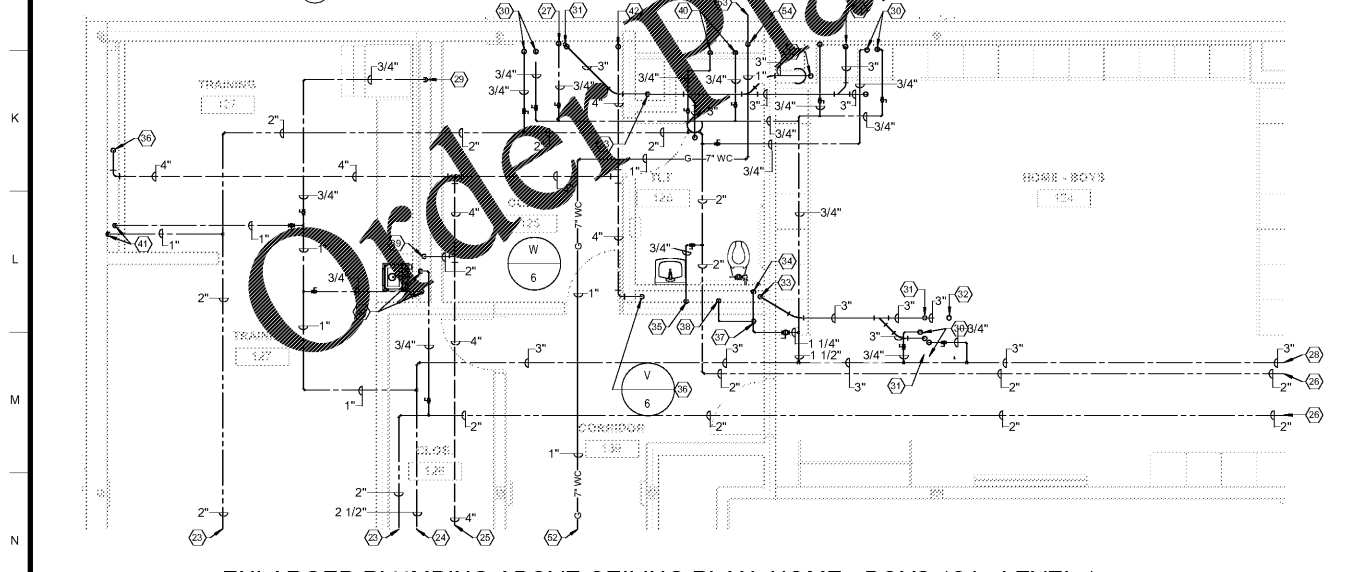

3 ENLARGED PLUMBING ABOVE CEILING PLAN HOME - BOYS 124 - LEVEL 1
1/4\" = 1'-0"

SPECIFIC PLUMBING PLAN NOTES - P401

- 1 4" SAN. WASTE LINE-RE: 1/P101 FOR CONTINUATION.
- 2 4" SAN. WASTE LINE BELOW GRADE.
- 3 1/2" TRAP PRIMER LINE BELOW GRADE.
- 4 CENTER WHIRLPOOL OVER FLOOR SINK.
- 5 3" SAN. WASTE LINE DOWN FROM FLOOR DRAIN.
- 6 4" SAN. WASTE LINE DOWN FROM FLOOR CLEANOUT.
- 7 3" SAN. WASTE LINE DOWN.
- 8 4" SAN. WASTE LINE DOWN FROM WATER CLOSET.
- 9 1/2" TRAP PRIMER LINES DOWN.
- 10 4" SAN. VENT LINE UP.
- 11 4" SAN. WASTE LINE DOWN.
- 12 4" SAN. WASTE LINE DOWN FROM FLOOR SINK.
- 13 4" SAN. WASTE DOWN AND 4" SAN. VENT UP TO ABOVE CEILING.
- 14 3" WASTE DOWN FROM FLOOR ABOVE.
- 15 4" SAN. WASTE DOWN AND 4" SAN. VENT UP.
- 16 3" SAN. WASTE DOWN AND 2" SAN. VENT UP TO ABOVE CEILING.
- 17 1" C.W. AND 1" H.W. LINE DOWN FROM ABOVE CEILING.
- 18 3/4" C.W. AND 3/4" H.W. LINE DOWN FROM ABOVE CEILING.
- 19 3/4" C.W. LINE DOWN FROM ABOVE CEILING.
- 20 3/4" H.W. LINE DOWN FROM ABOVE CEILING.
- 21 CONNECT 1/2" C.W. LINE TO ICE MAKER - PROVIDE CARTRIDGE TYPE WATER FILTER PRIOR TO CONNECTION.
- 22 WHIRLPOOL PROVIDED BY OWNER AND INSTALLED BY CONTRACTOR.
- 23 2" H.W. LINE-RE: 1/P101 FOR CONTINUATION.
- 24 2 1/2" C.W. LINE-RE: 1/P101 FOR CONTINUATION.
- 25 4" SAN. VENT LINE-RE: 1/P101 FOR CONTINUATION.
- 26 2" H.W. LINE-RE: 3/P402 FOR CONTINUATION.
- 27 3/4" C.W. LINE UP TO FLOOR ABOVE.
- 28 3" C.W. LINE-RE: 3/P402 FOR CONTINUATION.
- 29 3/4" C.W. LINE DOWN TO FLOOR BELOW.
- 30 3/4" C.W. AND 3/4" H.W. LINES UP TO FLOOR ABOVE.
- 31 3" SAN. WASTE DOWN AT FLOOR ABOVE.
- 32 3" SAN. WASTE DOWN FROM FLOOR DRAIN AT FLOOR ABOVE.
- 33 3" SAN. WASTE LINE DOWN TO FLOOR BELOW.
- 34 1 1/4" C.W. LINE DOWN TO FLOOR BELOW.
- 35 3/4" H.W. LINE DOWN TO FLOOR BELOW.
- 36 4" SAN. VENT LINE UP FROM FLOOR BELOW.
- 37 RISE 1/2" C.W. LINE OFF TOP OF WATER MAIN.
- 38 DROP 1/2" C.W. INTO TOP OF TRAP SEAL PRIMER VALVE AND DISTRIBUTION UNIT - RE: SPECS. - PROVIDE ONE (1) VALVE AND DISTRIBUTION UNIT TO PROVIDE TRAP SEAL PROTECTION TO THREE (3) TRAPS - LOCATE VALVE AND DISTRIBUTION UNIT ABOVE CEILING LEVEL AND DROP FOUR (4) 1/2" TRAP PRIMER LINES DOWN TO BELOW FLOOR.
- 39 2" SAN. VENT LINE UP FROM FLOOR BELOW.
- 40 3/4" C.W. AND 3/4" H.W. LINE DOWN TO FLOOR BELOW.
- 41 1" C.W. AND 1" H.W. LINE DOWN TO FLOOR BELOW.
- 42 4" SAN. VENT LINE UP TO FLOOR ABOVE.
- 43 3/4" C.W. AND 3/4" H.W. LINES UP FROM FLOOR BELOW.
- 44 3/4" C.W. LINE UP FROM FLOOR BELOW.
- 45 4" SAN. VENT LINE UP FROM FLOOR BELOW UP TO ABOVE CEILING.
- 46 4" SAN. VENT LINE UP TO 4" V.T.R.
- 47 3" SAN. WASTE DOWN AND 2" SAN. VENT UP.
- 48 1/2" TRAP PRIMER LINE BELOW FLOOR.
- 49 3/4" C.W. LINE UP FROM BELOW FLOOR-EXTEND UP TO ABOVE CEILING AND CONNECT TO POST HYDRANT ON ROOF.
- 50 3/4" C.W. LINE UP FROM BELOW FLOOR-EXTEND 1/2" C.W. LINE UP TO ABOVE CEILING.
- 51 DROP 1/2" C.W. INTO TOP OF TRAP SEAL PRIMER VALVE AND DISTRIBUTION UNIT - RE: SPECS. - PROVIDE ONE (1) VALVE AND DISTRIBUTION UNIT TO PROVIDE TRAP SEAL PROTECTION TO THREE (3) TRAPS - LOCATE VALVE AND DISTRIBUTION UNIT ABOVE CEILING LEVEL AND DROP THREE (3) 1/2" TRAP PRIMER LINES DOWN TO BELOW FLOOR.
- 52 1" LOW PRESSURE (7" WC) GAS LINE-RE: 1/P101 FOR CONTINUATION.
- 53 1" LOW PRESSURE (7" WC) GAS LINE-RE: 1/P102 FOR CONTINUATION.
- 54 EXTEND 1" LOW PRESSURE (7" WC) GAS LINE DOWN TO BELOW FLOOR OF SECOND LEVEL.

SA&E PROJECT NUMBER	01-615-056	
BID PACKAGE	BP-1	
ISSUED FOR CONSTRUCTION	10/15/2019	
REVISIONS		
R #	Doc #	Date
1	AD1	11.4.2019

Southern AE
 7951 Traxon Circle
 Austell, Ga 30168
 (770) 819-7777
 architects & engineers

FACILITY CODE NUMBER: 674-0110
 GYMNASIUM/AUDITORIUM FOR:
HEARD COUNTY SCHOOLS
 545 MAIN STREET, FRANKLIN, GA 30217
HEARD COUNTY SCHOOL SYSTEM
 FRANKLIN, GEORGIA

ENLARGED PLUMBING FLOOR PLANS

DRAWING NUMBER
P401

Order Plans @ WWW.IDIline.com