
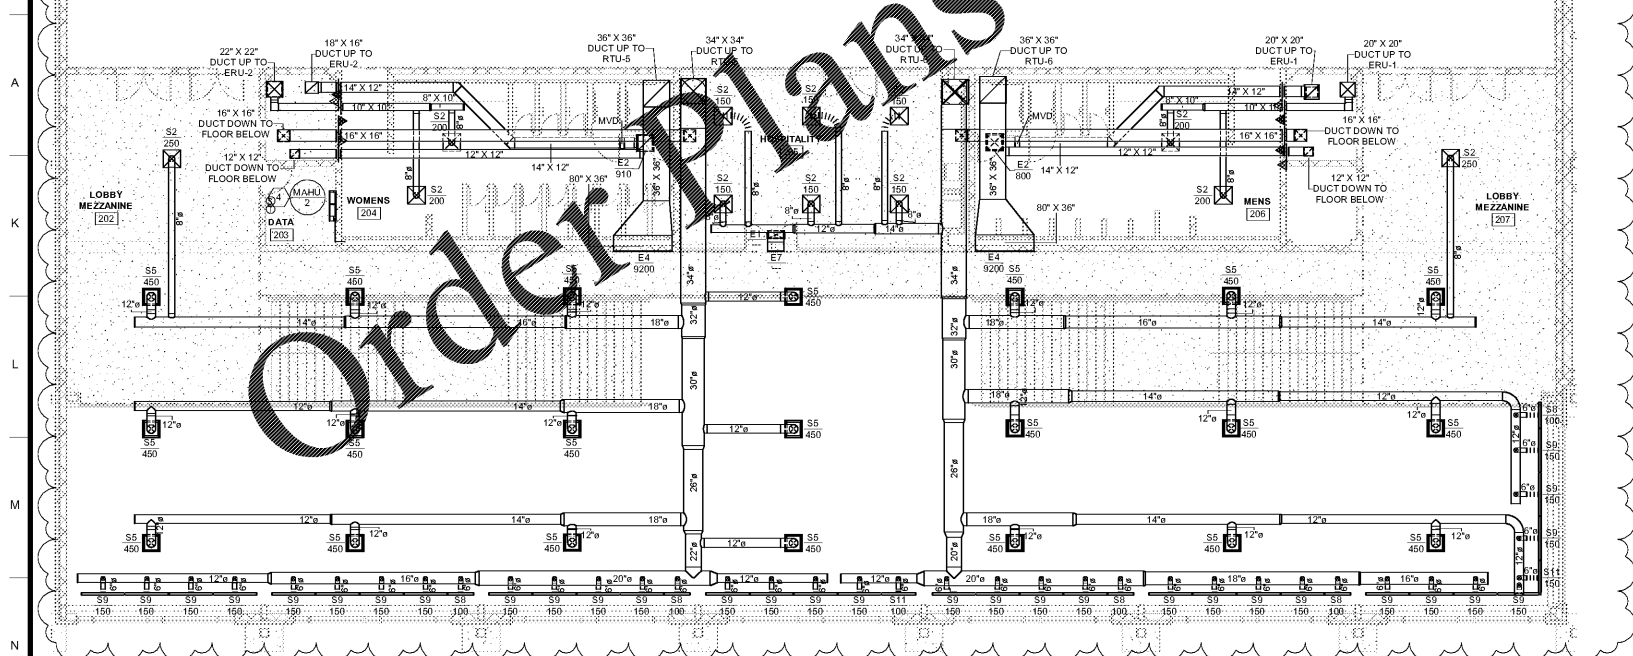


KEYNOTES	
7	INSTALL MINI-SPLIT ON WALL AS HIGH AS POSSIBLE BUT BELOW CEILING. INSTALL CONDENSATE LIFT PUMP (TYPE CLEARVUE MINI OR APPROVED ALTERNATE) AND ROUTE CONDENSATE DRAIN LINE UP THROUGH CEILING TO HUB DRAIN IN CHASE. ROUTE REFRIGERANT PIPING TO OUTDOOR UNIT IN MOST DIRECT WAY POSSIBLE. CONCEAL EXPOSED PUMP, PIPING AND CONDUIT - RE: DETAIL 11M501.
7	COVER END OF RETURN AIR DUCT WITH 1/4" HARDWARE CLOTH.

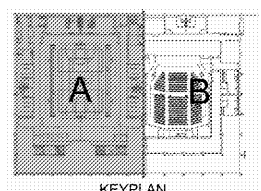

Order Plans @

WWW.LDILine.com

SA&E PROJECT NUMBER	01-615-056
BID PACKAGE	BP-1
ISSUED FOR CONSTRUCTION	10/15/2019
Southern AE 7951 Troon Circle Austell, Ga 30168 (770) 519-7777 architects & engineers	REVISIONS R# Doc# Date 1 AD1 11.4.2019

FACILITY CODE NUMBER: 674-0110
GYMNASIUM/AUDITORIUM FOR:
HEARD COUNTY SCHOOLS
 545 MAIN STREET, FRANKLIN, GA 30217
HEARD COUNTY SCHOOL SYSTEM
 FRANKLIN, GEORGIA

MECHANICAL PLAN - LEVEL 02 - GYMNASIUM

	DRAWING NUMBER M102
--	-------------------------------

1 LEVEL 02 MECHANICAL PLAN - GYMNASIUM
 1/8" = 1'-0"