



A
B
C
D
E
F
G
H
I
A
K
L
M
N

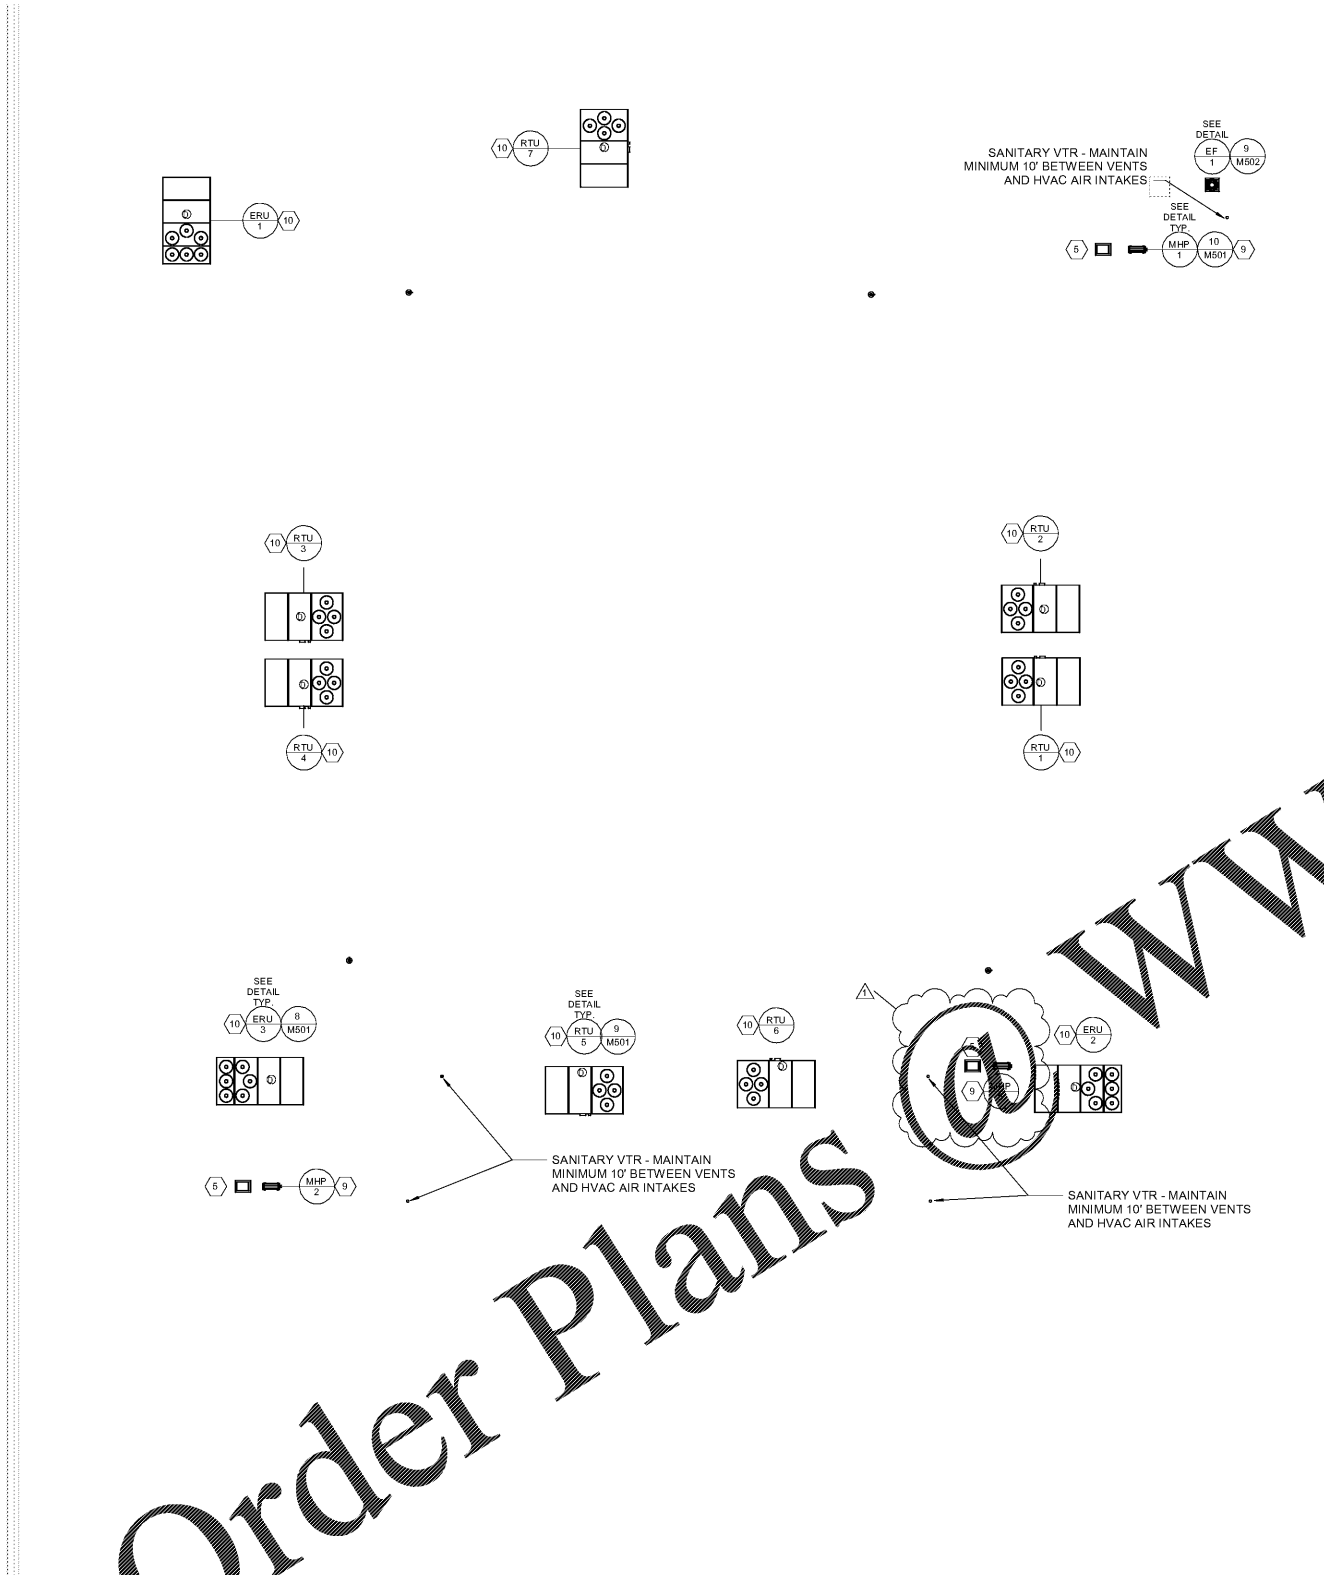

KEYNOTES	
5	PIPE CHASE HOUSING (SIGRIST-ALTA PRODUCTS OR APPROVED EQUIVALENT. SEAL PIPE PENETRATIONS ON HOUSING WITH A WEATHER TIGHT EXIT SEAL.
9	SECURE UNIT ON ROOF RAILS. REFER TO ARCHITECTURAL PLAN FOR EQUIPMENT RAIL DETAILS. NEATLY RACK REFRIGERANT PIPING CLOSE TO UNIT AND MAINTAIN MANUFACTURER'S SERVICE CLEARANCES. WEATHER PROTECT INSULATION USING PROTECTIVE ALUMINUM JACKET. USE PIPE MOUNTING PEDESTALS FOR PIPE SUPPORT THROUGH ROOF USING A PIPE CHASE HOUSING. EXTEND HORIZONTALLY ABOVE CEILING IN THE MOST DIRECT MANNER TO INDOOR COIL CONNECTIONS. PROVIDE RODS, HANGERS AND SADDLES AS REQUIRED. PIPE TO BE INSULATED PRIOR TO INSTALLATION OF CLAMPS AND SUPPORTS.
10	INSTALL PACKAGED UNIT ON ROOF CURB. EXTEND TRAPPED CONDENSATE LINE TO NEAREST DOWNSPOUT. REFER TO ARCHITECTURAL DRAWINGS FOR EQUIPMENT CURB DETAILS.

Order Plans

WWW.LDILine.com

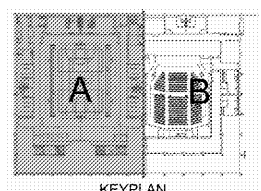

1 ROOF MECHANICAL PLAN - GYMNASIUM
3/32" = 1'-0"

SA&E PROJECT NUMBER	01-615-056
BID PACKAGE	BP-1
ISSUED FOR CONSTRUCTION	10/15/2019
Southern AE 7951 Truon Circle Austell, Ga 30168 (770) 819-7777 LLC architects & engineers	REVISIONS R # Doc # Date 1 AD1 11.4.2019
	FACILITY CODE NUMBER: 674-0110 GYMNASIUM/AUDITORIUM FOR: HEARD COUNTY SCHOOLS 545 MAIN STREET, FRANKLIN, GA 30217 HEARD COUNTY SCHOOL SYSTEM FRANKLIN, GEORGIA
MECHANICAL PLAN - ROOF - GYMNASIUM	
STATE OF GEORGIA REGISTERED ARCHITECT MICHAEL C. WALDBY	DRAWING NUMBER M103