



1 LEVEL 01 MECHANICAL PLAN - AUDITORIUM
1/8" = 1'-0"

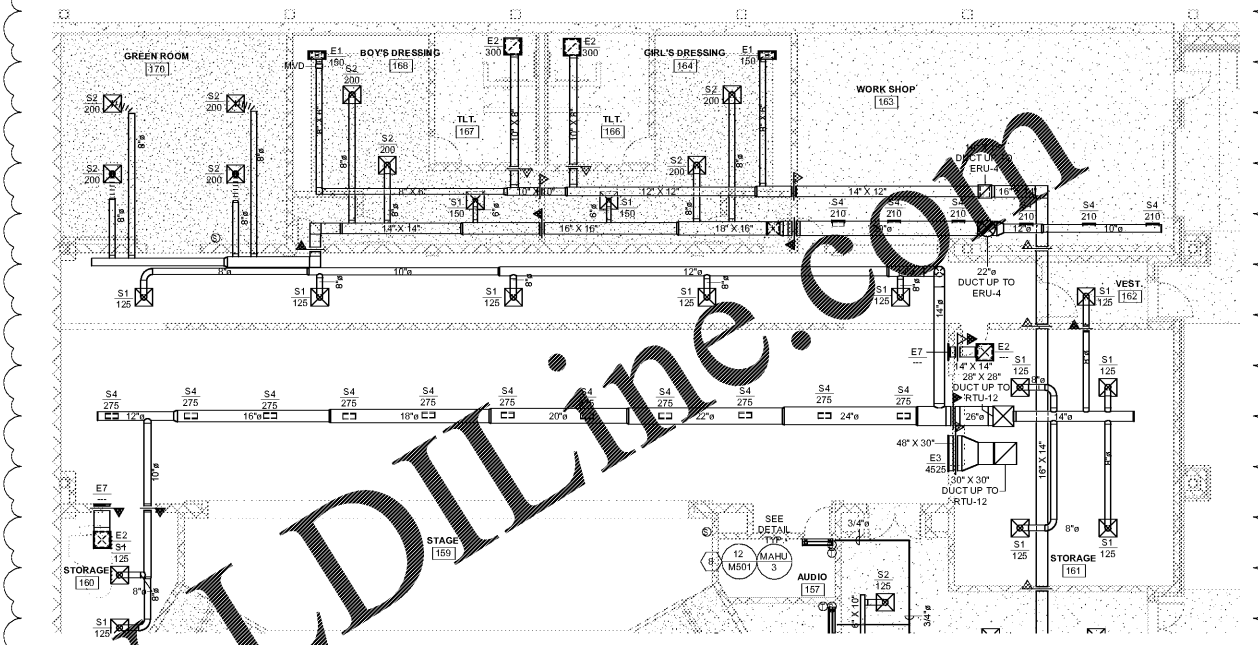

3 LEVEL 01 MECHANICAL PLAN - AUD - STAGE
1/8" = 1'-0"

KEYNOTES	
6	CONDENSATE DRAIN LINE WITH MINIMUM 1% SLOPE ROUTED ABOVE CEILING. TERMINATE IN HUB DRAIN - RE: PLUMBING DRAWING FOR EXACT HUB DRAIN LOCATION.
8	ROUTE MINI-SPLIT CONDENSATE DRAIN LINE FULL SIZE OF UNIT CONNECTION TO COMMON DRAIN. MINIMUM CONDENSATE DRAIN LINE SIZE IS 3/4". TERMINATE COMMON DRAIN IN HUB DRAIN - RE: PLUMBING DRAWING FOR EXACT HUB DRAIN LOCATION.

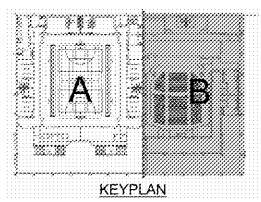

SA&E PROJECT NUMBER	01-615-056
BID PACKAGE	BP-1
ISSUED FOR CONSTRUCTION	10/15/2019
Southern AE	
7951 Truon Circle Austell, Ga 30168 (770) 519-7777 architects & engineers	REVISIONS R # Doc # Date 1 AD1 11.4.2019
FACILITY CODE NUMBER: 674-0110 GYMNASIUM/AUDITORIUM FOR: HEARD COUNTY SCHOOLS 545 MAIN STREET, FRANKLIN, GA 30217 HEARD COUNTY SCHOOL SYSTEM FRANKLIN, GEORGIA	
MECHANICAL PLAN - LEVEL 01 - AUDITORIUM	
	DRAWING NUMBER M104

Order Plans @ WWW.LDILine.com