



A  
B  
C  
D  
E  
F  
G  
H  
I  
A  
K  
L  
M  
N

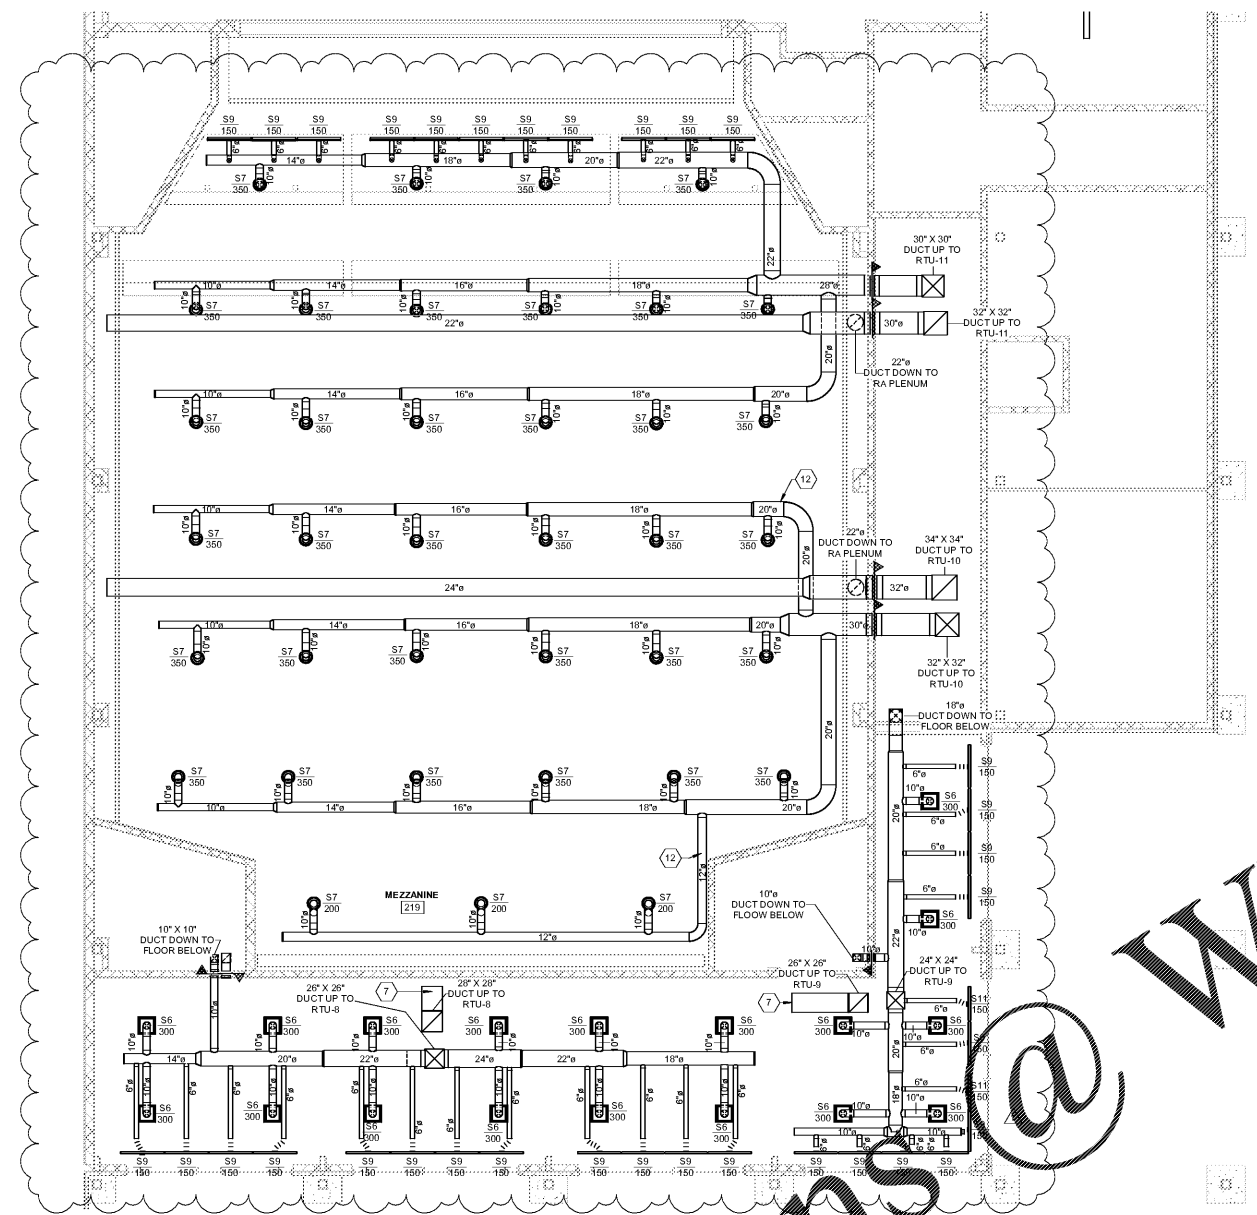


1 LEVEL 02 MECHANICAL PLAN - AUD - LOBBY  
1/8" = 1'-0"

**KEYNOTES**

7	COVER END OF RETURN AIR DUCT WITH 1/4" HARDWARE CLOTH.
8	SPIRAL DUCT IN AUDITORIUM TO BE DOUBLE WALLED SPIRAL DUCT WITH 1" INSULATION IN INTERSTITIAL SPACE.

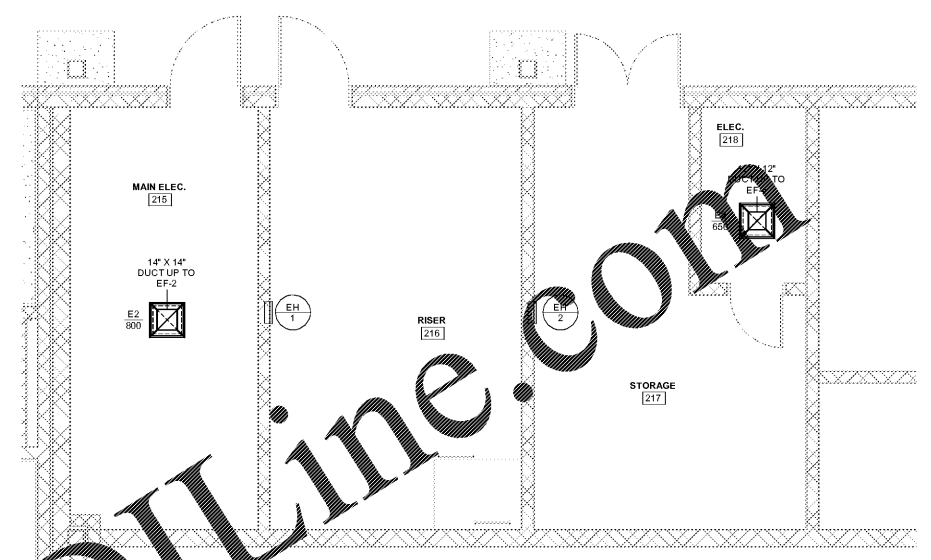

2 LEVEL 02 MECHANICAL PLAN - AUD - MEC ROOM  
1/4" = 1'-0"

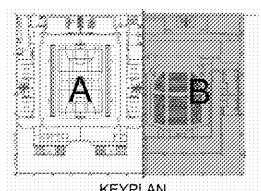

Order Plans @

WWW.LDILine.com

SA&E PROJECT NUMBER	01-615-056
BID PACKAGE	BP-1
ISSUED FOR CONSTRUCTION	10/15/2019
<b>Southern AE</b> 7951 Tricon Circle Austell, Ga 30168 (770) 519-7777 architects & engineers	REVISIONS R # Doc # Date 1 AD1 11.4.2019
	FACILITY CODE NUMBER: 674-0110 <b>GYMNASIUM/AUDITORIUM FOR:</b> <b>HEARD COUNTY SCHOOLS</b> 545 MAIN STREET, FRANKLIN, GA 30217 <b>HEARD COUNTY SCHOOL SYSTEM</b> FRANKLIN, GEORGIA
MECHANICAL PLAN - LEVEL 02 - AUDITORIUM	
STATE OF GEORGIA REGISTERED ARCHITECT STATE OF GEORGIA REGISTERED ENGINEER MICHAEL C. WALDBY	DRAWING NUMBER <b>M105</b>