



A
B
C
D
E
F
G
H
I
A
K
L
M
N

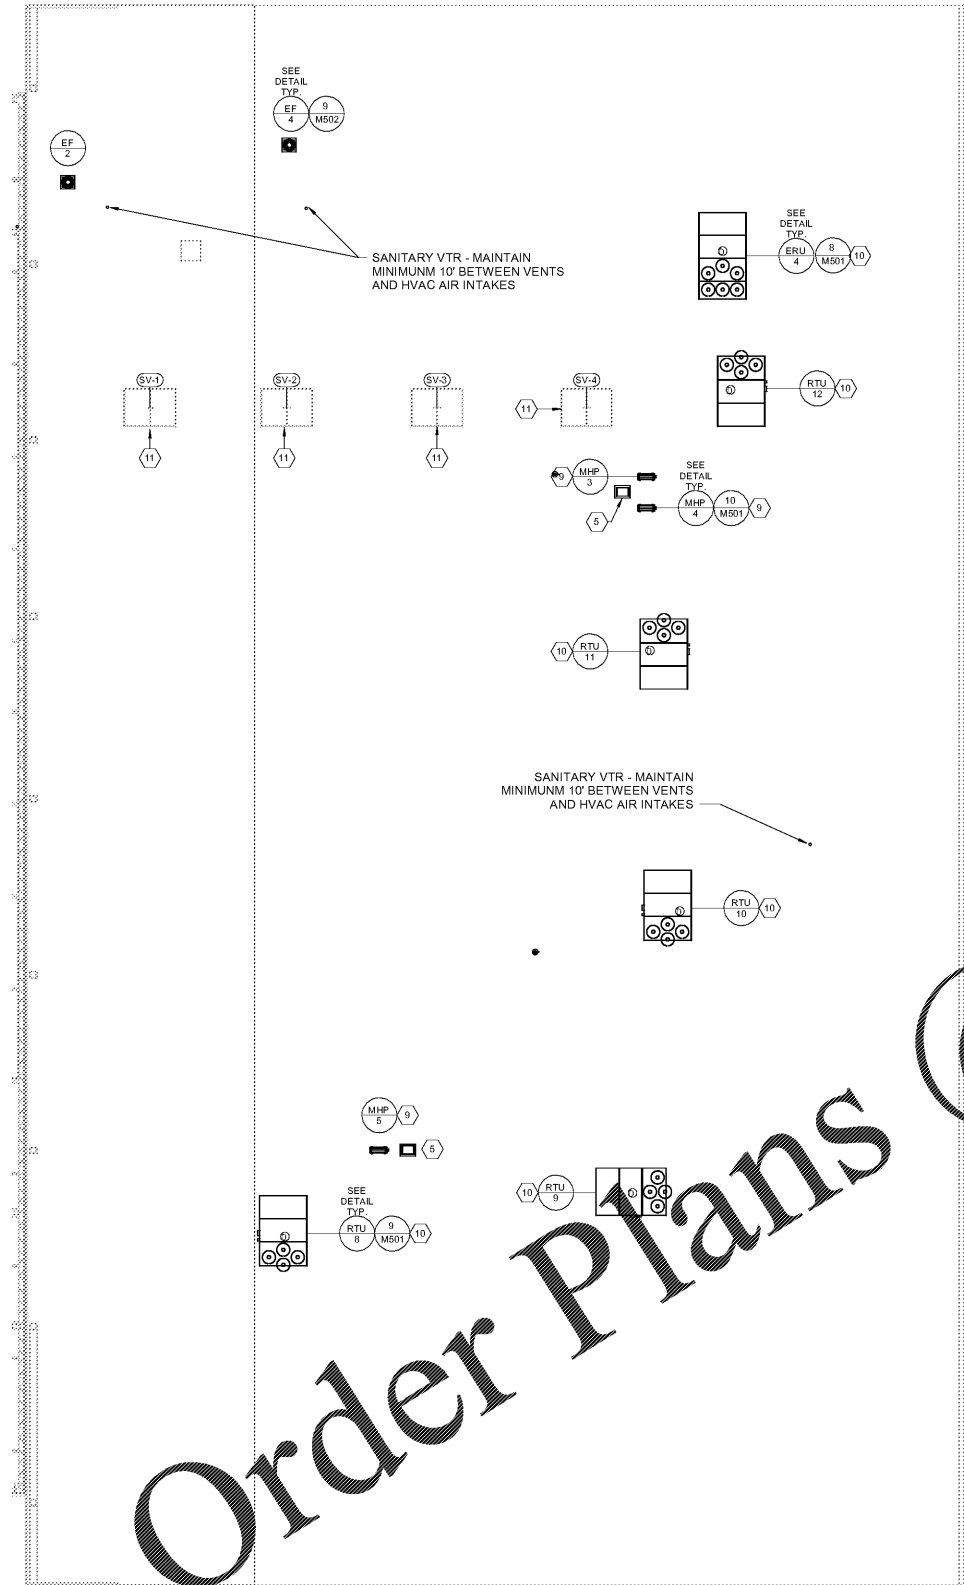

KEYNOTES	
5	PIPE CHASE HOUSING (SIGRIST-ALTA PRODUCTS OR APPROVED EQUIVALENT. SEAL PIPE PENETRATIONS ON HOUSING WITH A WEATHER TIGHT EXIT SEAL.
9	SECURE UNIT ON ROOF RAILS. REFER TO ARCHITECTURAL PLAN FOR EQUIPMENT RAIL DETAILS. NEATLY RACK REFRIGERANT PIPING CLOSE TO UNIT AND MAINTAIN MANUFACTURER'S SERVICE CLEARANCES. WEATHER PROTECT INSULATION USING PROTECTIVE ALUMINUM JACKET. USE PIPE MOUNTING PEDESTALS FOR PIPE SUPPORT. ROUTE THROUGH ROOF USING A PIPE CHASE HOUSING. EXTEND HORIZONTALLY ABOVE CEILING IN THE MOST DIRECT MANNER TO INDOOR COIL CONNECTIONS. PROVIDE RODS, HANGERS AND SADDLES AS REQUIRED. PIPE IS TO BE INSULATED PRIOR TO INSTALLATION OF CLAMPS AND SUPPORTS.
10	INSTALL PACKAGED UNIT ON ROOF CURB. EXTEND TRAPPED CONDENSATE LINE TO NEAREST DOWNSPOUT. REFER TO ARCHITECTURAL DRAWINGS FOR EQUIPMENT CURB DETAILS.
11	COORDINATE SMOKE VENT LOCATIONS WITH STRUCTURAL PLANS. REFER TO ARCHITECTURAL DRAWINGS FOR EQUIPMENT CURB AND ROOF FLASHING DETAILS.

Order Plans @ www.LDILine.com

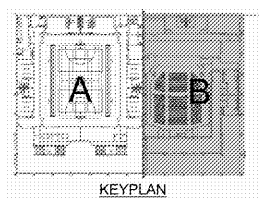

1 ROOF MECHANICAL PLAN - AUDITORIUM
3/32" = 1'-0"

SA&E PROJECT NUMBER	01-615-056
BID PACKAGE	BP-1
ISSUED FOR CONSTRUCTION	10/15/2019
Southern AE 7951 Tricon Circle Austell, Ga 30168 (770) 819-7777 architects & engineers	REVISIONS
	R # Doc # Date
FACILITY CODE NUMBER: 674-0110 GYMNASIUM/AUDITORIUM FOR: HEARD COUNTY SCHOOLS 545 MAIN STREET, FRANKLIN, GA 30217 HEARD COUNTY SCHOOL SYSTEM FRANKLIN, GEORGIA	
MECHANICAL PLAN - ROOF - AUDITORIUM	
	DRAWING NUMBER M106