
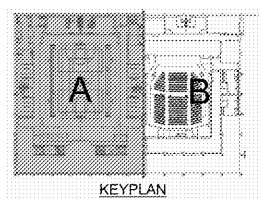


| # | KEYNOTE DESCRIPTION |
|-----|---------------------------------------------------------------------------------------------------------------------------------------------------------|
| L7 | PROVIDE CONNECTION FROM POWER PACK AND/OR ROOM CONTROLLER TO FIRE ALARM SYSTEM CONTROL MODULE FOR OVERRIDE OF OCCUPANCY SENSOR(S) DURING AN ALARM EVENT |
| L12 | ALL LIGHTING CONTROL CABLING INSTALLED IN THIS SPACE SHALL BE INSTALLED IN EMT CONDUIT. PAINT ALL CONDUIT, BOXES AND SUPPORTS TO MATCH STRUCTURE |
| L23 | 0-10V WIRING (PURPLE/GREY) IS NOT SHOWN ON THIS PLAN BUT SHALL BE PROVIDED IN ALL SPACES THAT HAVE DIMMING SYSTEM |

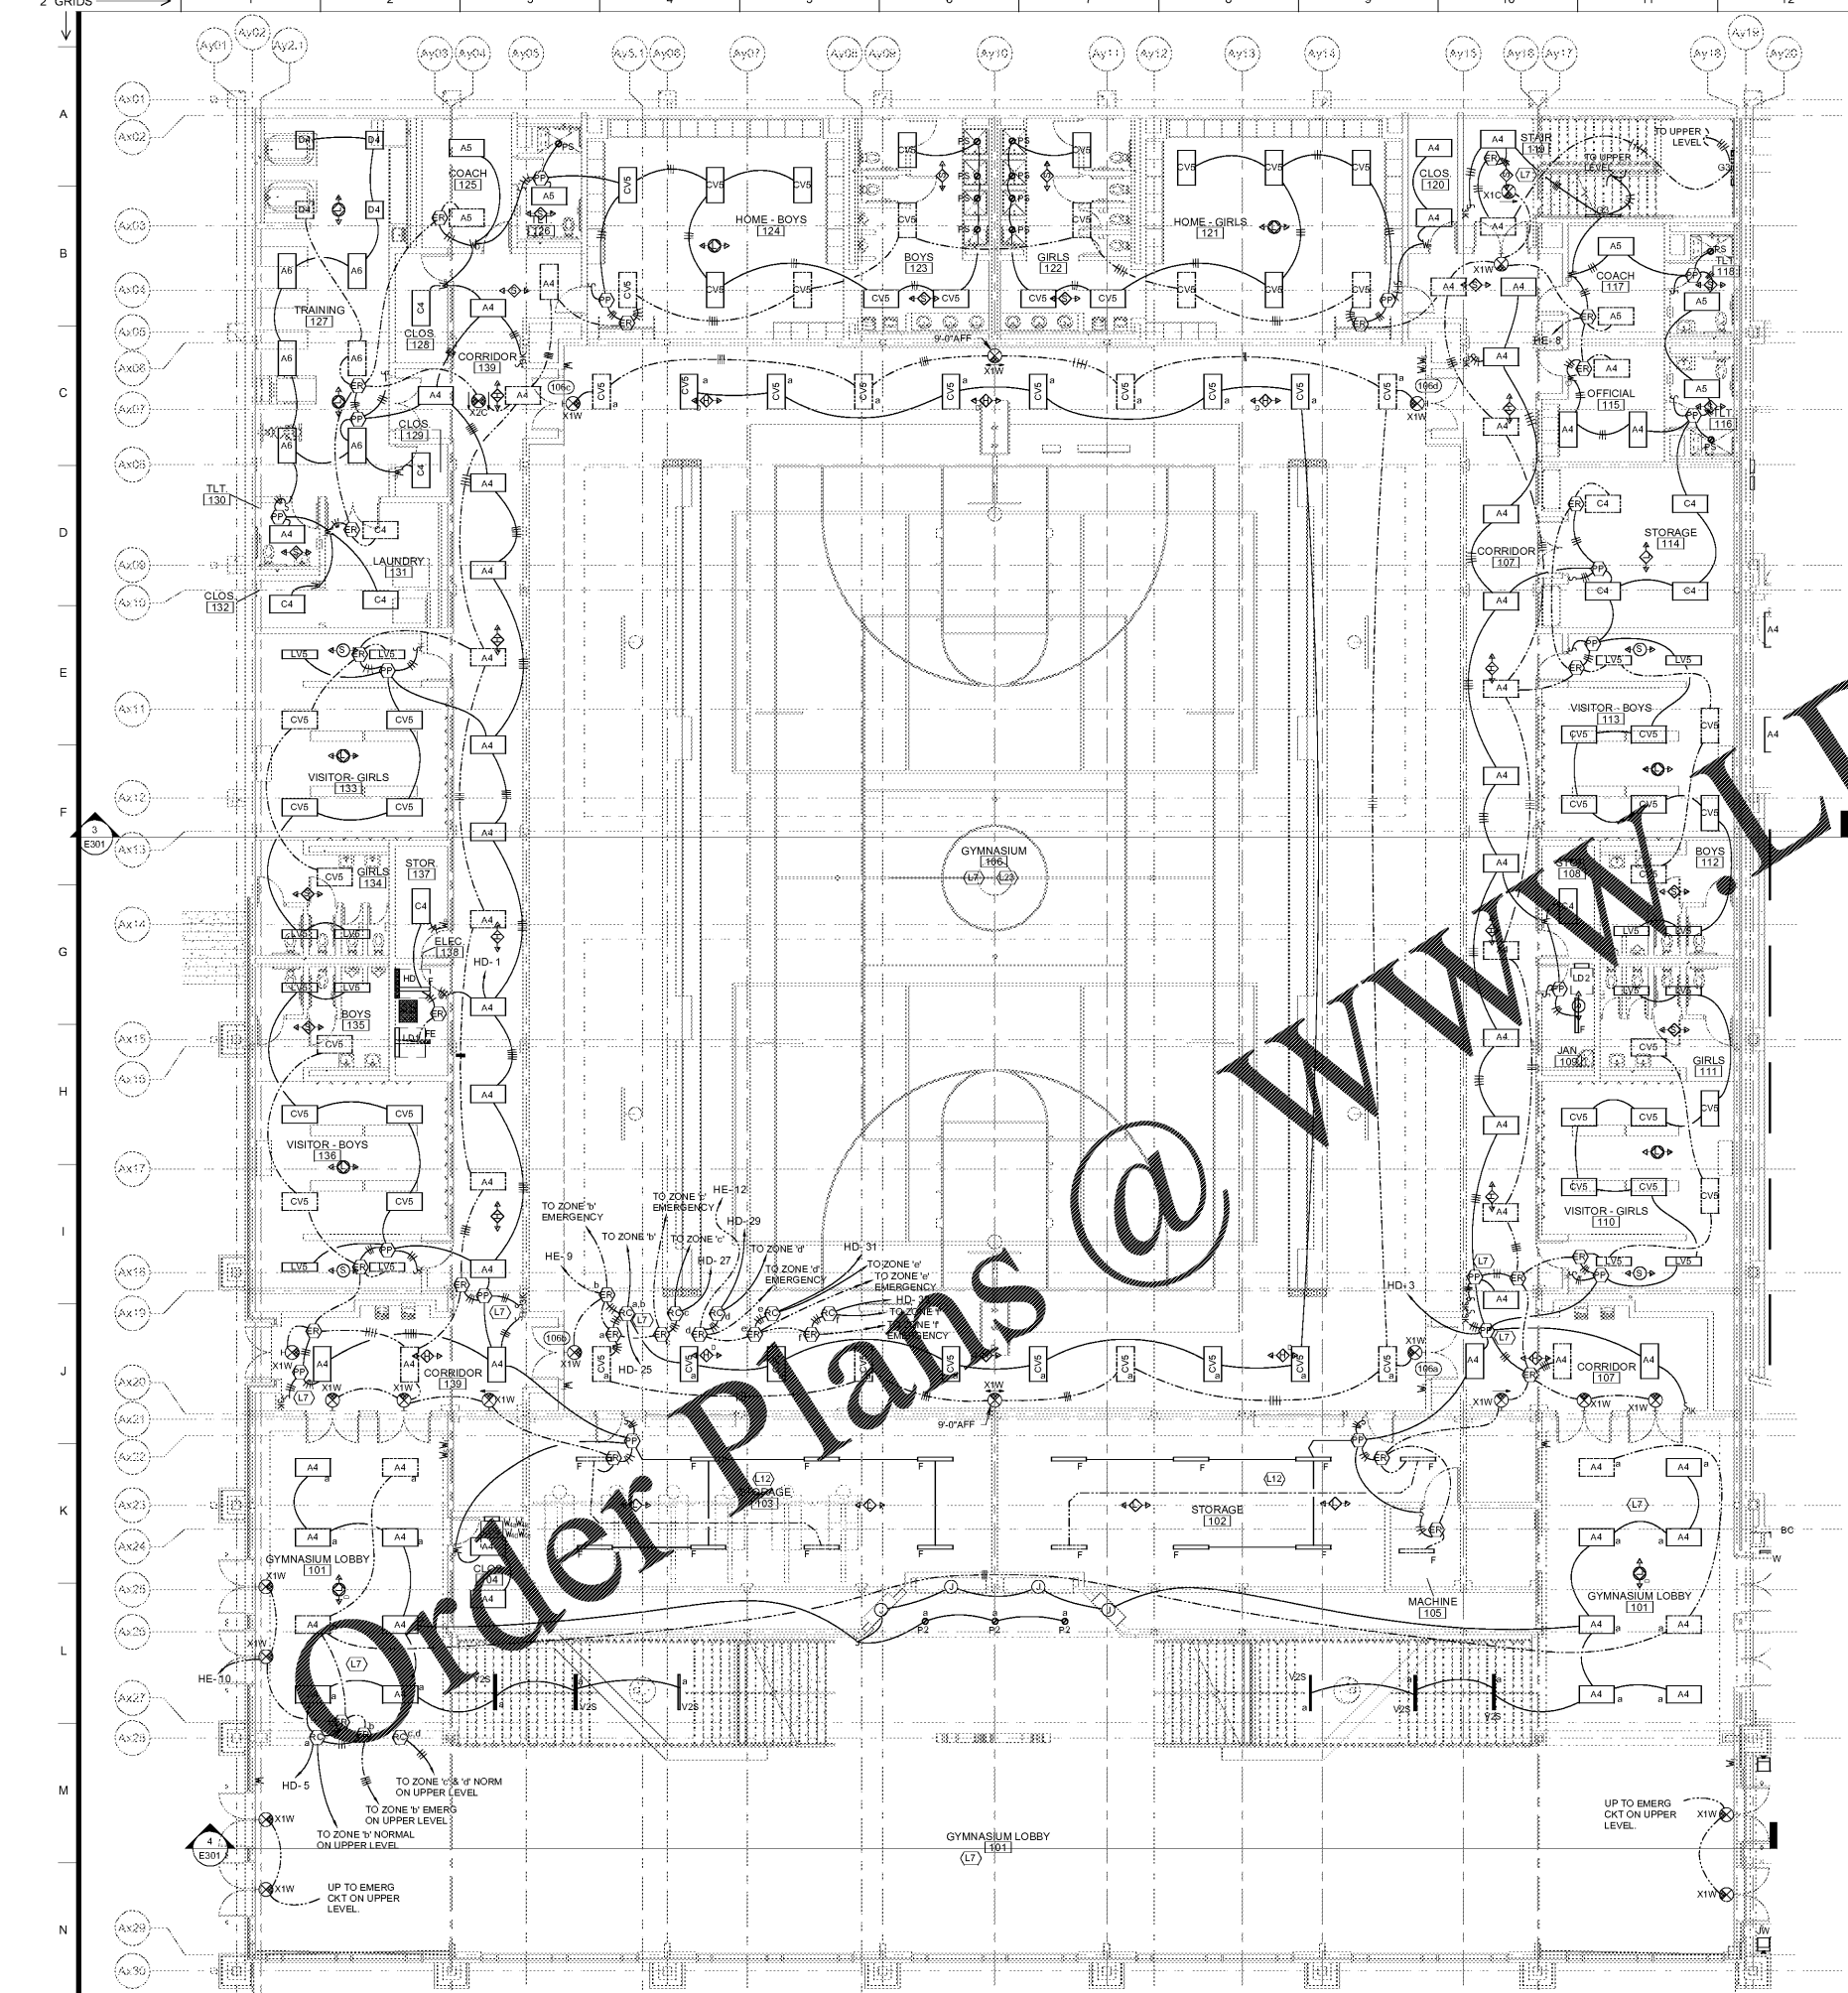

Order Plans @

| | |
|-----------------------------------------------------------|------------------------|
| SA&E PROJECT NUMBER | 01-615-056 |
| BID PACKAGE | BP-1 |
| ISSUED FOR CONSTRUCTION | 10/15/2019 |
| Southern AE | |
| 7951 Traxon Circle Austell, Ga 30168 (770) 819-7777 | architects & engineers |
| R # | Doc # |
| 1 | AD1 |
| Date | 11.4.2019 |

FACILITY CODE NUMBER: 674-0110
GYMNASIUM/AUDITORIUM FOR:
HEARD COUNTY SCHOOLS
 545 MAIN STREET, FRANKLIN, GA 30217
HEARD COUNTY SCHOOL SYSTEM
 FRANKLIN, GEORGIA

GYMNASIUM - LEVEL 01 - LIGHTING PLAN

1 LEVEL 01 - GYMNASIUM - LIGHTING PLAN
 1/8" = 1'-0"

DRAWING NUMBER
E101