



POWER KEYNOTE SCHEDULE

#	KEYNOTE DESCRIPTION
E11	DUPEX RECEPTACLE AT THIS LOCATION SHALL BE INSTALLED IN RECESSED DISPLAY WALL BOX AT 60" AFF. U.O.N.
E13	INSTALL AND PROVIDE CONNECTION TO PUSH BUTTON CONTROL DOOR MOTOR, LIMIT SWITCHES, OBSTRUCTION SENSORS AND OTHER ACCESSORIES FURNISHED WITH OVERHEAD DOOR.
E14	RECEPTACLE INSTALLED IN FACE OF BENCH SEATING 9" AFF.
E18	PROVIDE NEMA 6-30 SINGLE RECEPTACLE AND MATCHING PLUG FOR CONNECTION TO SPOT LIGHT IN THIS SPACE. MODIFY CORD SET SUPPLIED WITH SPOT LIGHT TO ACCOMMODATE THE NEMA 6-30 RECEPTACLE.
E19	PROVIDE CONDUIT AND WIRING FROM INDOOR UNIT TO CORRESPONDING OUTDOOR UNIT FOR INTERLOCK WIRING AND POWER. PROVIDE RECEPTACLE ABOVE CEILING FOR CONDENSATE PUMP, WHERE REQUIRED. REFER TO MINI-SPLIT INDOOR UNIT CONNECTION DETAIL ON DRAWING E301.
E20	PROVIDE CONNECTION TO POWERED VIDEO SCREEN. MOUNT JUNCTION BOX 20'-0" AFF. ROUTE A 3/4" CONDUIT AND WIRING FOR CONTROL FROM THIS LOCATION TO A SINGLE GANG OUTLET BOX 48" AFF IN CONTROL BOOTH 144. COORDINATE EXACT SCREEN LOCATION WITH ARCHITECTURAL DRAWINGS AND RIGGING/CURTAIN INSTALLER PRIOR TO ROUGH-IN. COORDINATE CONTROL SWITCH LOCATION WITH OWNER. COORDINATE CONTROL SYSTEM CONNECTION WITH SECTION 27' 41' 16' CONTRACTOR.
E21	RIGGING SYSTEM POWER RECEPTACLE & BACKBOX. FURNISHED AND INSTALLED BY RIGGING CONTRACTOR (TYP).
E22	RIGGING SYSTEM HOIST MODULE HUNG FROM ROOF JOIST. COORDINATE INSTALLATION WITH STRUCTURAL DRAWINGS. REFER TO RIGGING SYSTEM ONE-LINE DIAGRAM, DETAILS AND SECTION 11 61 73 FOR ADDITIONAL REQUIREMENTS.
E23	THEATER RIGGING SYSTEM HOIST CONTROLLER. FLUSH MOUNTED WITH TOP OF STATION 54' AFF. REFER TO RIGGING SYSTEM ONE-LINE DIAGRAM FOR DETAILS.
E25	PROVIDE 208V/3P/4W/200A COMPANY SWITCH 'CSA' WITH CAM LOCK OUTPUT CONNECTORS, PER SECTION 28 55 61. SWITCH FOR CONNECTION OF MOBILE SOUND EQUIPMENT. FURNISH AND INSTALL ENGRAVED NAMEPLATE.
E26	PROVIDE 208V/3P/4W/200A COMPANY SWITCH 'CSL' WITH CAM LOCK OUTPUT CONNECTORS, PER SECTION 28 55 61. SWITCH FOR CONNECTION OF MOBILE LIGHTING EQUIPMENT. FURNISH AND INSTALL ENGRAVED NAMEPLATE.
E33	SWITCHBOARD 150G SERVICE RACEWAYS ROUTED BELOW GRADE FROM UTILITY TRANSFORMER AND TURN UP CHASE TO CONNECTION POINT AT SWITCHBOARD ON MEZZANINE.
E34	LOCATE RECEPTACLE CONCEALED WITHIN ELECTRIC DRINK FOUNTAIN SHELROD, COORDINATE ROUGH-IN WITH PLUMBING CONTRACTOR.
E40	PROVIDE POWER/CONTROL WIRING/CABLING AND RACEWAY CONNECTION TO EACH AUTOMATED HOIST TO ASSOCIATED HOIST CONTROL. STATION LOCATED AT STAGE LEVEL. COORDINATE REQUIREMENTS WITH VENDOR SHOP DRAWINGS PRIOR TO ROUGH-IN.
E41	INSTALL DUPEX RECEPTACLE(S) IN AUDIO SYSTEM FLOOR BOX. COORDINATE SPACE AND VOLTAGE BARRIER REQUIREMENTS WITH SECTION 27 51 18.01 CONTRACTOR.
E42	THEATER AUDIO SYSTEM REMOTE CONTROLLED RECEPTACLE (208V/20A DUPEX RECEPTACLE) FLUSH MOUNTED IN CEILING BEHIND SUB WOOFER. RECEPTACLE TO BE FURNISHED BY AUDIO CONTRACTOR AND INSTALLED BY E.C. COORDINATE BACKBOX AND INSTALLATION REQUIREMENTS WITH AUDIO SYSTEM VENDOR SHOP DRAWINGS. PROVIDE LOW VOLTAGE CABLING TO TIE THESE RECEPTABLES TO POWER SEQUENCING OF AUDIO SYSTEM EQUIPMENT.

1 LEVEL 01 - AUDITORIUM - POWER PLAN
1/8" = 1'-0"

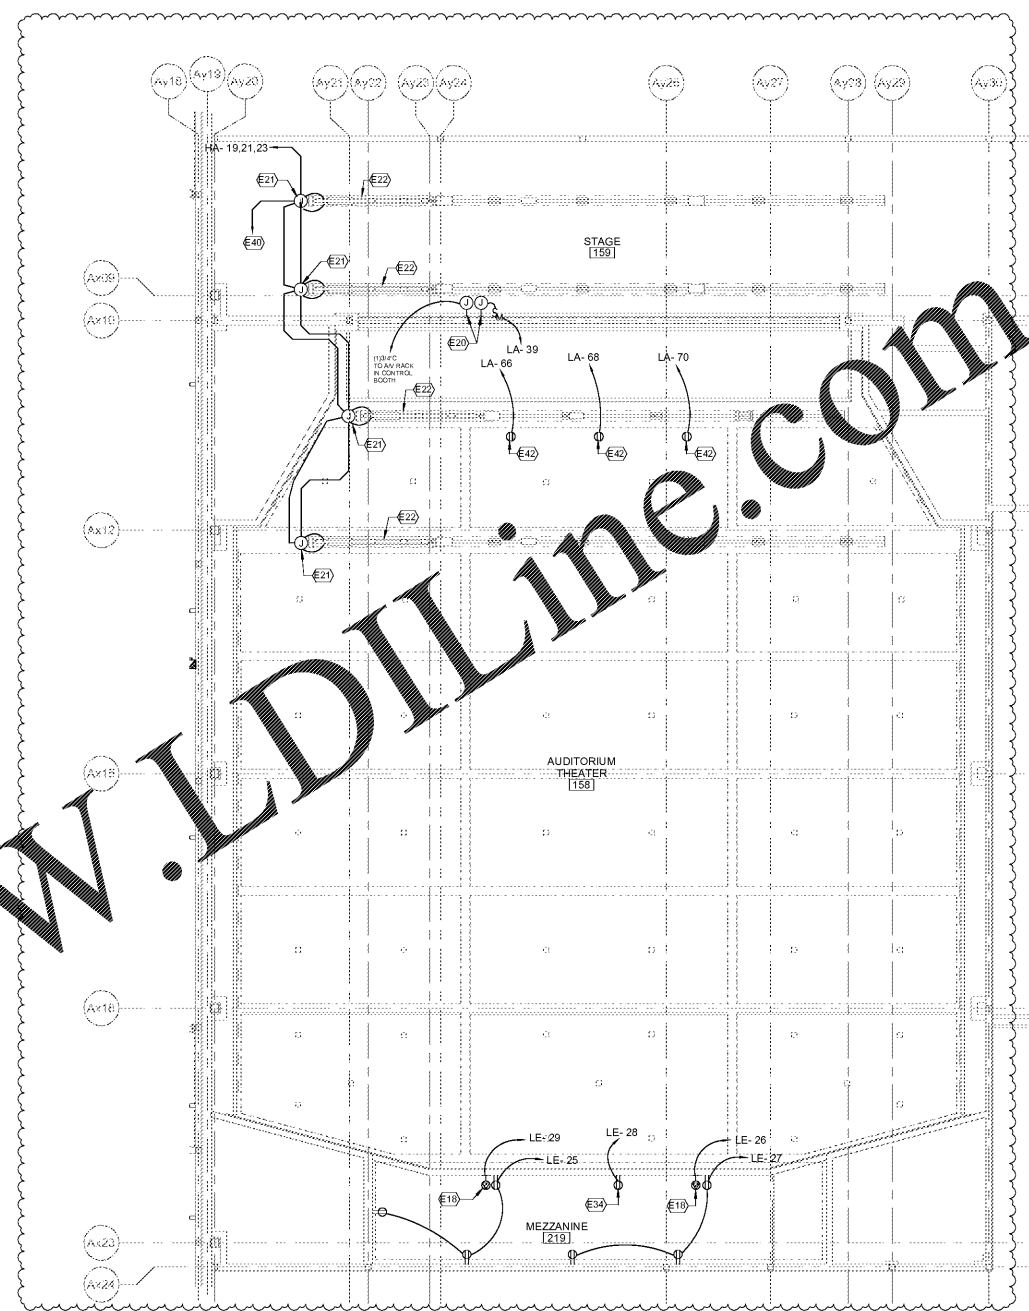

3 LEVEL 02 - AUDITORIUM - MEZZANINE POWER PLAN
1/8" = 1'-0"

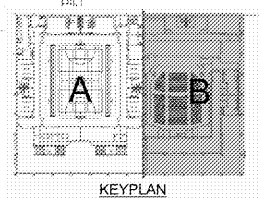

Order Plans @ www.LDILine.com

DIGITAL SIGNAGE?

SA&E PROJECT NUMBER	01-615-056
BID PACKAGE	BP-1
ISSUED FOR CONSTRUCTION	10/15/2019
Southern AE	
7951 Traxon Circle Austell, Ga 30168 (770) 919-7777	REVISIONS
architects & engineers	R # Doc # Date
	1 AD1 11.4.2019

FACILITY CODE NUMBER: 674-0110
GYMNASIUM/AUDITORIUM FOR:
HEARD COUNTY SCHOOLS
545 MAIN STREET, FRANKLIN, GA 30217
HEARD COUNTY SCHOOL SYSTEM
FRANKLIN, GEORGIA

AUDITORIUM - LEVEL 01 - POWER PLAN

STATE OF GEORGIA REGISTERED PROFESSIONAL ARCHITECT No. 27152 JAMES M. CAMPBELL FRANKLIN, GEORGIA	DRAWING NUMBER E111
--------------------------------------------------------------------------------------------------------------	-------------------------------