




#	KEYNOTE DESCRIPTION
L14	ROUTE THROUGH RELAY PANEL
L21	THEATRICAL LIGHTING NETS DMX OUT AS REQUIRED FOR CONNECTION AND CONTROL OF TYPE 'W' WALL WASH FIXTURES IN LOBBY AREA.

THEATRICAL FIXTURE SYMBOLS	
	COLOR MIXING LED PROFILE - PEARL (COORDINATE LENS W/ OWNER)
	COLOR MIXING LED PROFILE - FLAT (COORDINATE LENS W/ OWNER)
	COLOR MIXING LED WASH (PAR) (COORDINATE LENS W/ OWNER)
	COLOR MIXING LED CYC
	FOLLOW SPOT WASHSTAND

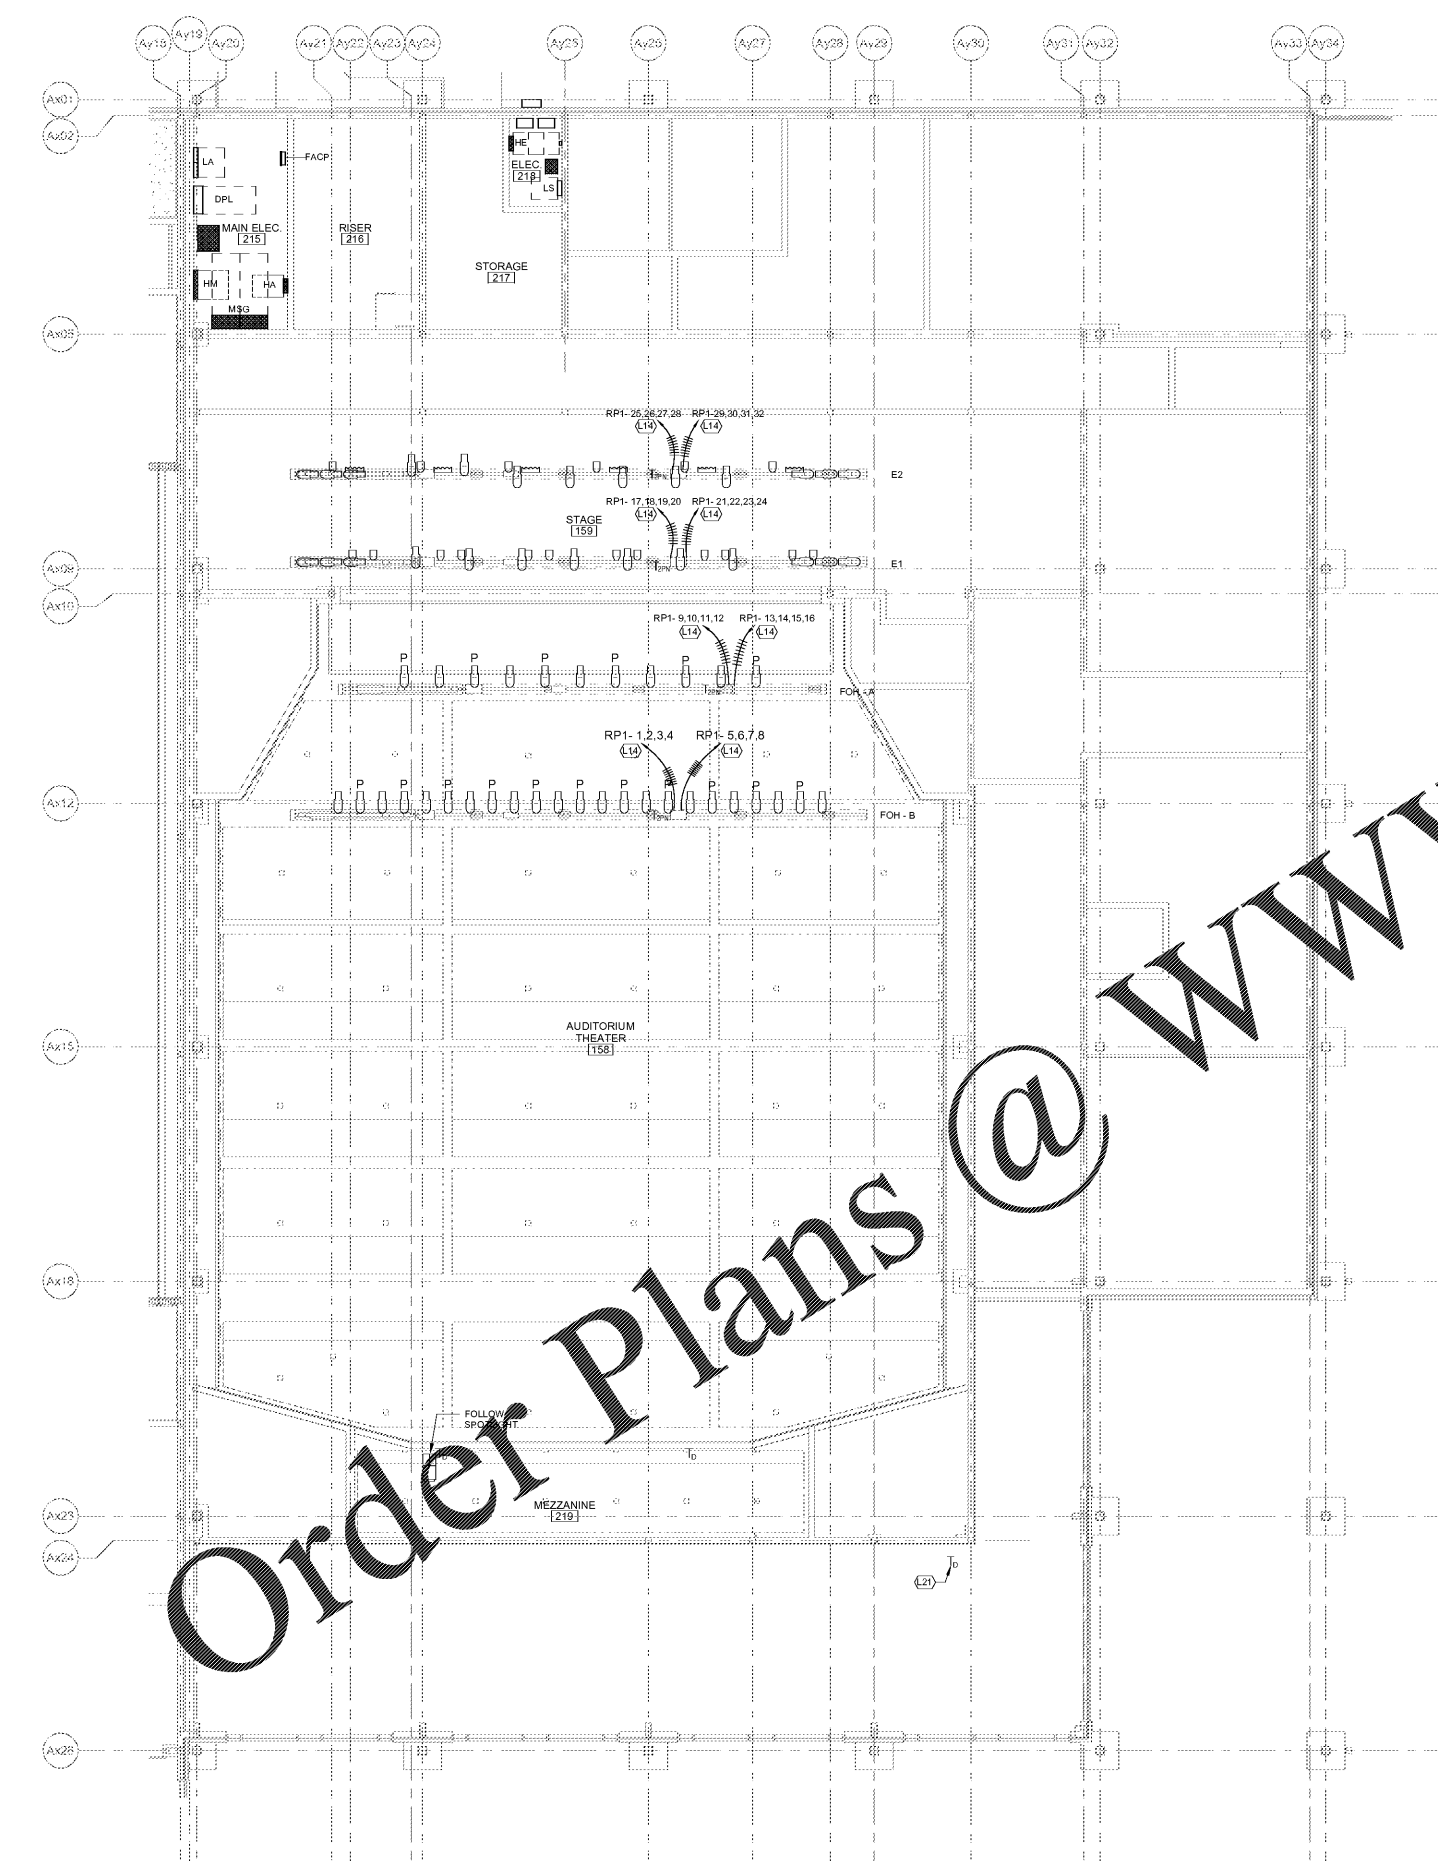

Order Plans @ www.LDILine.com

 www.LDILine.com

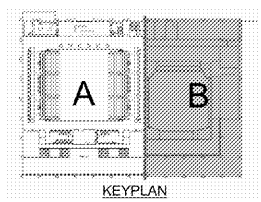

SA&E PROJECT NUMBER	01-615-056					
BID PACKAGE	BP-1					
ISSUED FOR CONSTRUCTION	10/15/2019					
Southern AE 7951 Troon Circle Austell, Ga 30168 (770) 819-7777 architects & engineers	REVISIONS					
	<table border="1"> <thead> <tr> <th>R #</th> <th>Doc #</th> <th>Date</th> </tr> </thead> <tbody> <tr> <td>1</td> <td>AD1</td> <td>11.4.2019</td> </tr> </tbody> </table>	R #	Doc #	Date	1	AD1
R #	Doc #	Date				
1	AD1	11.4.2019				
FACILITY CODE NUMBER: 674-0110 GYMNASIUM/AUDITORIUM FOR: HEARD COUNTY SCHOOLS 545 MAIN STREET, FRANKLIN, GA 30217 HEARD COUNTY SCHOOL SYSTEM FRANKLIN, GEORGIA						
AUDITORIUM - LEVEL 02 - THEATRICAL PERFORMANCE LIGHTING PLAN						
	DRAWING NUMBER E117					

1 LEVEL 02 - THEATRICAL PERFORMANCE LIGHTING PLAN
1/8" = 1'-0"