


GENERAL NOTES

- A. ALL RECEPTACLES SHALL BE GROUNDED AS REQUIRED BY ARTICLE 250-146.
- B. ALL EQUIPMENT LOCATIONS ARE TO BE COORDINATED WITH ARCHITECT DRAWINGS PRIOR TO ROUGH-IN. COORDINATE ALL REQUIREMENTS WITH ARCHITECT AND MANUFACTURER PRIOR TO ROUGH-IN.
- C. ALL MECHANICAL EQUIPMENT LOCATIONS AND REQUIREMENTS ARE TO BE COORDINATED WITH MECHANICAL DRAWINGS PRIOR TO ROUGH-IN.
- D. FIRE ALARM BATTERY CALCULATION TO BE PROVIDED AND APPROVED BY THE PROPER FIRE MARSHAL AUTHORITY.
- E. ELECTRICAL CONTRACTOR SHALL COORDINATE WITH MECHANICAL CONTRACTOR FOR EQUIPMENT INCLUDING VFD'S. COORDINATE AND CONFIRM CONDUIT AND POWER REQUIREMENTS WITH MANUFACTURER PRIOR TO ROUGH-IN AND INSTALL.

KEY NOTES

- ① EXISTING SERVICE ENTRANCE TO BE RELOCATED TO THIS LOCATION. EXTEND CONDUIT AND WIRE AS NEEDED.

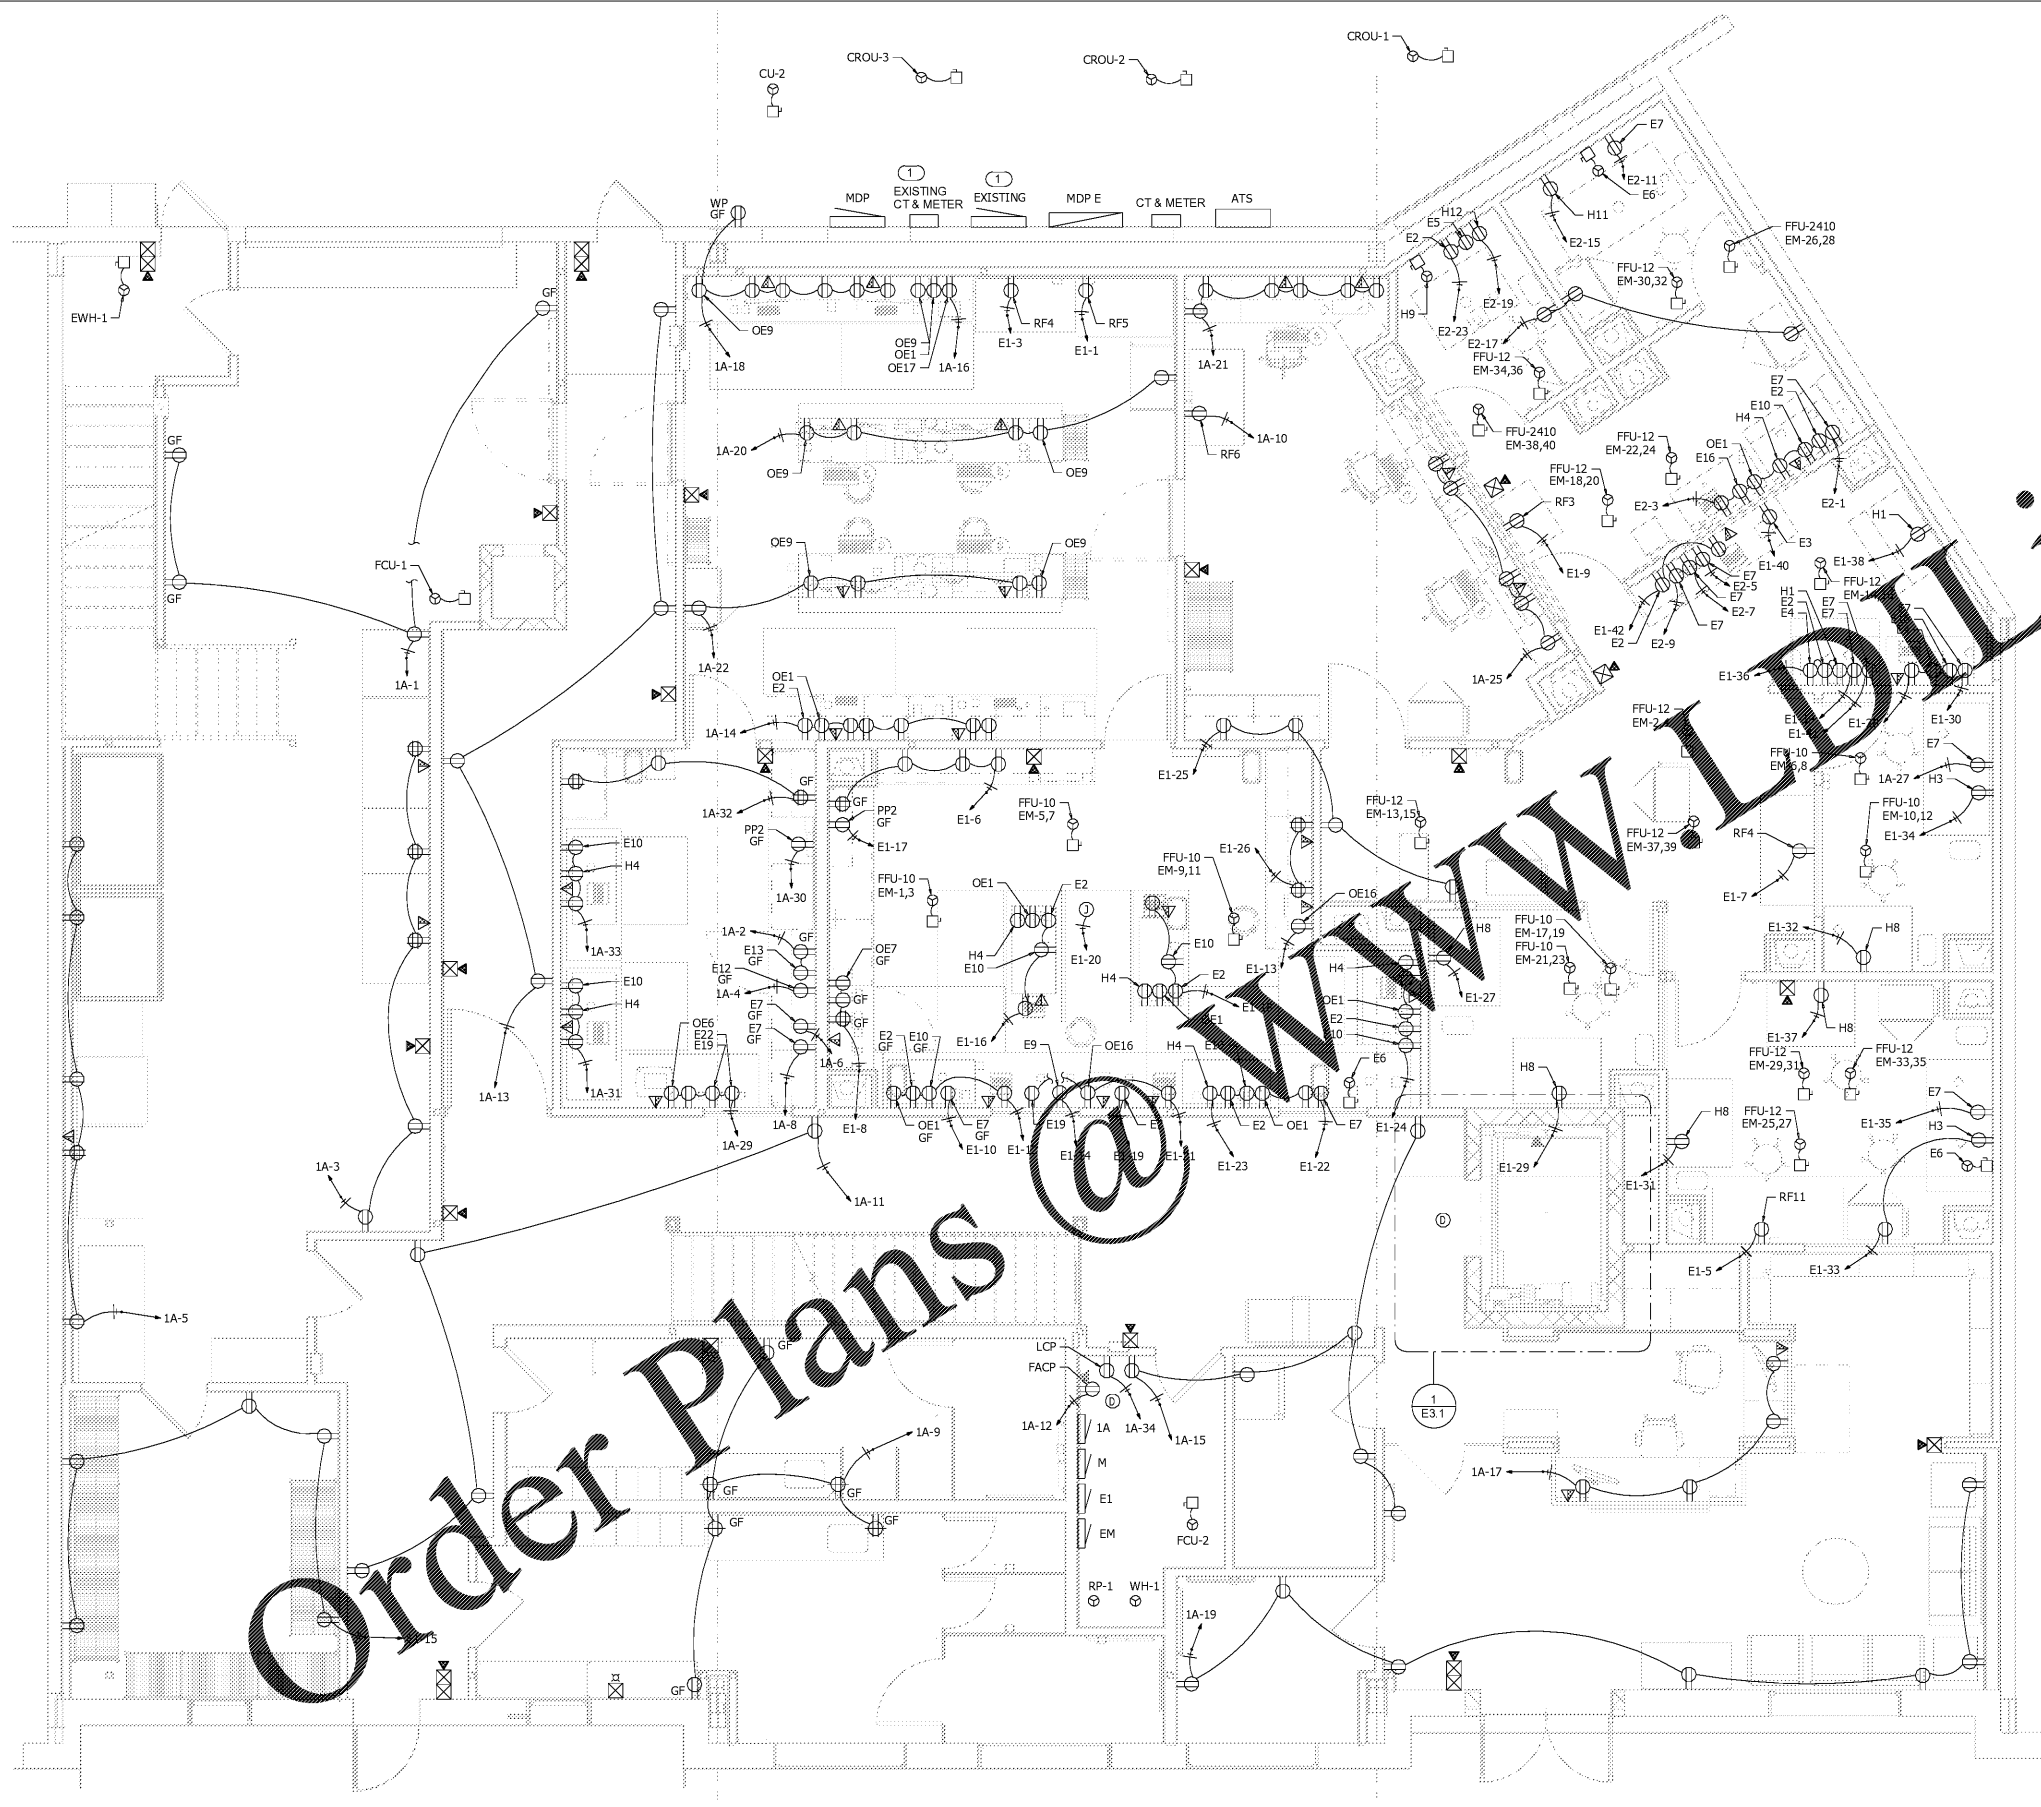

Order Plans @ WWW.IDDILLING.COM

① 1ST FLOOR PLAN - POWER
E1.1 1/4" = 1'-0"

THIS DRAWING IS THE PROPERTY OF CROSSFIELDS, INC. AND ANY REPRODUCTION OR COPYING OF THIS DRAWING, IN WHOLE OR PART IS PROHIBITED WITHOUT WRITTEN PERMISSION.

**INNOVATION
COMPOUNDING
DR. SHAWN HODGES**
6095 PINE MOUNTAIN RD. SUITE 104
KENNESAW, GA 30152

REVISIONS:

NO.	DATE	DESCRIPTION

DRAWN BY: AT CHECKED BY: BA
DATE: 09.24.19
PROJECT NUMBER: 17125-IC
SHEET NO:

E1.1

ISSUED FOR PERMITTING