


GENERAL NOTES

- ALL RECEPTACLES SHALL BE GROUNDED AS REQUIRED BY ARTICLE 250-146.
- ALL EQUIPMENT LOCATIONS ARE TO BE COORDINATED WITH ARCHITECT DRAWINGS PRIOR TO ROUGH-IN. COORDINATE ALL REQUIREMENTS WITH ARCHITECT AND MANUFACTURER PRIOR TO ROUGH-IN.
- ALL MECHANICAL EQUIPMENT LOCATIONS AND REQUIREMENTS ARE TO BE COORDINATED WITH MECHANICAL DRAWINGS PRIOR TO ROUGH-IN.
- FIRE ALARM BATTERY CALCULATION TO BE DONE AND APPROVED BY THE PROPER FIRE MARSHAL AUTHORITY.
- ELECTRICAL CONTRACTOR SHALL COORDINATE WITH MECHANICAL CONTRACTOR FOR EQUIPMENT INCLUDING VFD'S. COORDINATE AND CONFIRM CONDUIT AND POWER REQUIREMENTS WITH MANUFACTURER PRIOR TO ROUGH-IN AND INSTALL.

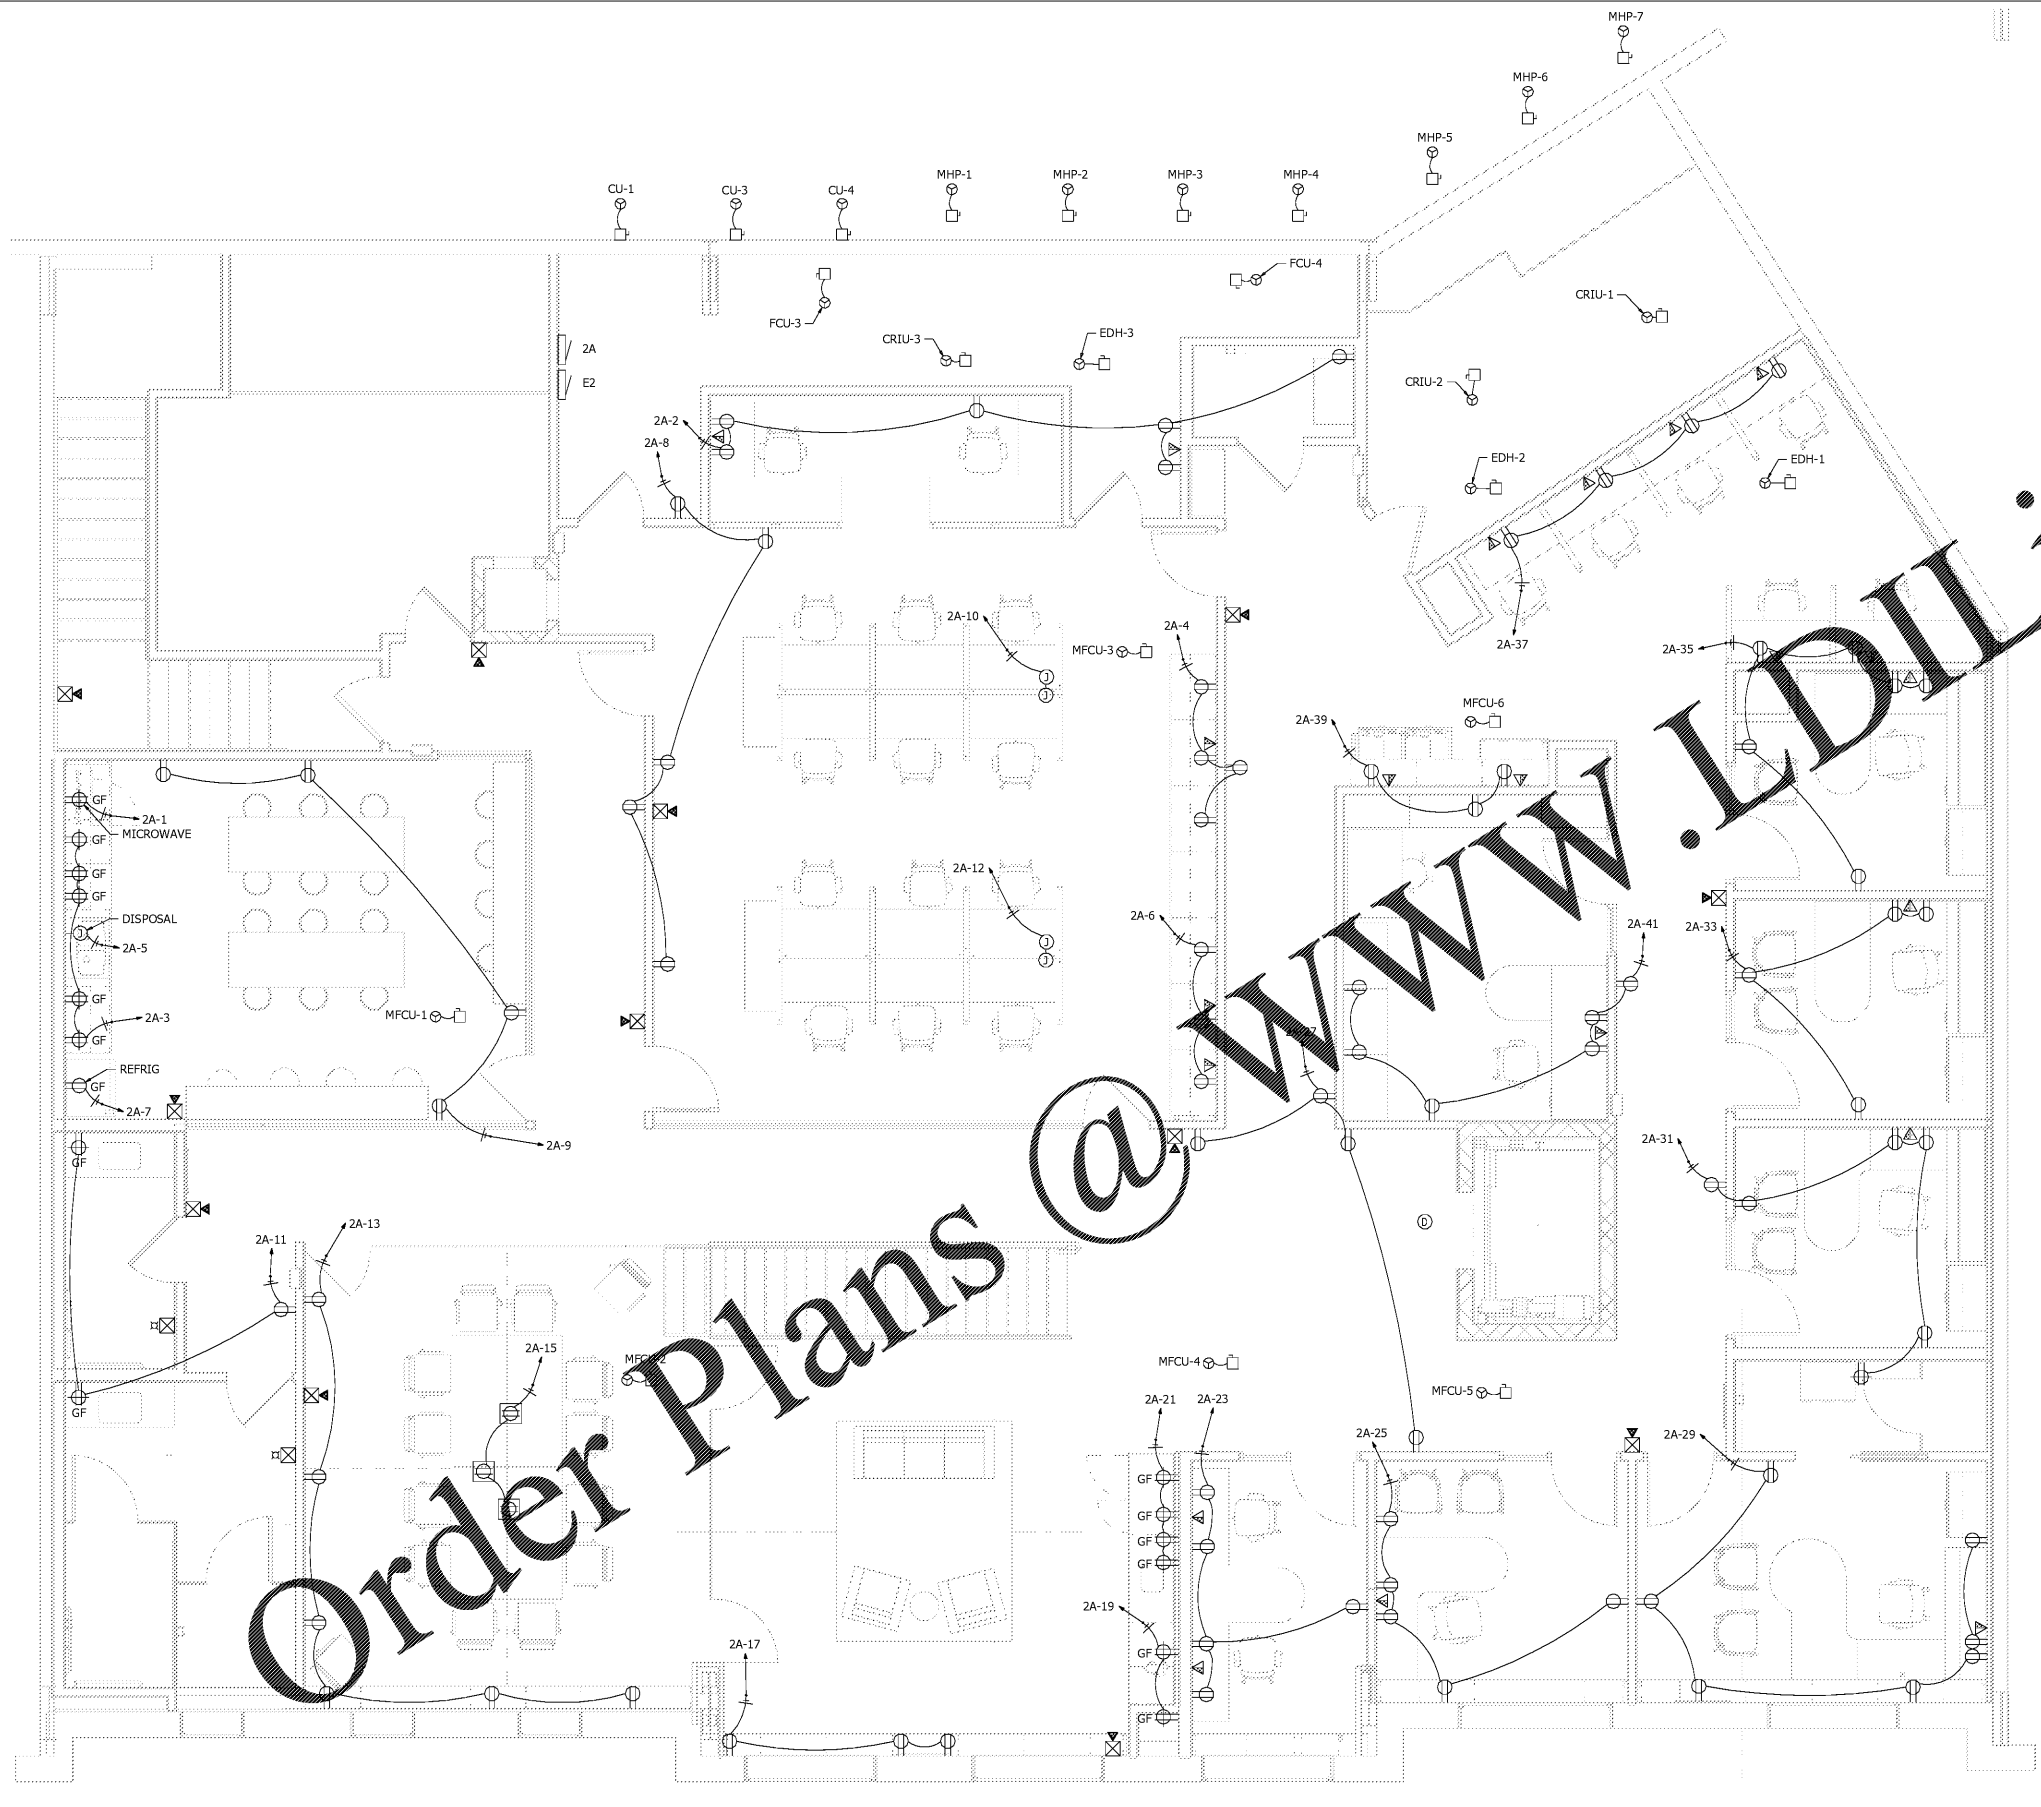

Order Plans @ www.LDILine.com

CROSSFIELDS
CHIROPRACTIC OFFICE DESIGN



THIS DRAWING IS THE PROPERTY OF CROSSFIELDS, INC. AND ANY REPRODUCTION OR COPYING OF THIS DRAWING, IN WHOLE OR PART IS PROHIBITED WITH OUT WRITTEN PERMISSION.

**INNOVATION
COMPOUNDING
DR. SHAWN HODGES**
6095 PINE MOUNTAIN RD, SUITE 104
KENNESAW, GA 30152

REVISIONS:

NO.	DATE	DESCRIPTION

DRAWN BY: **AT** CHECKED BY: **BA**
DATE: **09.24.19**
PROJECT NUMBER: **17125-IC**
SHEET NO:

1 2ND FLOOR PLAN - POWER
E1.2 1/4" = 1'-0"

E1.2

ISSUED FOR PERMITTING