


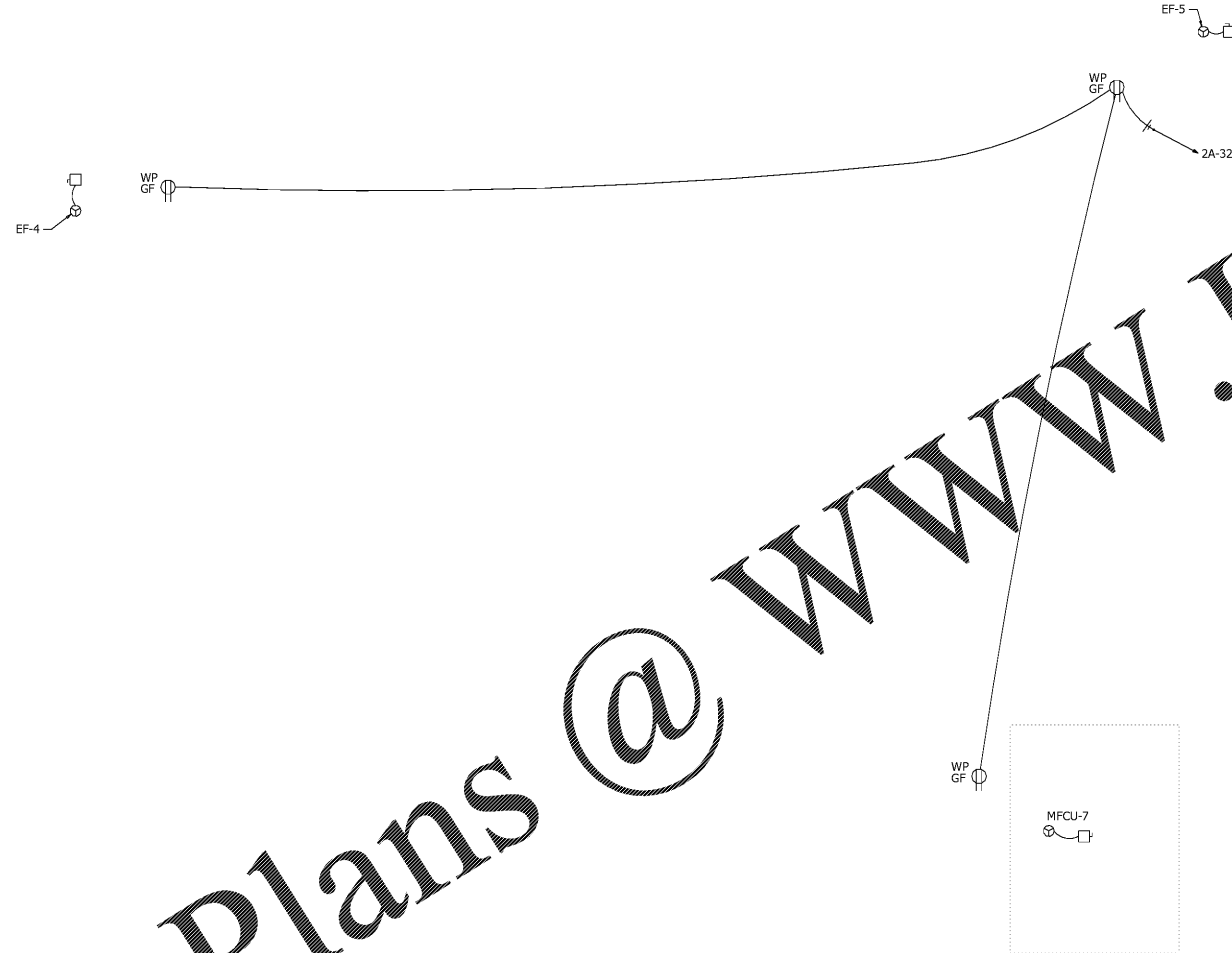

GENERAL NOTES

- A. ALL RECEPTACLES SHALL BE GROUNDED AS REQUIRED BY ARTICLE 250-146.
- B. ALL EQUIPMENT LOCATIONS ARE TO BE COORDINATED WITH ARCHITECT DRAWINGS PRIOR TO ROUGH-IN. COORDINATE ALL REQUIREMENTS WITH ARCHITECT AND MANUFACTURER PRIOR TO ROUGH-IN.
- C. ALL MECHANICAL EQUIPMENT LOCATIONS AND REQUIREMENTS ARE TO BE COORDINATED WITH MECHANICAL DRAWINGS PRIOR TO ROUGH-IN.
- D. ALL RECEPTACLES ARE TO BE TOMBSTONE TYPE MOUNTED RECEPTACLES FOR MECHANICAL EQUIPMENT MAINTENANCE.



Order Plans @ [www.LDILine.com](http://www.LDILine.com)

CROSSFIELDS  
CHIROPRACTIC OFFICE DESIGN

2016 Copyright Crossfields, Inc.  
All Rights Reserved.  
Crossfields, Inc. 2016  
www.ChiropacificOfficeDesign.com



THIS DRAWING IS THE PROPERTY OF CROSSFIELDS, INC. AND ANY REPRODUCTION OR COPYING OF THIS DRAWING, IN WHOLE OR PART IS PROHIBITED WITH OUT WRITTEN PERMISSION.

INNOVATION  
COMPOUNDING  
DR. SHAWN HODGES  
6095 PINE MOUNTAIN RD. SUITE 104  
KENNESAW, GA 30152

REVISIONS:

| NO. | DATE | DESCRIPTION |
|-----|------|-------------|
|     |      |             |
|     |      |             |
DRAWN BY: AT      CHECKED BY: BA  
 DATE: 09.24.19  
 PROJECT NUMBER: 17125-IC  
 SHEET NO:

E1.3

1 ROOF PLAN - POWER  
E1.3 1/4" = 1'-0"

ISSUED FOR PERMITTING