


GENERAL NOTES

- A. REFER TO ARCHITECTURAL REFLECTED CEILING PLAN FOR EXACT LOCATIONS OF ALL CEILING MOUNTED DEVICES.
- B. ALL LIGHTING FIXTURES ARE TO BE CONTROLLED BY PROGRAMMABLE LIGHTING CONTROL PANEL. COORDINATE ALL FIXTURE CONTROLS WITH ARCHITECT, OWNER, AND LIGHTING/CONTROLS SPECIALIST PRIOR TO ROUGH-IN.
- C. ALL LIGHTING FIXTURES ARE TO BE DIMMED AND CONFIRMED WITH ARCHITECT AND OWNER PRIOR TO PURCHASE AND INSTALL. LIGHTING FIXTURES ARE SHOWN FOR PROGRAMMATIC AND ELECTRICAL CHARACTERISTICS ONLY. ALL AESTHETIC FEATURES ARE TO BE COORDINATED WITH ARCHITECT AND OWNER.

KEYNOTES

- 1 DIMMER SWITCH TO BE DOWN STREAM OF CEILING MOUNTED OCCUPANCY SENSOR. LIGHTING FIXTURE ON/OFF TO BE CONTROLLED BY OCCUPANCY. DIMMER TO BE ACTIVE AFTER OCCUPANCY ON.
- 2 EXHAUST FAN TO BE SWITCHED WITH LIGHTS. COORDINATE EXACT LOCATION AND EQUIPMENT REQUIREMENTS WITH MANUFACTURER AND MECHANICAL DRAWINGS.

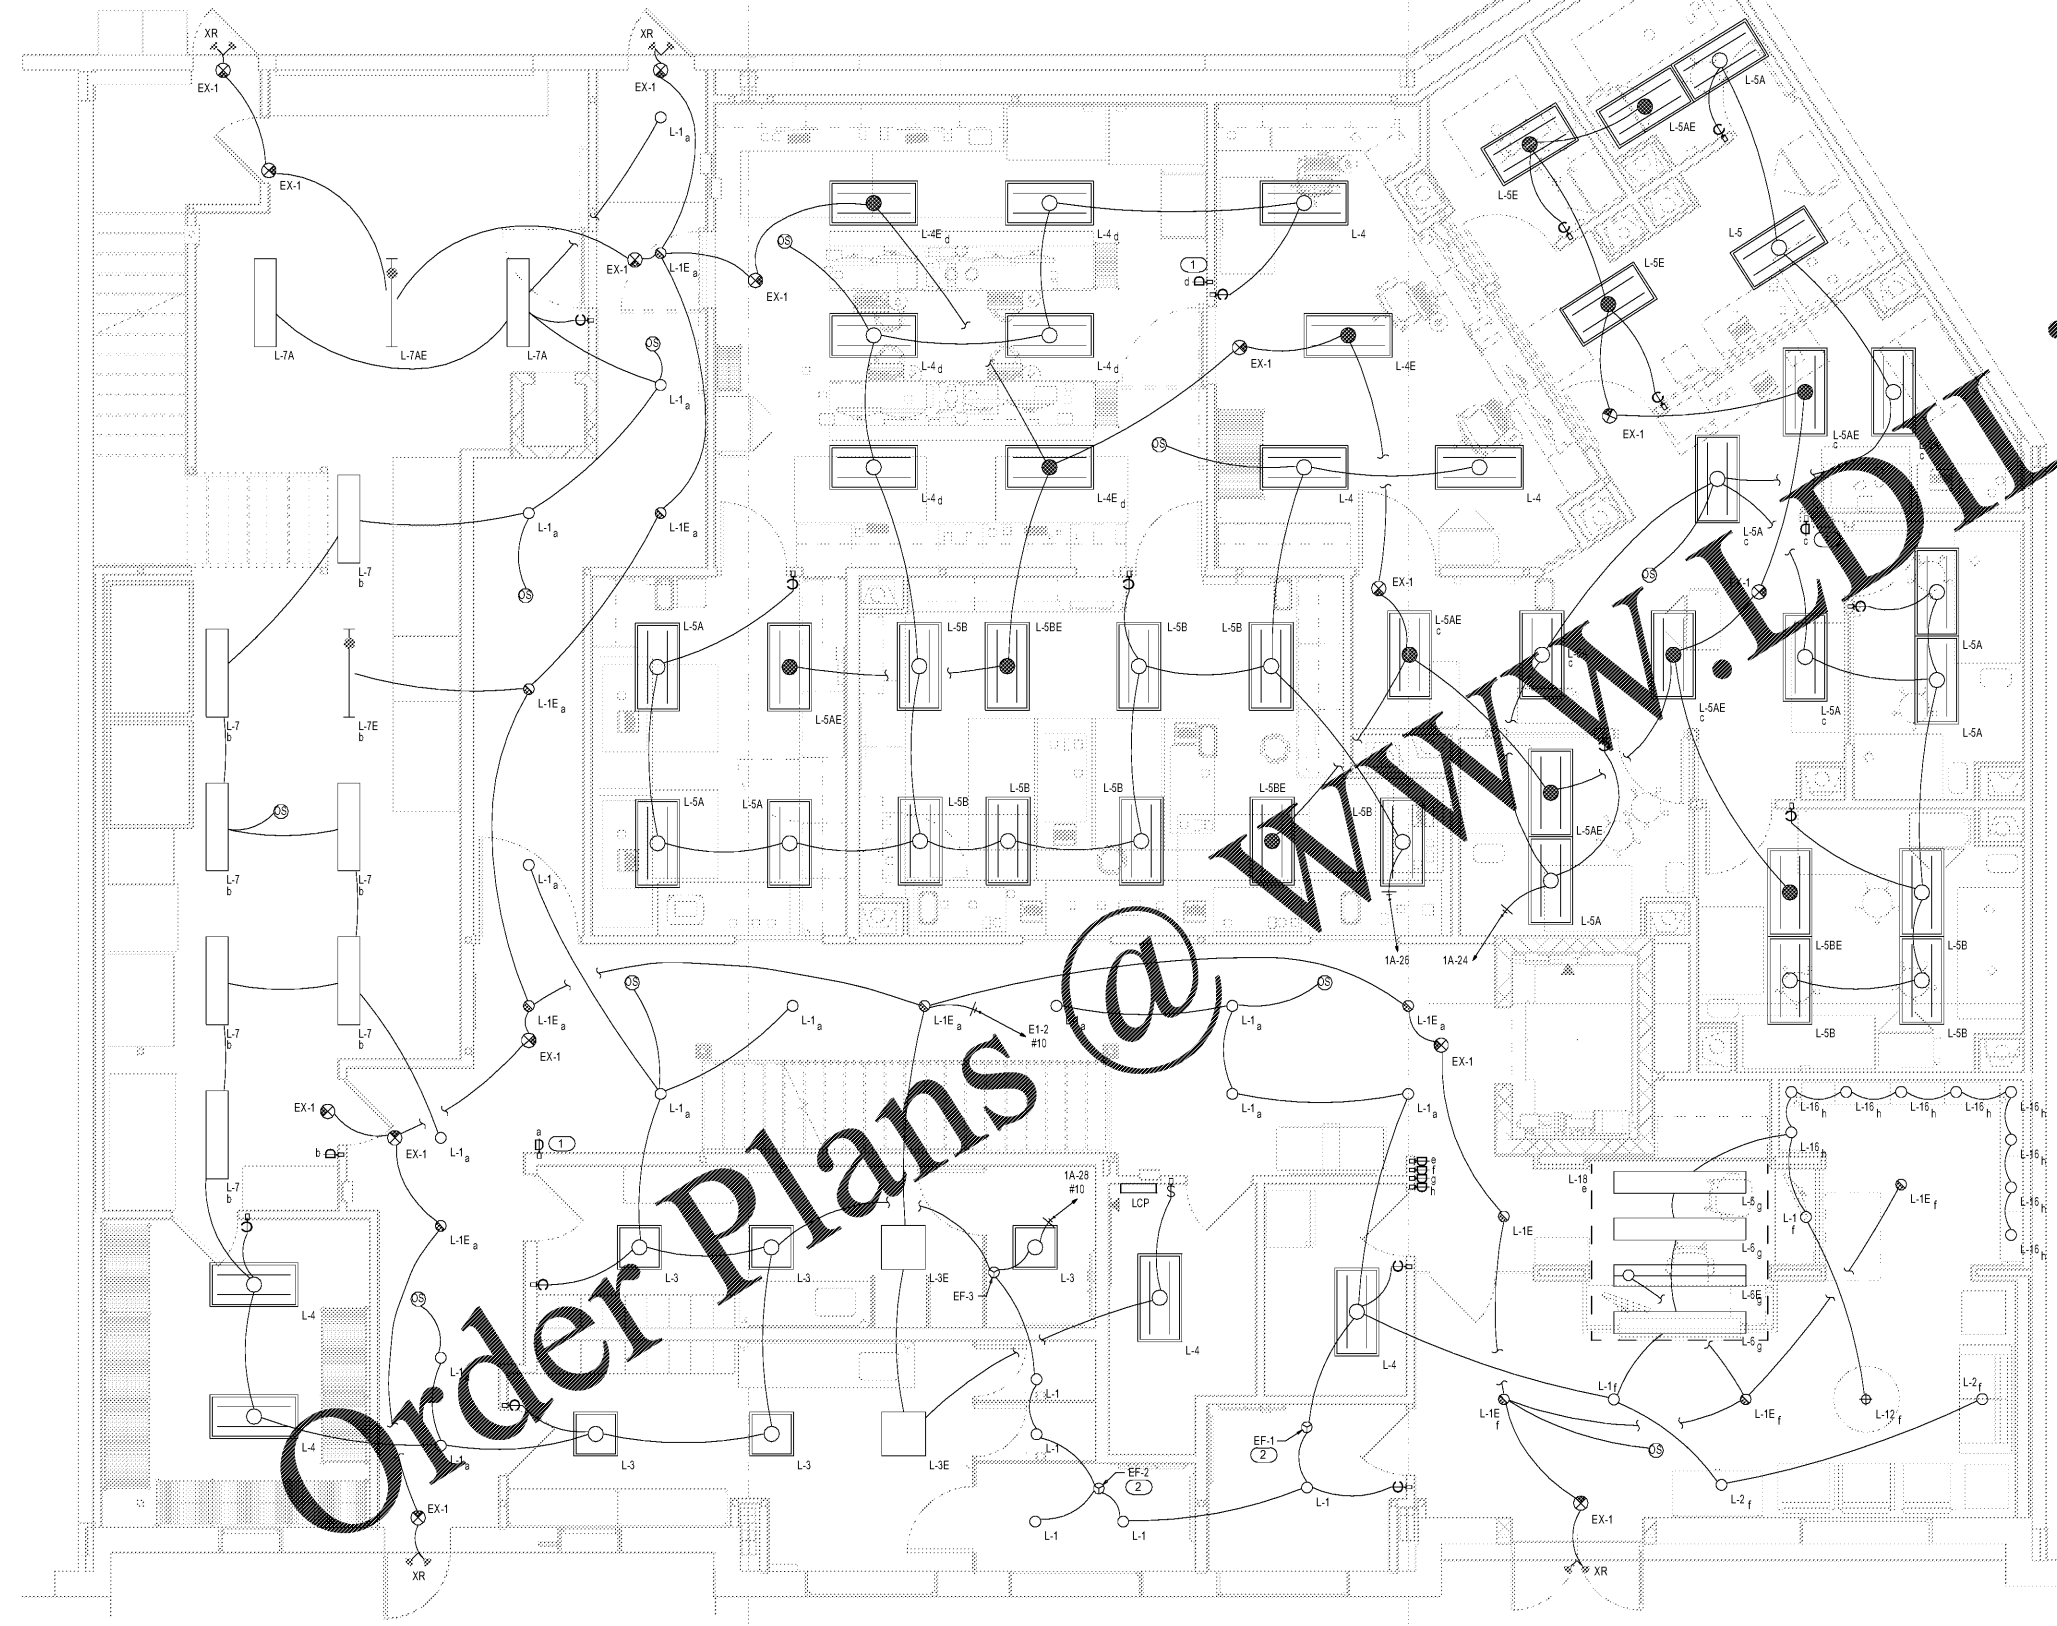

Order Plans @ www.wldline.com

1 1ST FLOOR PLAN - LIGHTING
E2.1 1/4" = 1'-0"



THIS DRAWING IS THE PROPERTY OF CROSSFIELDS, INC. AND ANY REPRODUCTION OR COPYING OF THIS DRAWING, IN WHOLE OR PART IS PROHIBITED WITH OUT WRITTEN PERMISSION.

**INNOVATION
COMPOUNDING
DR. SHAWN HODGES**
6095 PINE MOUNTAIN RD. SUITE 104
KENNESAW, GA 30152

REVISIONS:

| NO. | DATE | DESCRIPTION |
|-----|------|-------------|
| | | |
| | | |
| | | |
| | | |

DRAWN BY: AT
CHECKED BY: BA
DATE: 09.24.19
PROJECT NUMBER: 17125-IC
SHEET NO:

E2.1

ISSUED FOR PERMITTING